



| SEAL | CHECKED BY: | WCL |
|------|-------------|-----|
| | ORIG. BY | |
| | DATE | |
| | DESCRIPTION | |

| BUILDING: | DRAWING: | DATE: | DATE: | DATE: | DATE: | DATE: | DATE: |
|-----------|------------|---------|-------|-------|-------|-------|-------|
| | CP00178970 | 19AUG11 | | | | | |
| | | | | | | | |
| | | | | | | | |


| | |
|----------------|---|
| PROJECT TITLE: | STEAMLINE REPLACEMENT/REPAIR COLUMBIA CAMPUS - SP # H27-6031 |
| SHEET: | M-1 |
| | OF |
| SHEET IN SET: | |
| | OF |

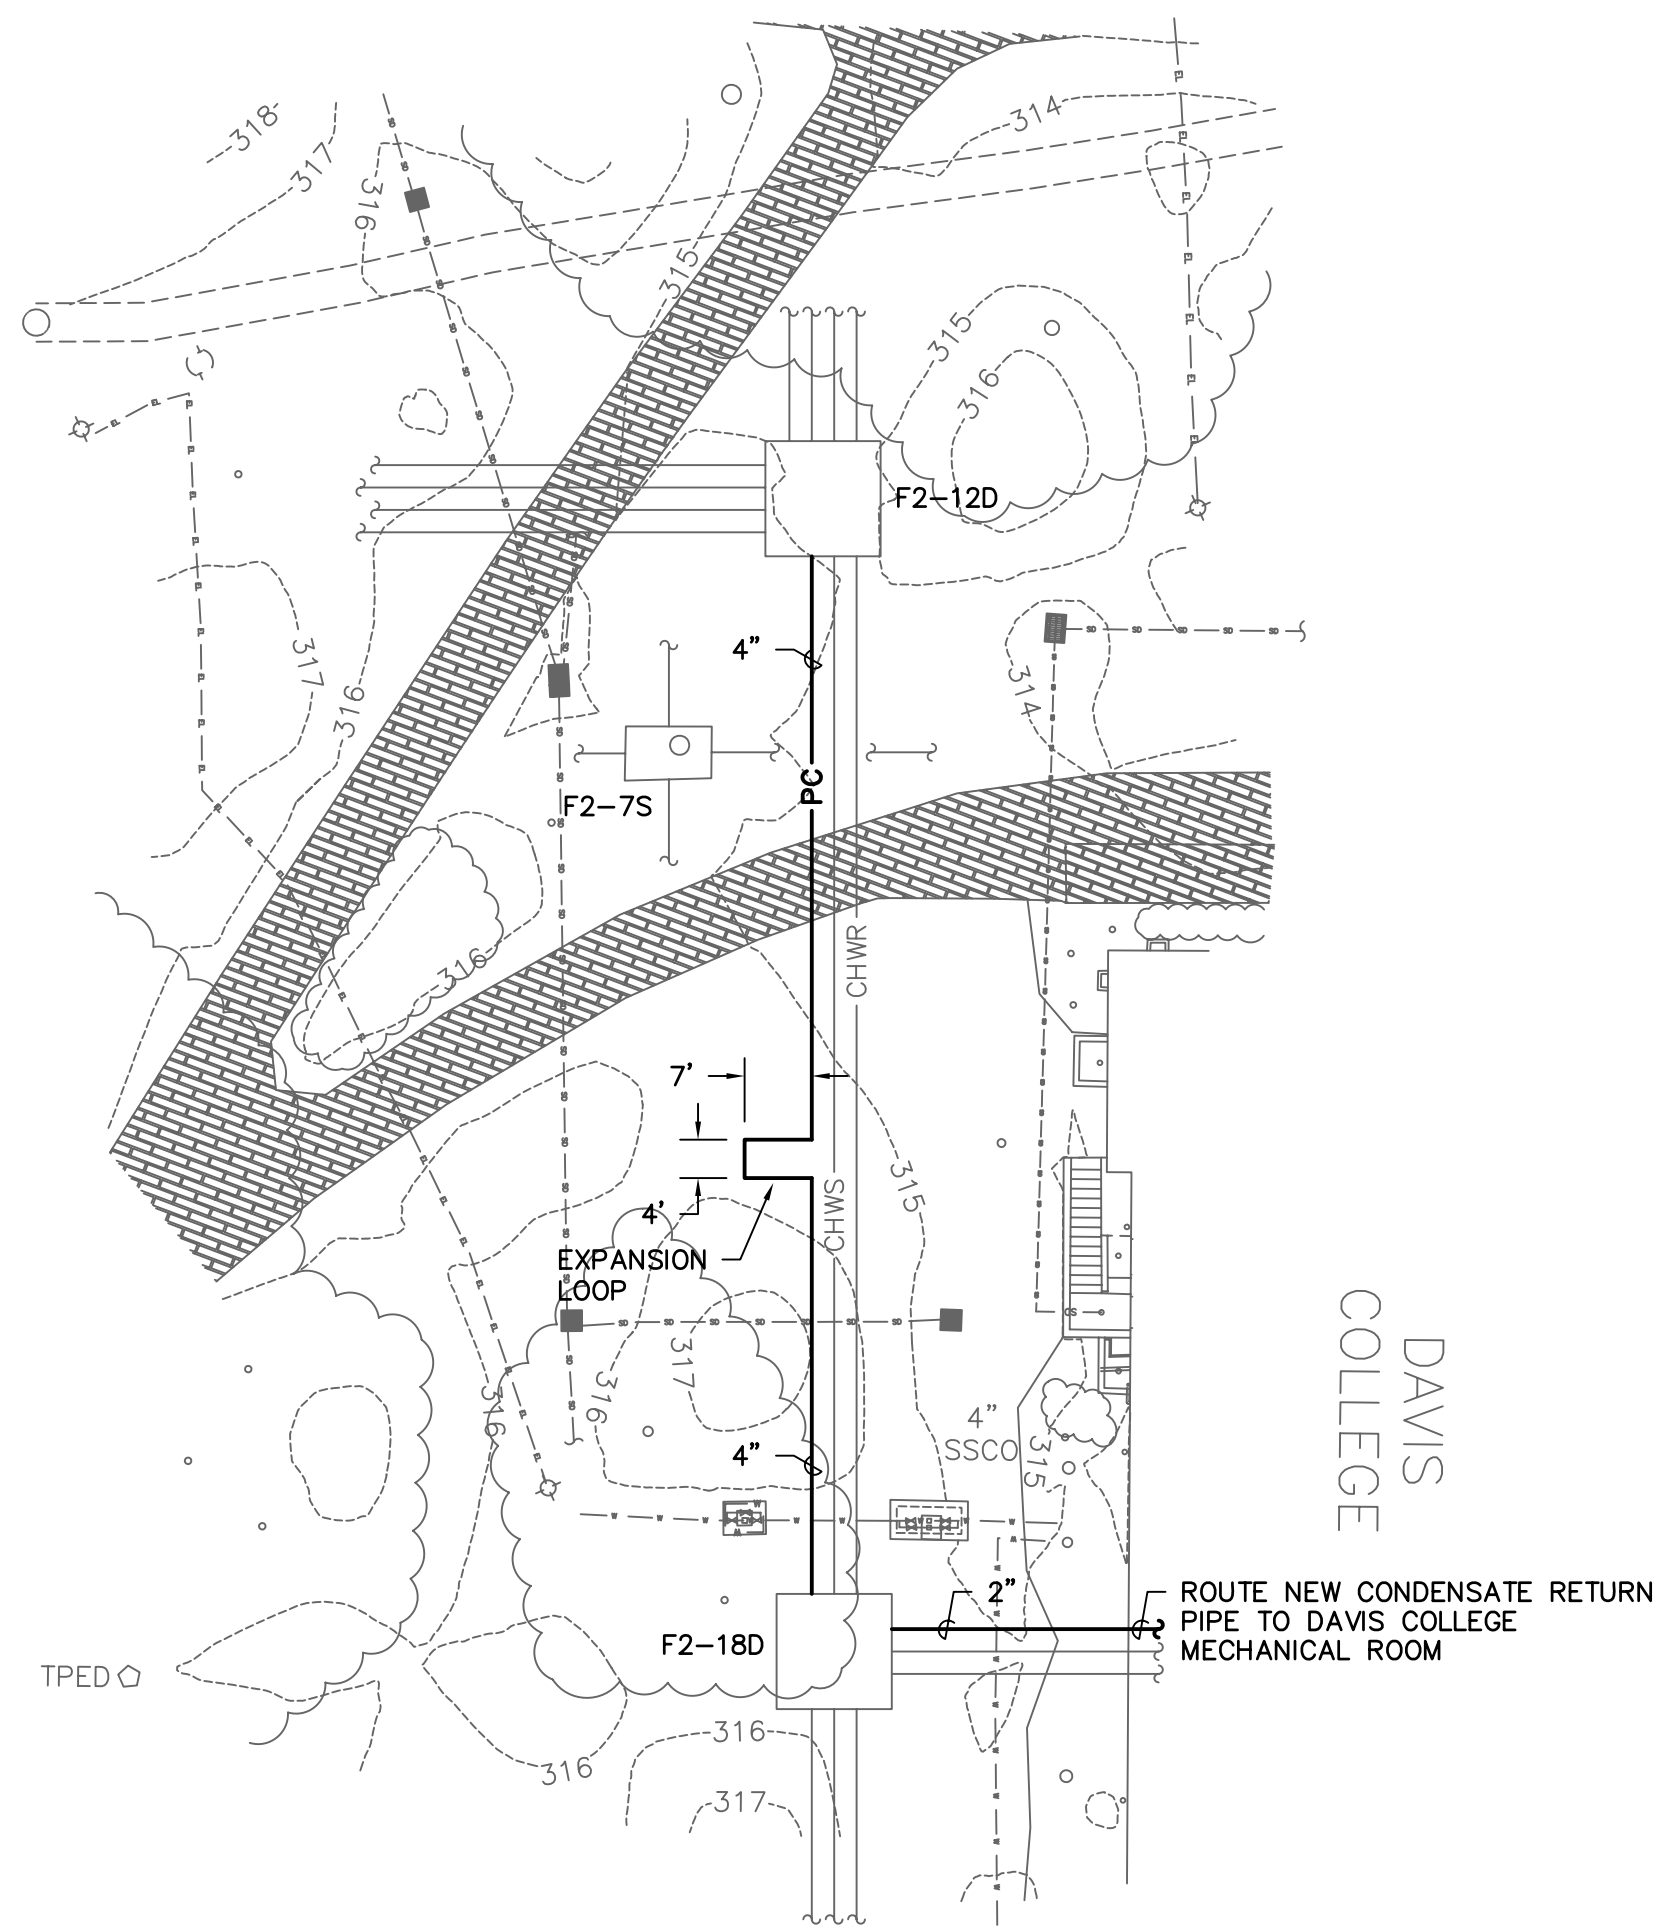


1 SITE PLAN - RENOVATION
SCALE: 1" = 20'

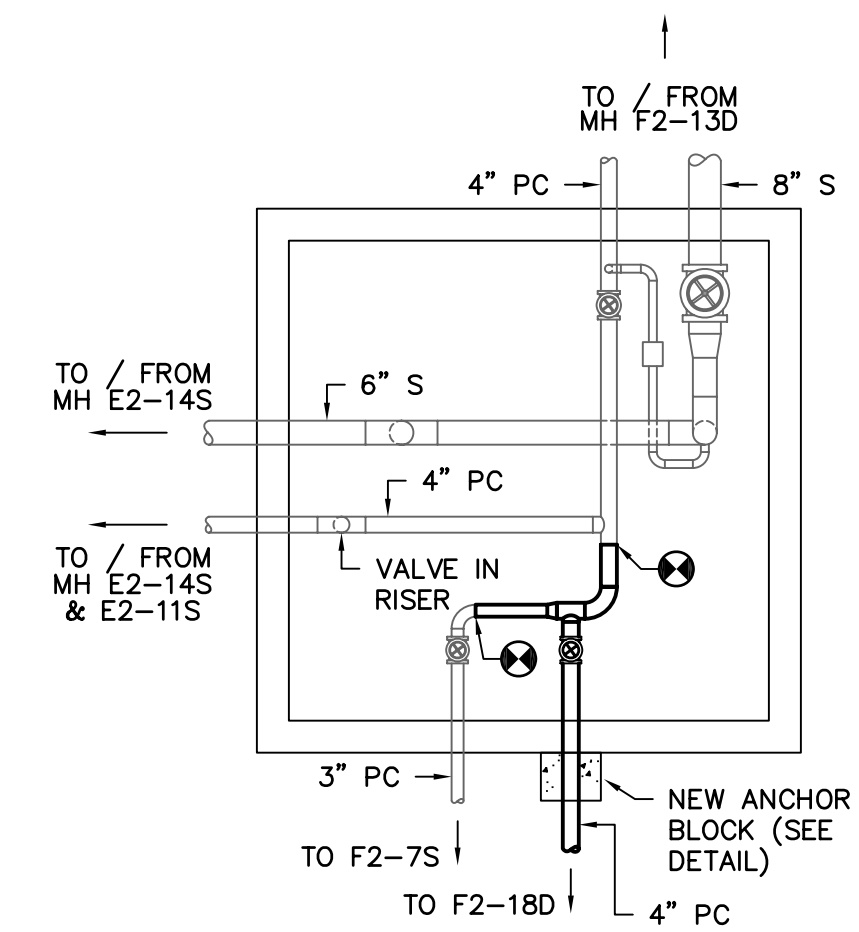

2 VAULT F2-12D
NO SCALE

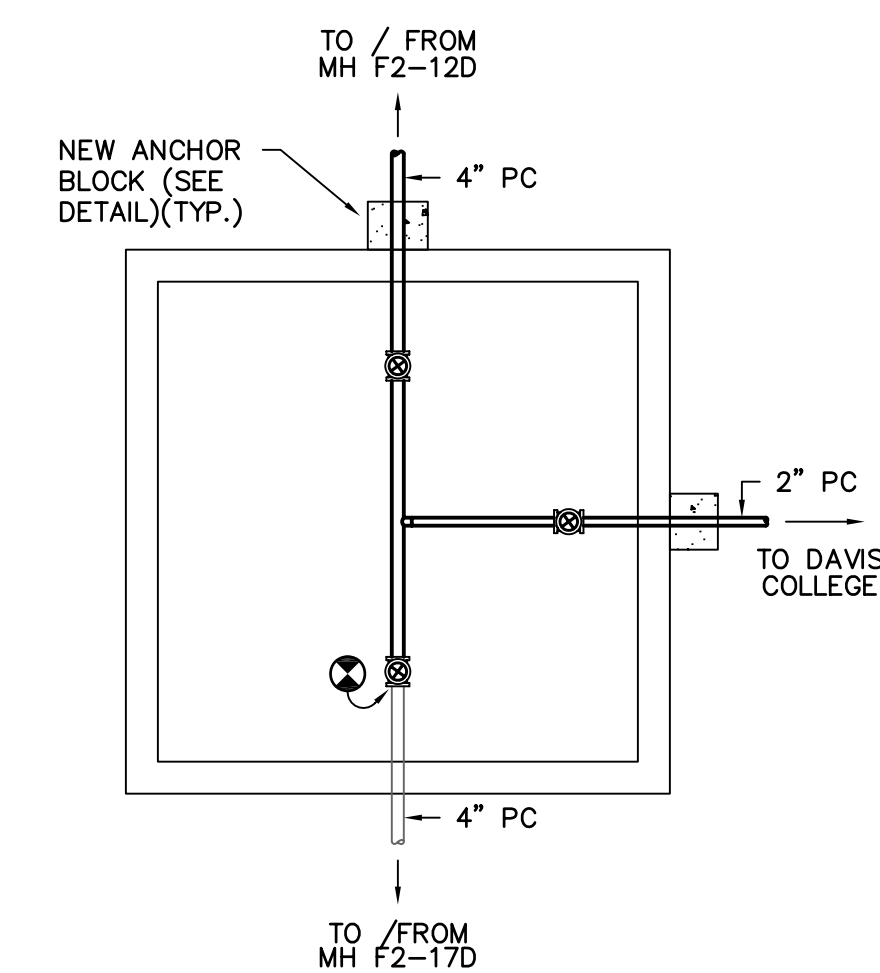

3 VAULT F2-18D
NO SCALE

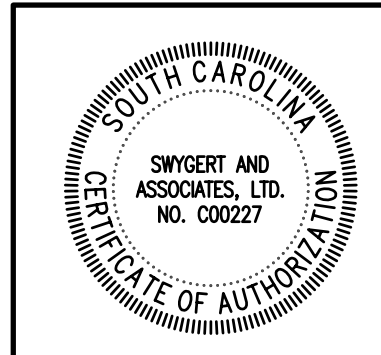

Swygert & Associates
CONSULTING ENGINEERS

DBA Swygert & Assoc., Ltd. Telephone: (803) 791-9300
Post Office Box 11886 Fax: (803) 791-9830
Columbia, S.C. 29211 mail@swygert-associates.com