

Equipment Table

Quantity	Symbol	Description	Size
27	●	MP Rotator - 1804 MP-1000 90°	1400 ft
11	●	MP Rotator - 1804 MP-1000 120°	1400 ft
121	●	MP Rotator - 1804 MP-1000 180°	1400 ft
1	●	MP Rotator - 1804 MP-1000 240°	1400 ft
7	●	MP Rotator - 1804 MP-2000 270°	1400 ft
9	●	MP Rotator - 1804 MP-2000 90°	2000 ft
2	●	MP Rotator - 1804 MP-2000 120°	2000 ft
114	●	MP Rotator - 1804 MP-2000 180°	2000 ft
3	●	MP Rotator - 1804 MP-2000 240°	2000 ft
2	●	MP Rotator - 1804 MP-2000 270°	2000 ft
4	●	MP Rotator - 1804 MP-2000 360°	2000 ft
2	●	MP Rotator - 1804 MP-3000 90°	3000 ft
1	●	MP Rotator - 1804 MP-3000 120°	3000 ft
3	●	MP Rotator - 1804 MP-3000 180°	3000 ft
1	●	MP Rotator - 1804 MP-3000 270°	3000 ft
1	●	MP Rotator - 1804 MP-3000 360°	3000 ft
1	●	MP Rotator - 1804 MP-Str-IP EST	1500 ft x 500 ft
1	●	MP Rotator - 1804 MP-Str-IP SST	3000 ft x 500 ft

Quantity	Symbol	Description	Size
100 ft	—	160 PSI SDR 21 PVC Pipe	1-1/2"
160 ft	—	160 PSI SDR 21 PVC Pipe	1-1/4"
4320 ft	—	200 PSI SDR 21 PVC Pipe	3/4"
840 ft	—	200 PSI SDR 21 PVC Pipe	1"
20 ft	—	160 PSI SDR 21 PVC Pipe	2-1/2"
80 ft	—	160 PSI SDR 21 PVC Pipe	2"


Quantity	Symbol	Description	Size
640 ft	—	160 PSI SDR 21 PVC Pipe	2-1/2"

Quantity	Symbol	Description	Size
40 ft	—	Schedule 40 PVC Pipe	6"
320 ft	—	Schedule 40 PVC Pipe	4"

Point of Connection	Symbol	Description	Size
1	M	3" Main	10000 gpm @ 6000 PSI

Valves	Symbol	Description	Size
1	⊕	200PEB Rainbird Electric Valve	2"
2	⊕	150PEB Rainbird Electric Valve	1-1/2"

Wires	Symbol	Description	Size
625 ft	—	14/1-COMMON	14
996 ft	—	14/1-HIT	14

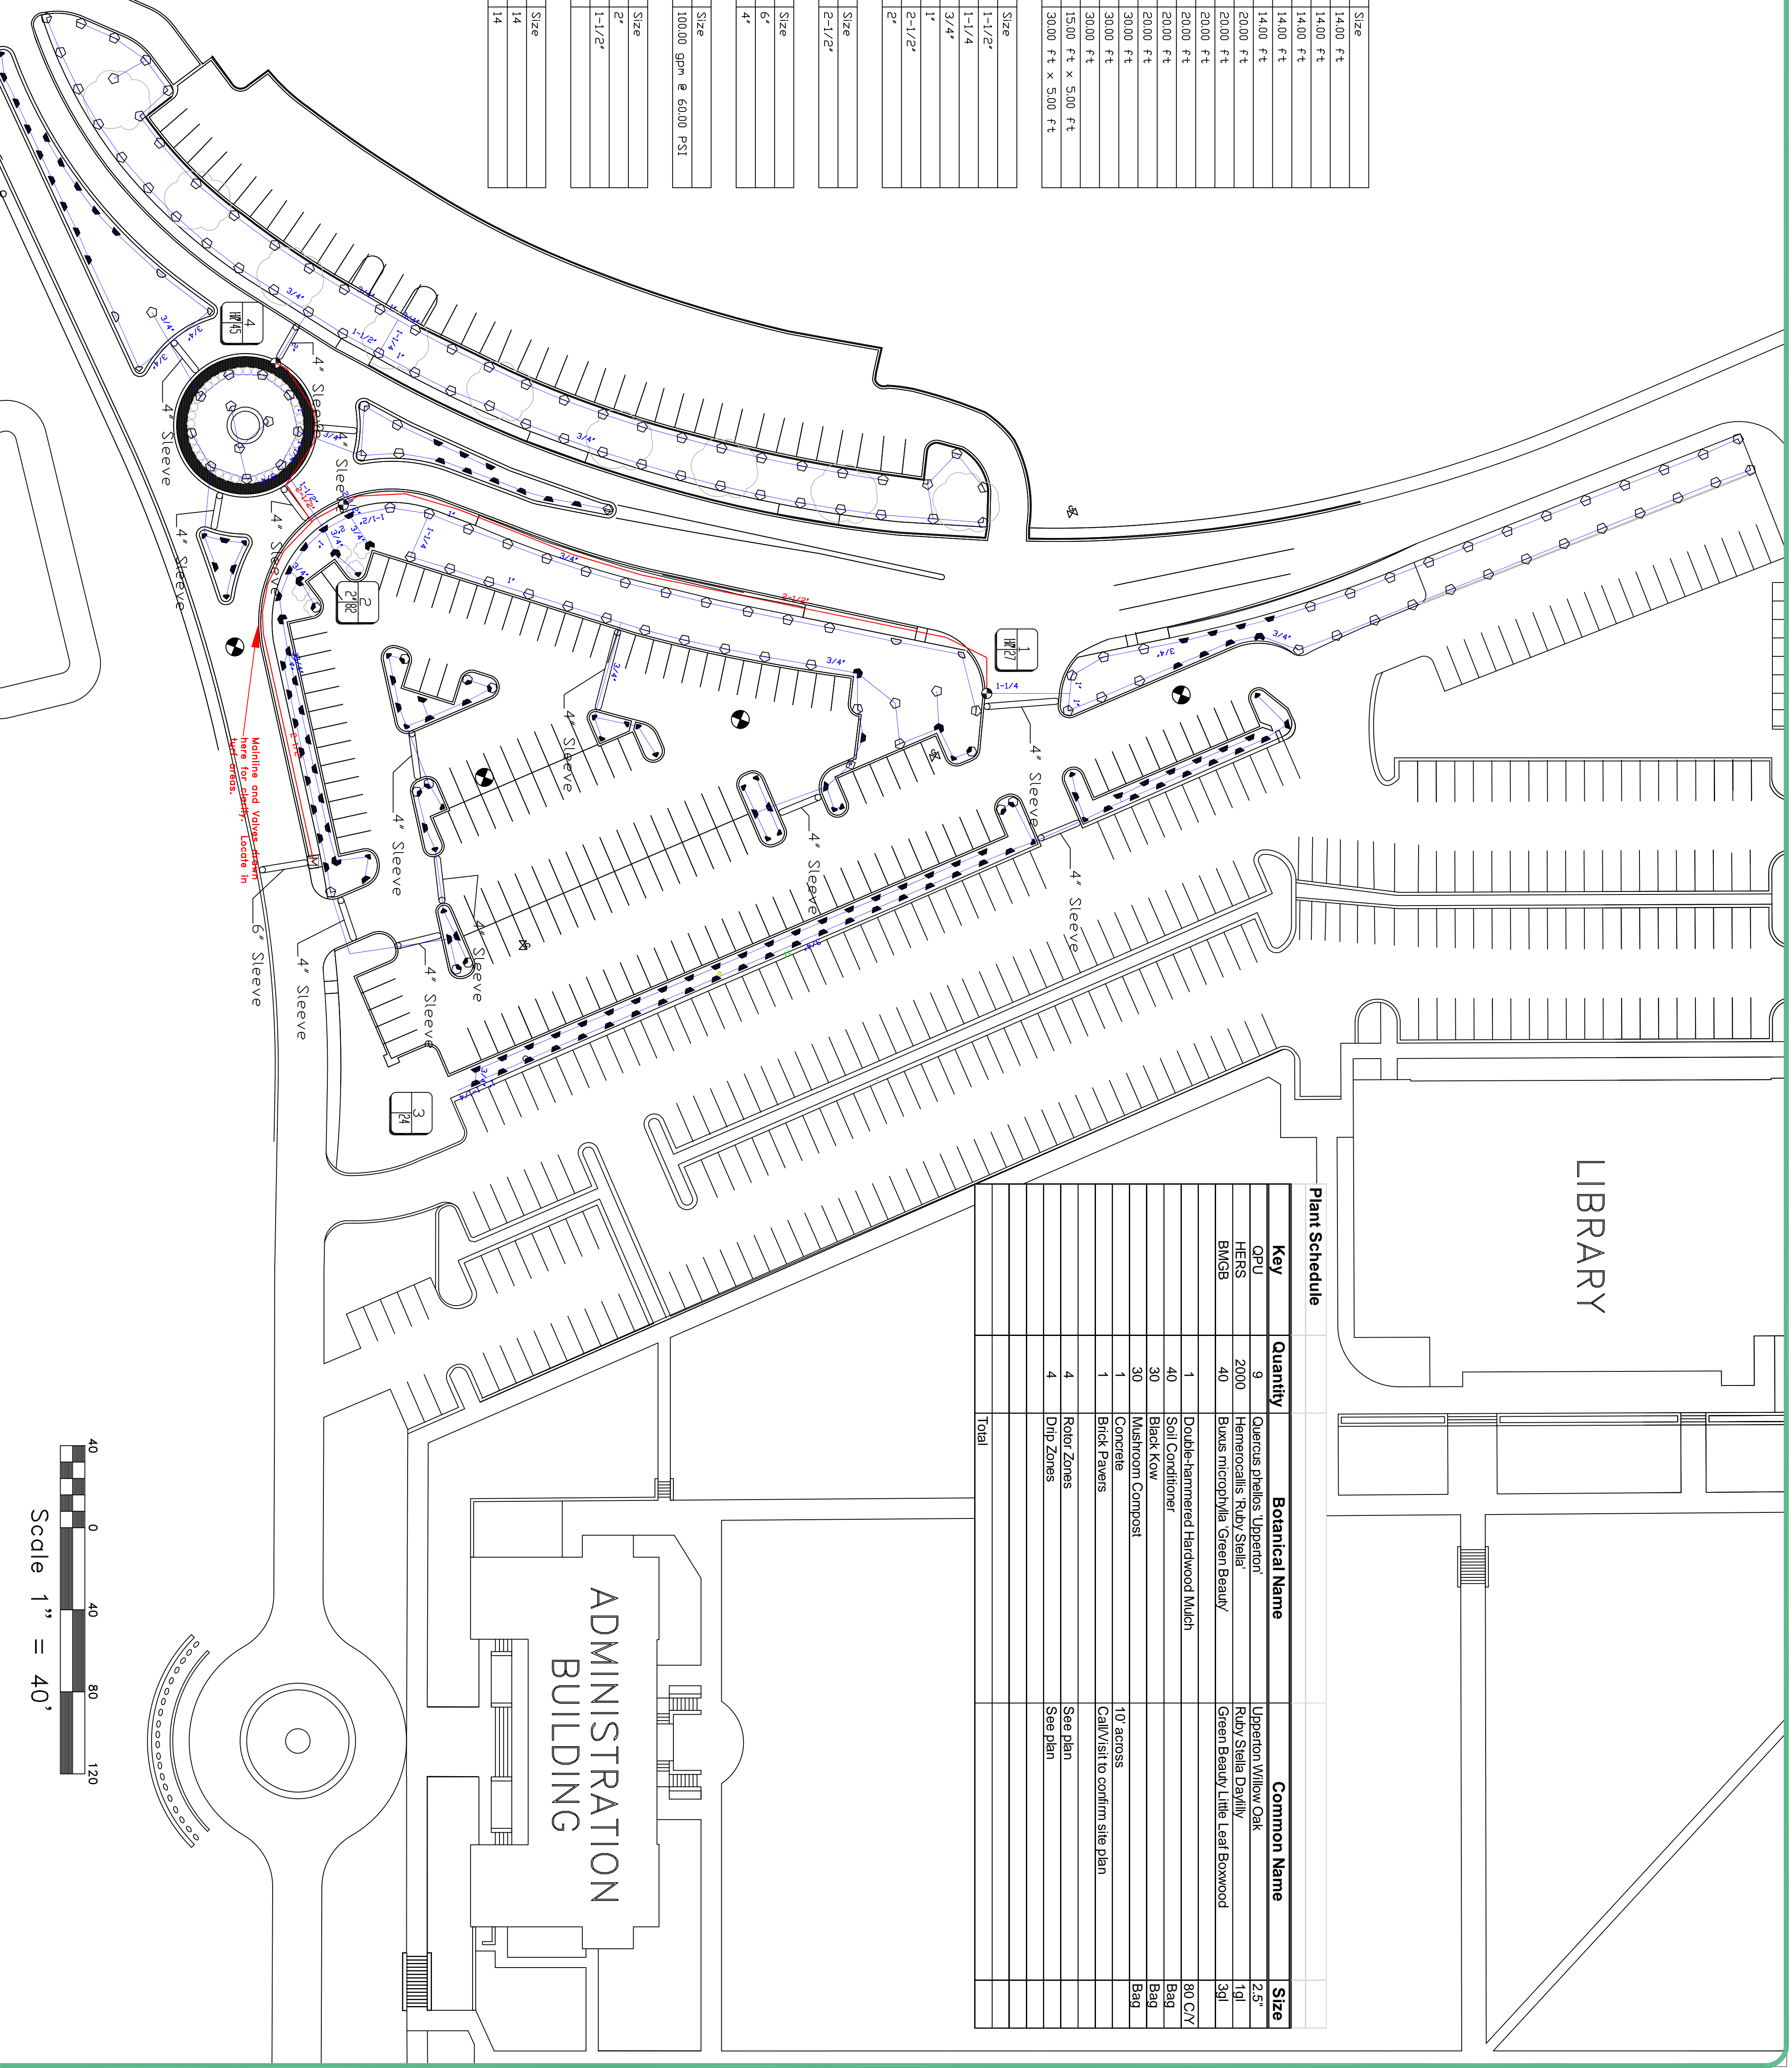


Plant Schedule

Key	Quantity	Botanical Name	Common Name	Size
QPU	9	Quercus phellos Upperton	Upperton Willow Oak	2.5"
HERS	2000	Hemerocallis Ruby Stella	Ruby Stella Daylily	1d
BMGB	40	Buxus microphylla Green Beauty	Green Beauty Little Leaf Boxwood	3d
	1	Double-Hammered Hardwood Mulch		80 C/Y
	40	Soil Conditioner		Bad
	30	Black Kow		Bad
	30	Mulchroom Compost		Bad
	1	Concrete	10' across	
	1	Brick Pavers	Call/Visit to confirm site plan	
	4	Rotor Zones	See plan	
	4	Drip Zones	See plan	
		Total		


LIBRARY

 ADMINISTRATION BUILDING



Scale 1" = 40'

NEW LANDSCAPING AT UNIVERSITY WAY TRAFFIC CIRCLE
CP00362345

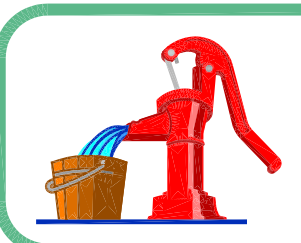

W.P. LAW INCORPORATED
2400 HWY 101 SOUTH GREER, SC 29651
(864)879-1045 FAX (864)879-1046

CAD FILE:
DRAWN BY: R/L
CHECKED BY:
DATE STARTED:
DATE FINISHED:
PAGE #: 1