



GENERAL PLAN NOTES

1. SEE T1.1 FOR MINIMUM REQUIRED ADA MANEUVERING CLEARANCES
2. DIMENSIONS INDICATED ON THESE DRAWINGS ARE TO FACE OF CONC., FACE OF EXTERIOR VENEER, FACE OF STUD, OR CENTERLINE OF COLUMN UNLESS OTHERWISE INDICATED. COORDINATE ALL DIMENSIONS WITH STRUCTURAL DIMENSION PLANS, ENLARGED PLANS, SECTION AND DETAIL DRAWINGS, AND STRUCTURAL DRAWINGS AND VERIFY EXACT LOCATIONS. COORDINATE ALL FLOOR SLAB PENETRATIONS WITH SYSTEM DRAWINGS AND ACTUAL PRODUCT TO BE INSTALLED AND VERIFY LOCATIONS WITH ARCHITECTURAL DRAWINGS PRIOR TO INSTALLATION.
3. SEE ROOF PLAN FOR ROOF AND PARAPET DETAIL REFERENCES, GENERAL ROOF NOTES AND ROOF LEGEND.

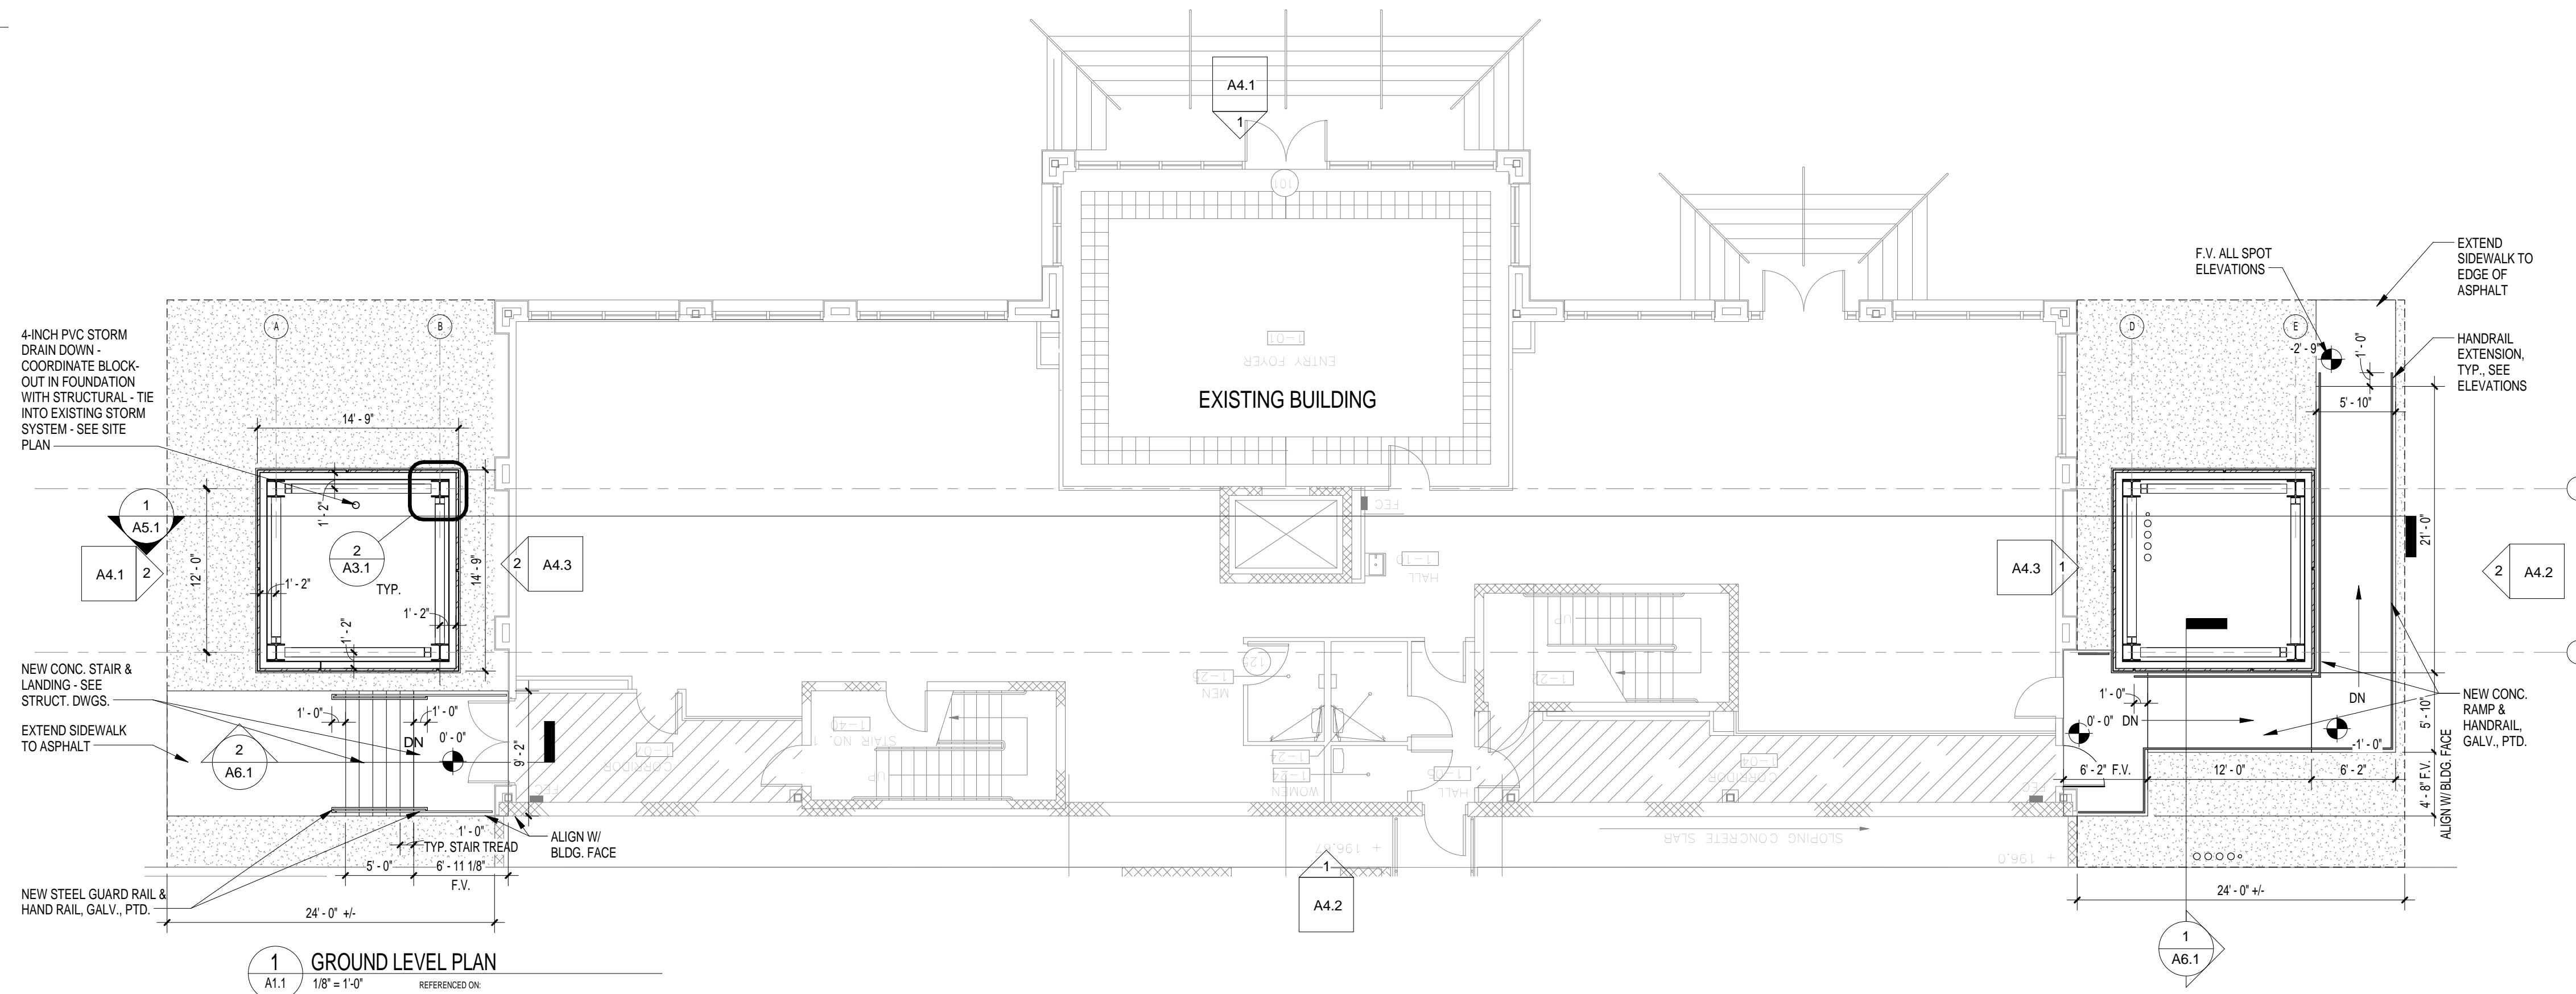

1 GROUND LEVEL PLAN
A1.1 1/8" = 1'-0" REFERENCED ON:

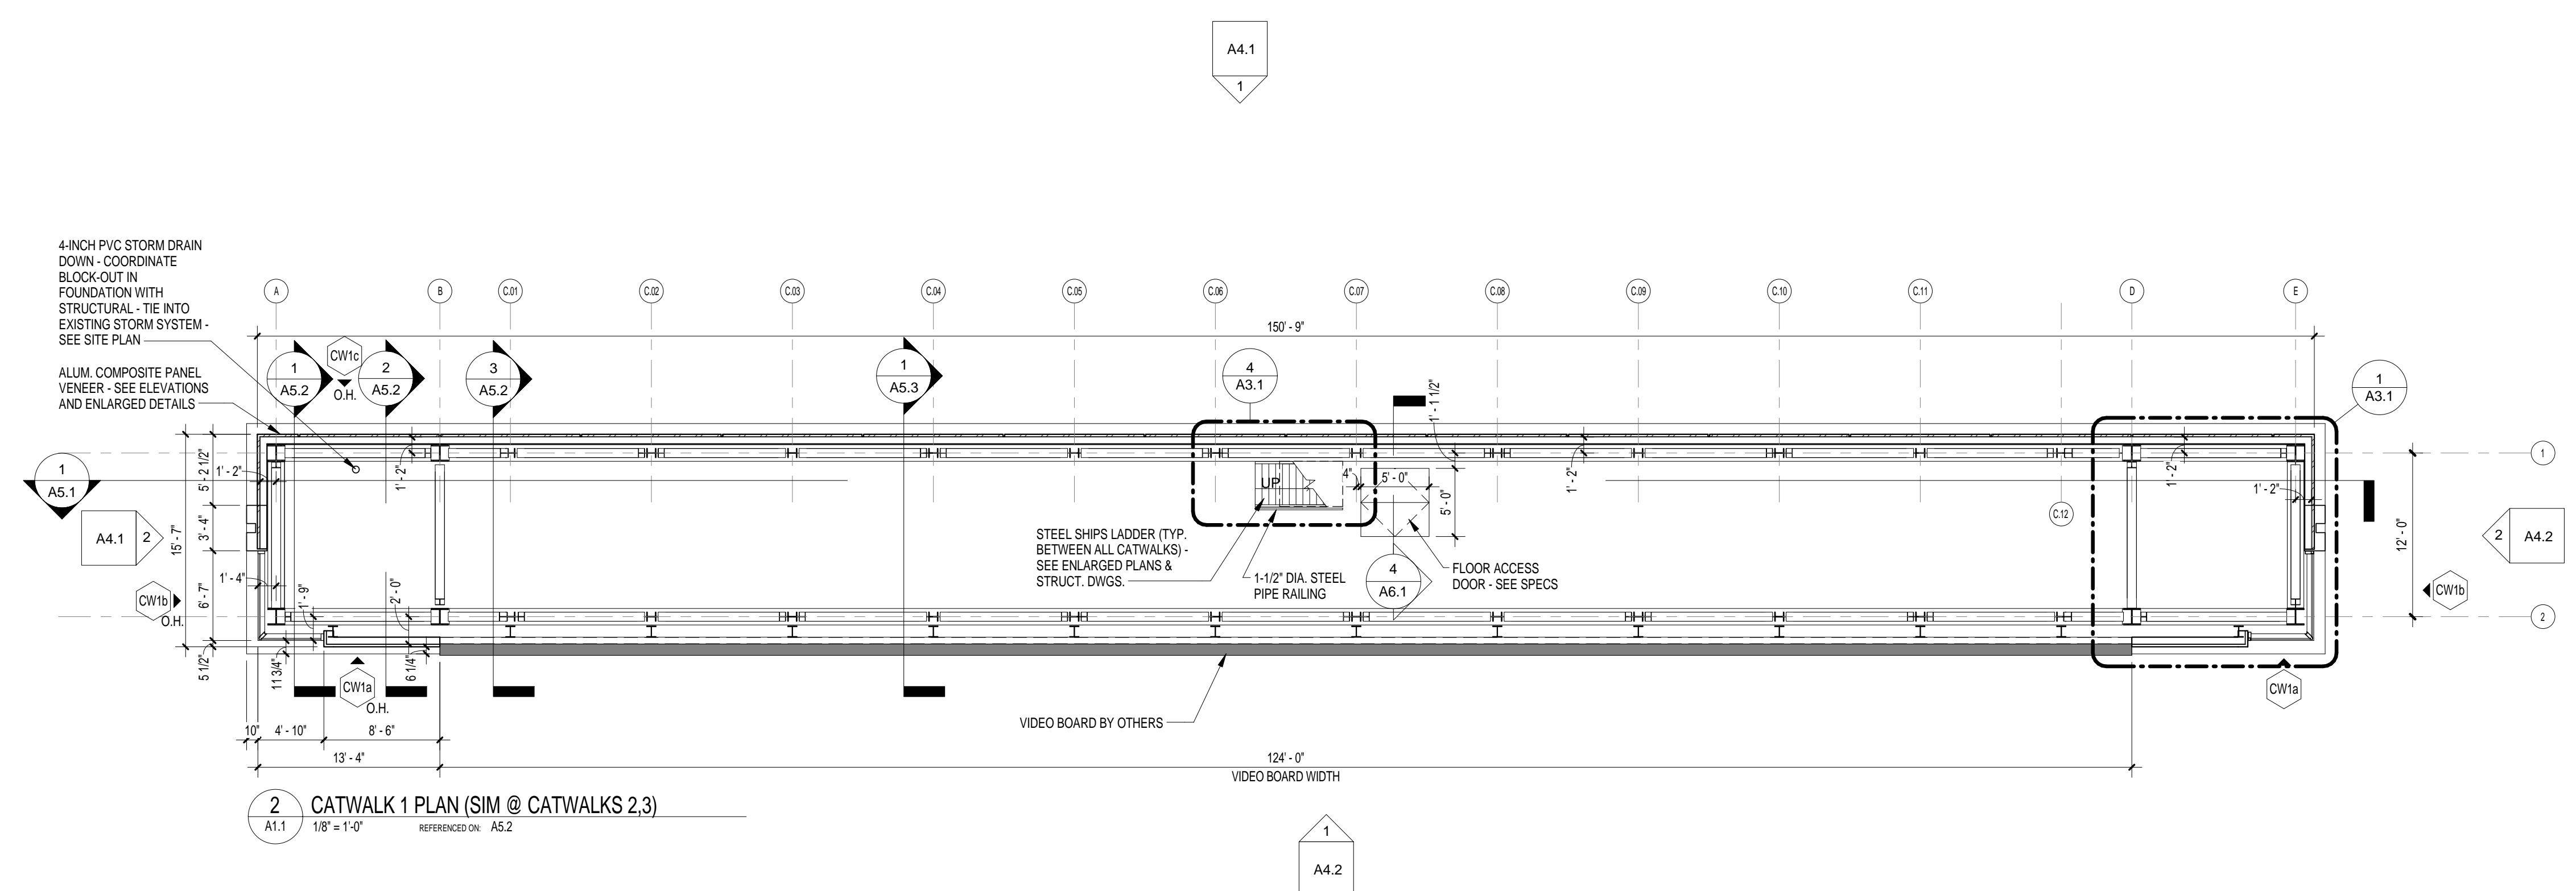

2 CATWALK 1 PLAN (SIM @ CATWALKS 2,3)
A1.1 1/8" = 1'-0" REFERENCED ON: A5.2

GARVINDESIGNGROUP
architecture interiors planning
803.212.1032 p / 803.212.1074 f
1209 Lincoln Street P. O. Box 18 Columbia, SC 29202

AE SEAL
AE SEAL

PROJECT TITLE
WILLIAMS-BRICE STADIUM
VIDEO BOARD SUPPORT
CONSTRUCTION
UNIVERSITY OF SOUTH CAROLINA
COLUMBIA, SC
STATE PROJECT NO. H27-6089-MJ

NO.	REVISIONS	NAME	DATE


DRAWN BY: Author
CHKD BY: Checker

DRAWING TITLE
GROUND LEVEL &
CATWALK PLANS


PROJECT NO. U291.11
DATE 12.20.11
DRAWING NO. A1.1

GENERAL NOTES - UNDERSIDE OF CATWLK


1. REFER TO ELECTRICAL DRAWINGS FOR QUANTITY AND SPECIFIC FIXTURE DESIGNATIONS.
2. GENERAL CONTRACTOR TO COORDINATE LOCATIONS OF ALL CEILING MOUNTED EQUIPMENT, DEVICES, FIXTURES & GRILLES INDICATED ON REFLECTED CEILING PLANS.

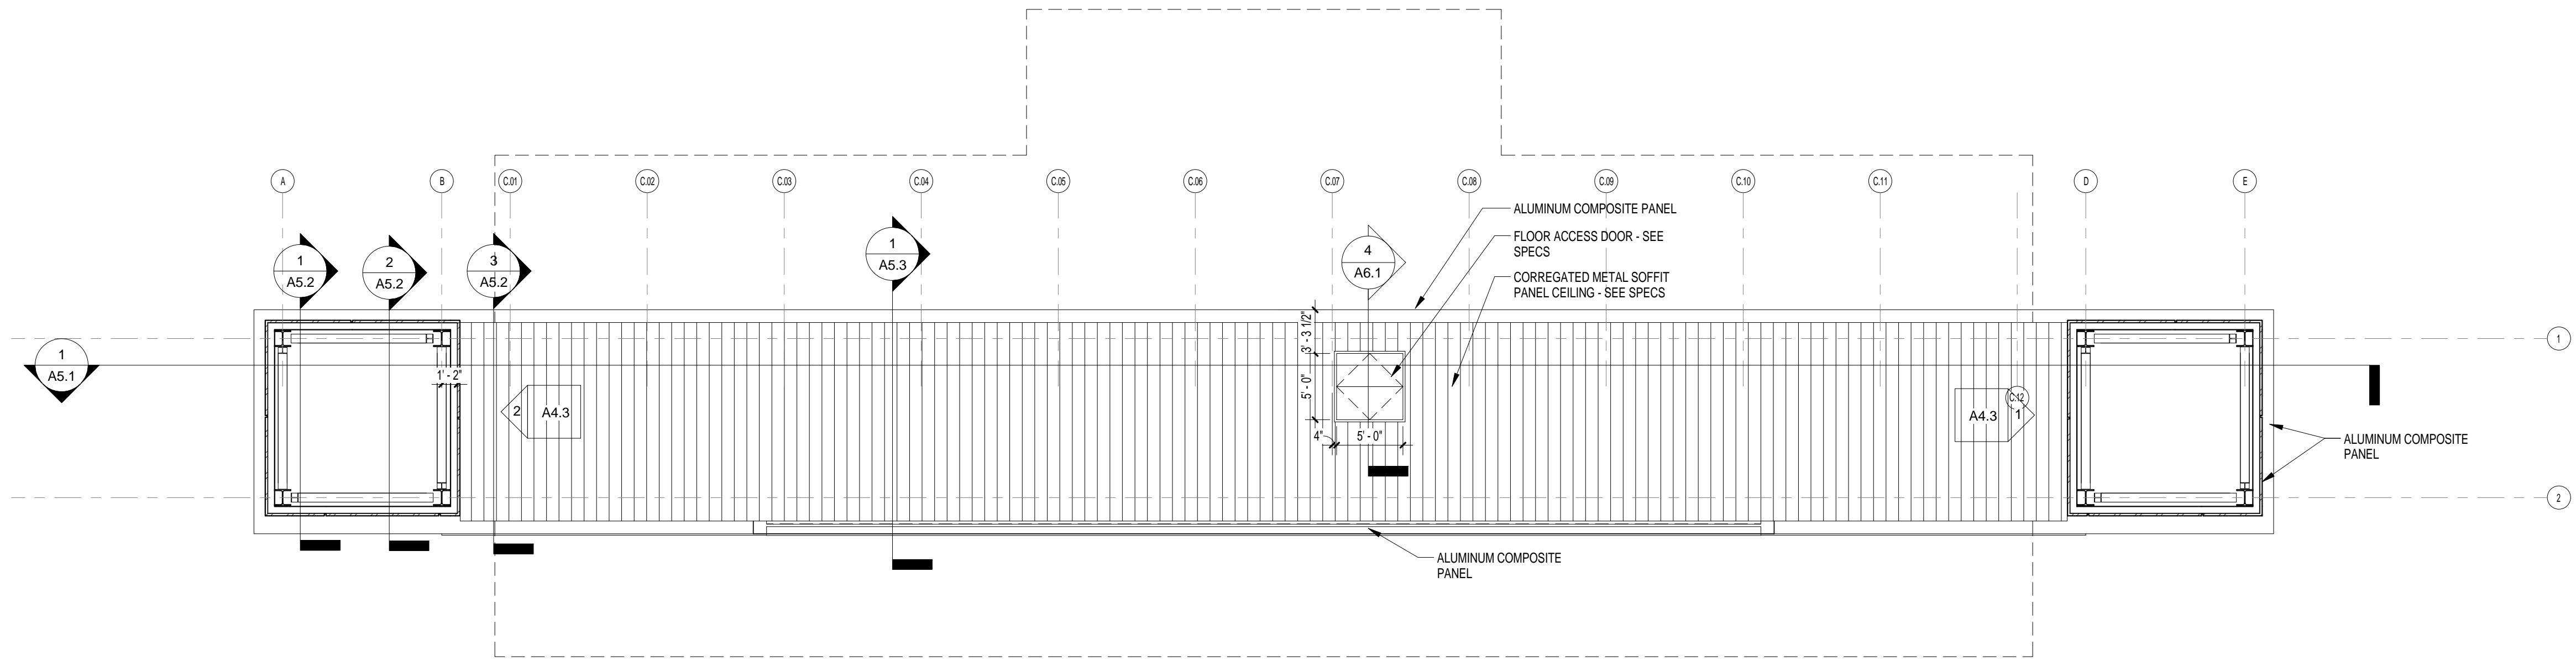

1 PLAN @ UNDERSIDE OF CATWALK 1
A2.1 1/8" = 1'-0" REFERENCED ON:

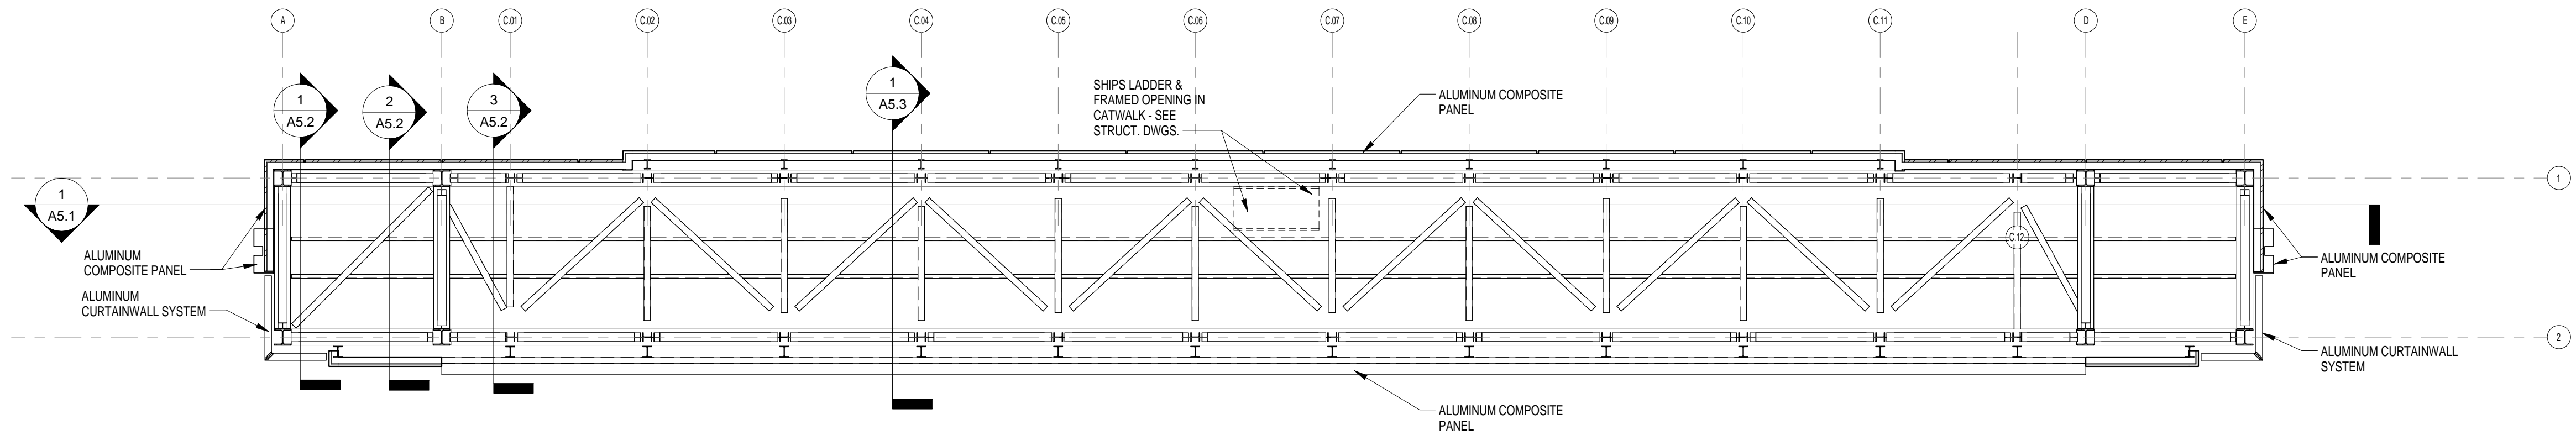


2 PLAN @ UNDERSIDE OF TYP. CATWALK
A2.1 1/8" = 1'-0" REFERENCED ON: A5.2

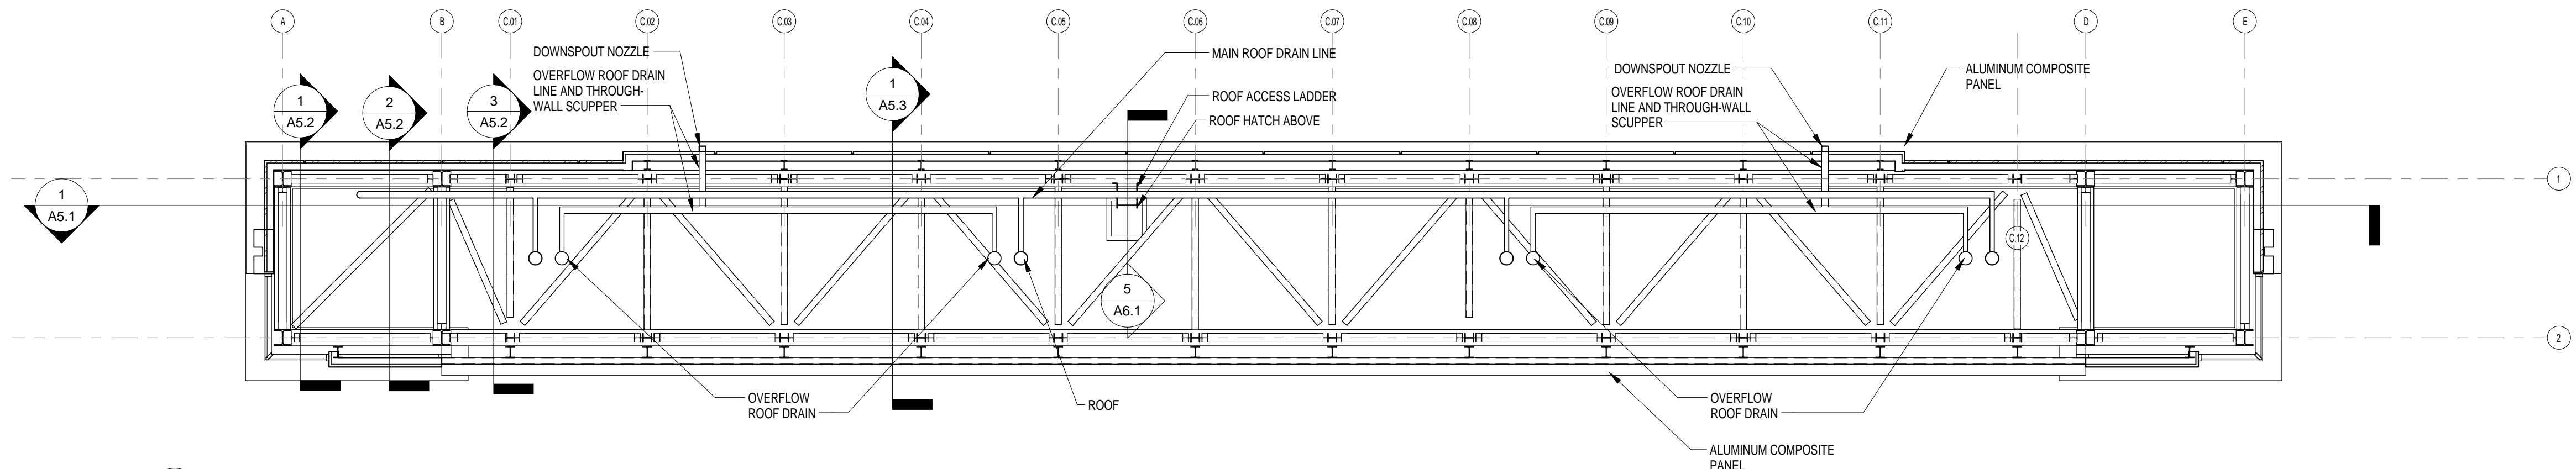


3 PLAN @ UNDERSIDE OF ROOF
A2.1 1/8" = 1'-0" REFERENCED ON:

NO.	REVISIONS	NAME	DATE


DRAWN BY: Author
CHKD BY: Checker
THIS DRAWING AND THE DESIGN HEREON ARE THE PROPERTY OF GARVIN DESIGN GROUP, INC. THE CONSULTANT SHALL BE RESPONSIBLE FOR THE ACCURACY OF THIS DRAWING AND SHALL NOT BE RESPONSIBLE FOR ANY ERRORS OR OMISSIONS. SUBJECT TO REGULATION BY THE STATE OF SOUTH CAROLINA.

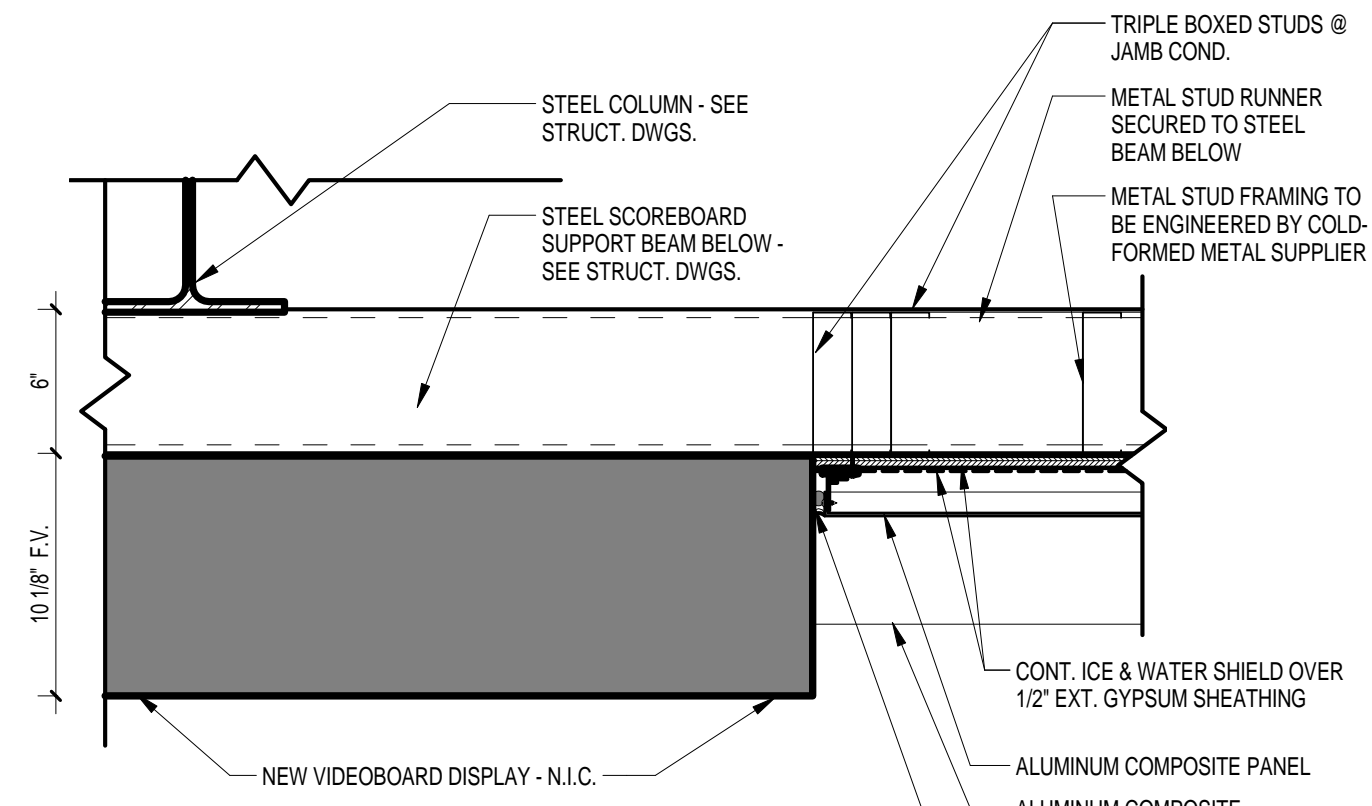


3 PLAN DETAIL
A3.1 1/2" = 1'-0" REFERENCED ON: A3.1

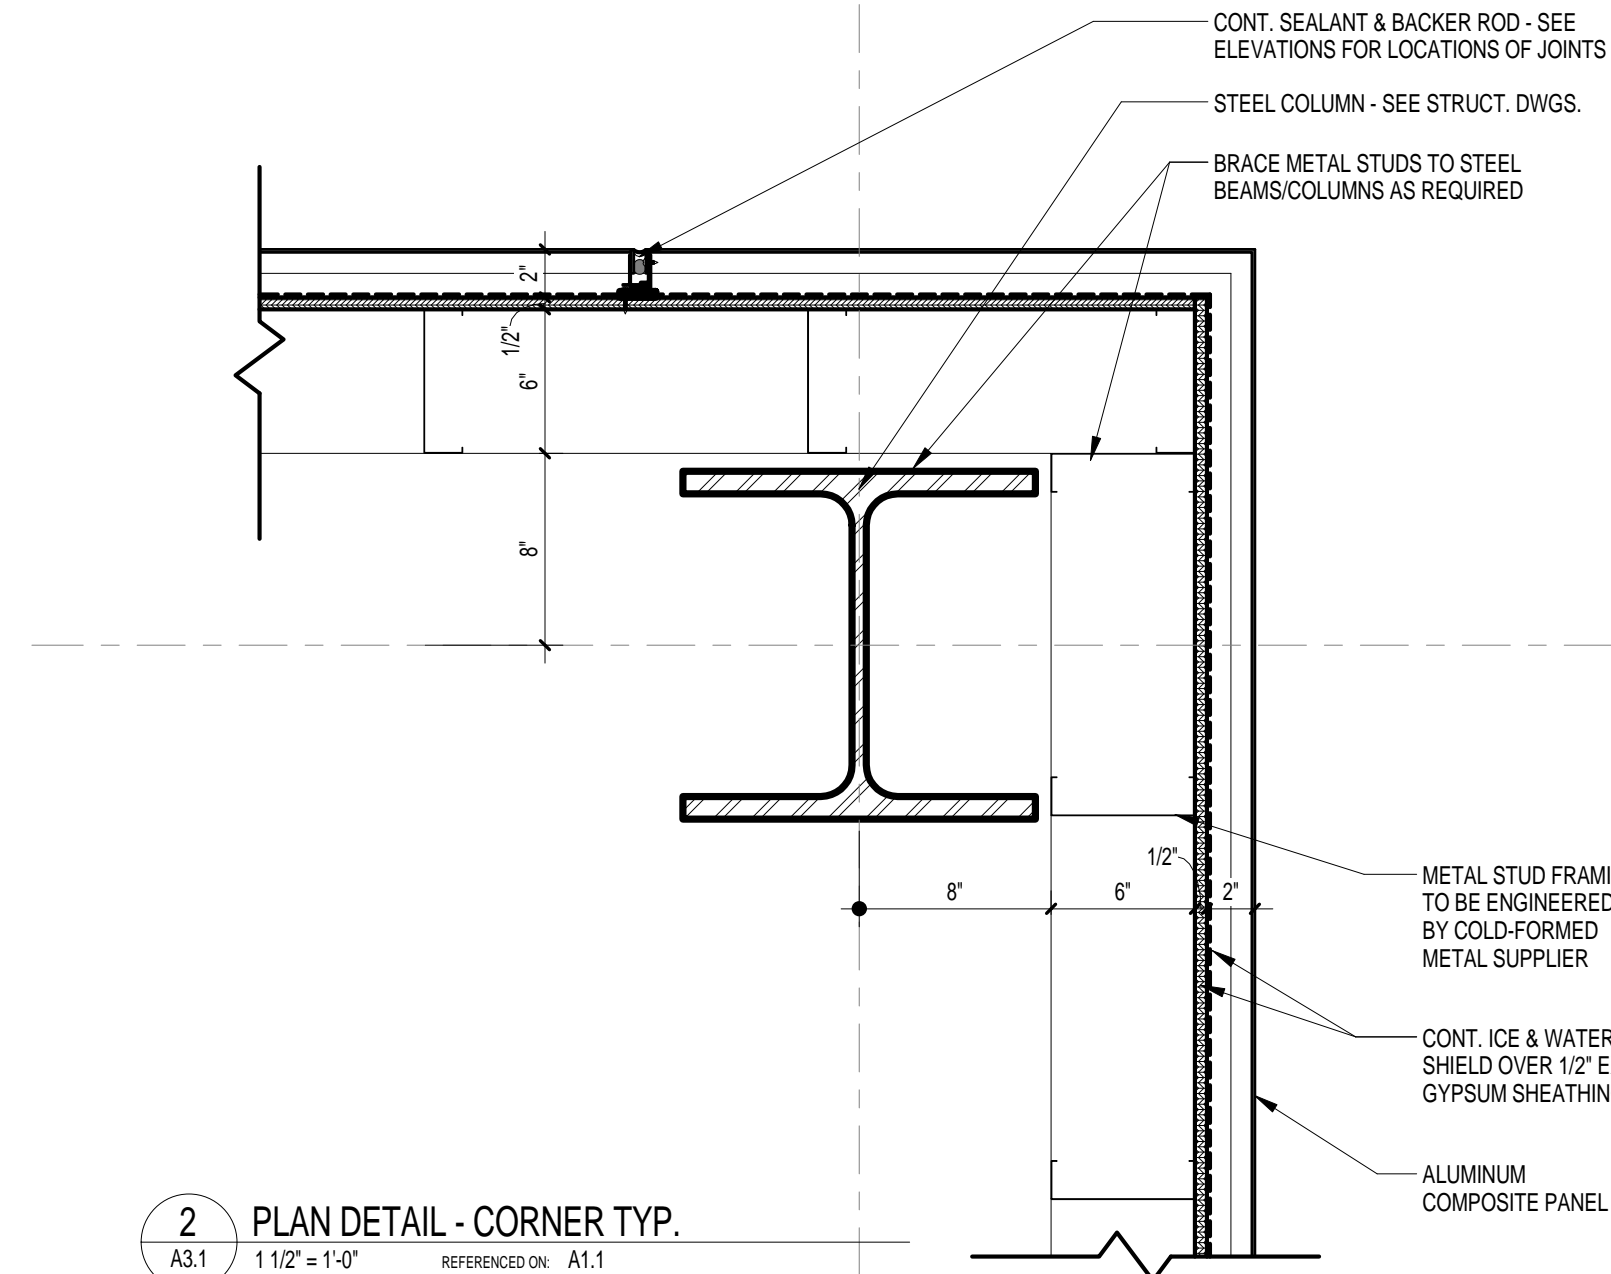

2 PLAN DETAIL - CORNER TYP.
A3.1 1/2" = 1'-0" REFERENCED ON: A1.1

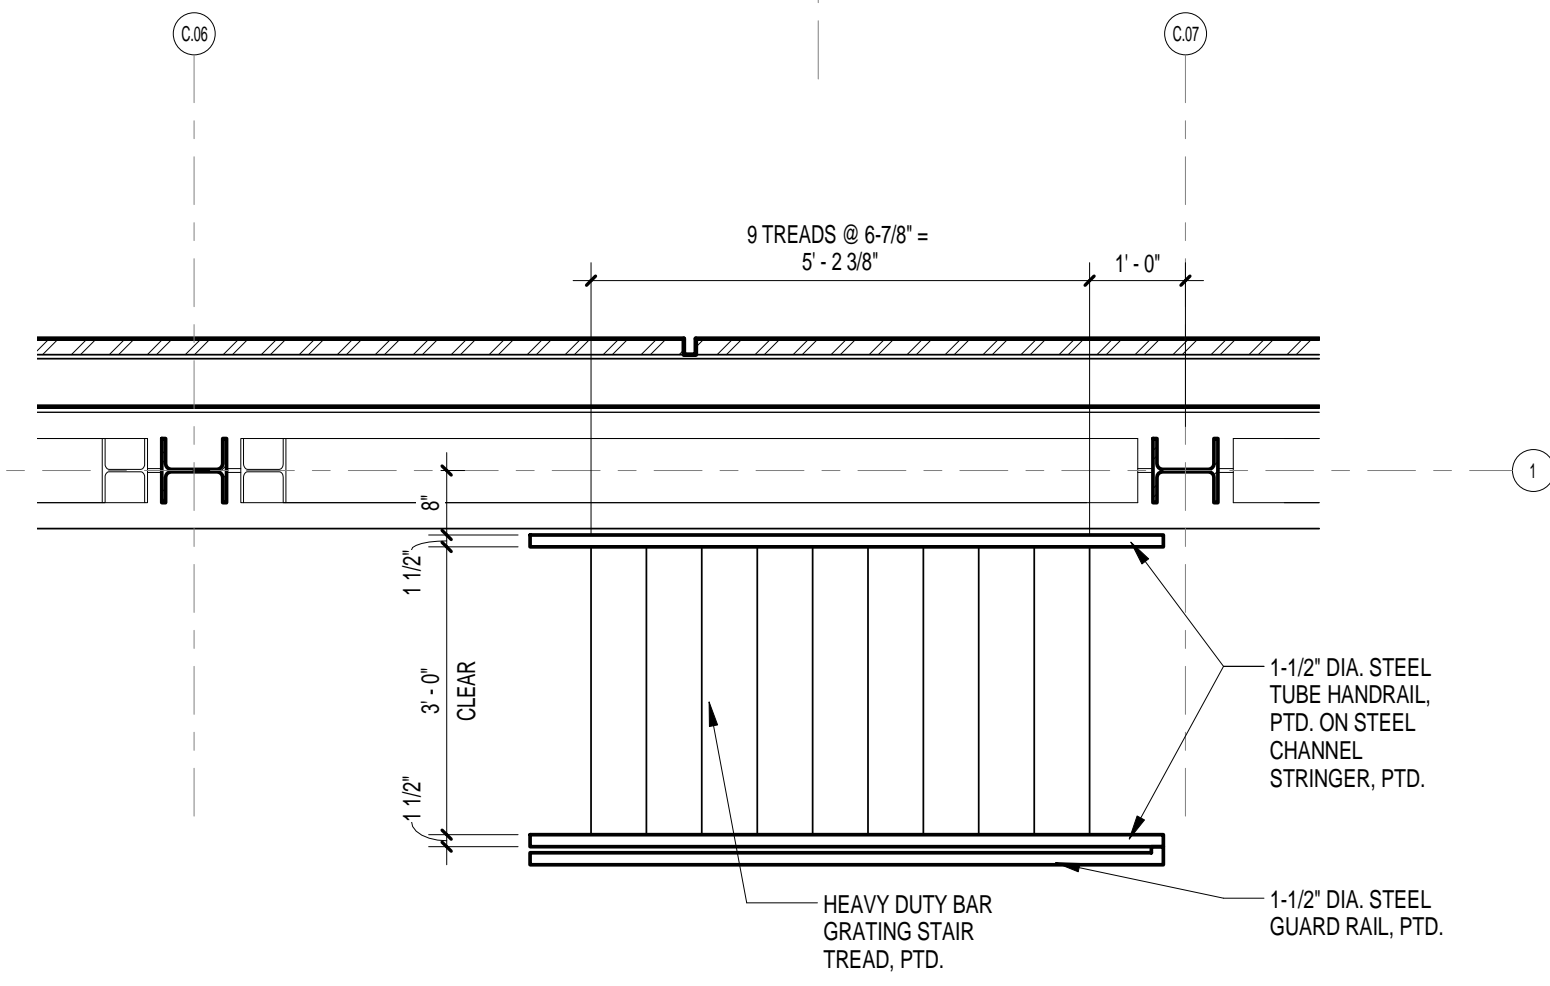


4 ENLARGED PLAN @ SHIPS LADDER
A3.1 1/2" = 1'-0" REFERENCED ON: A1.1

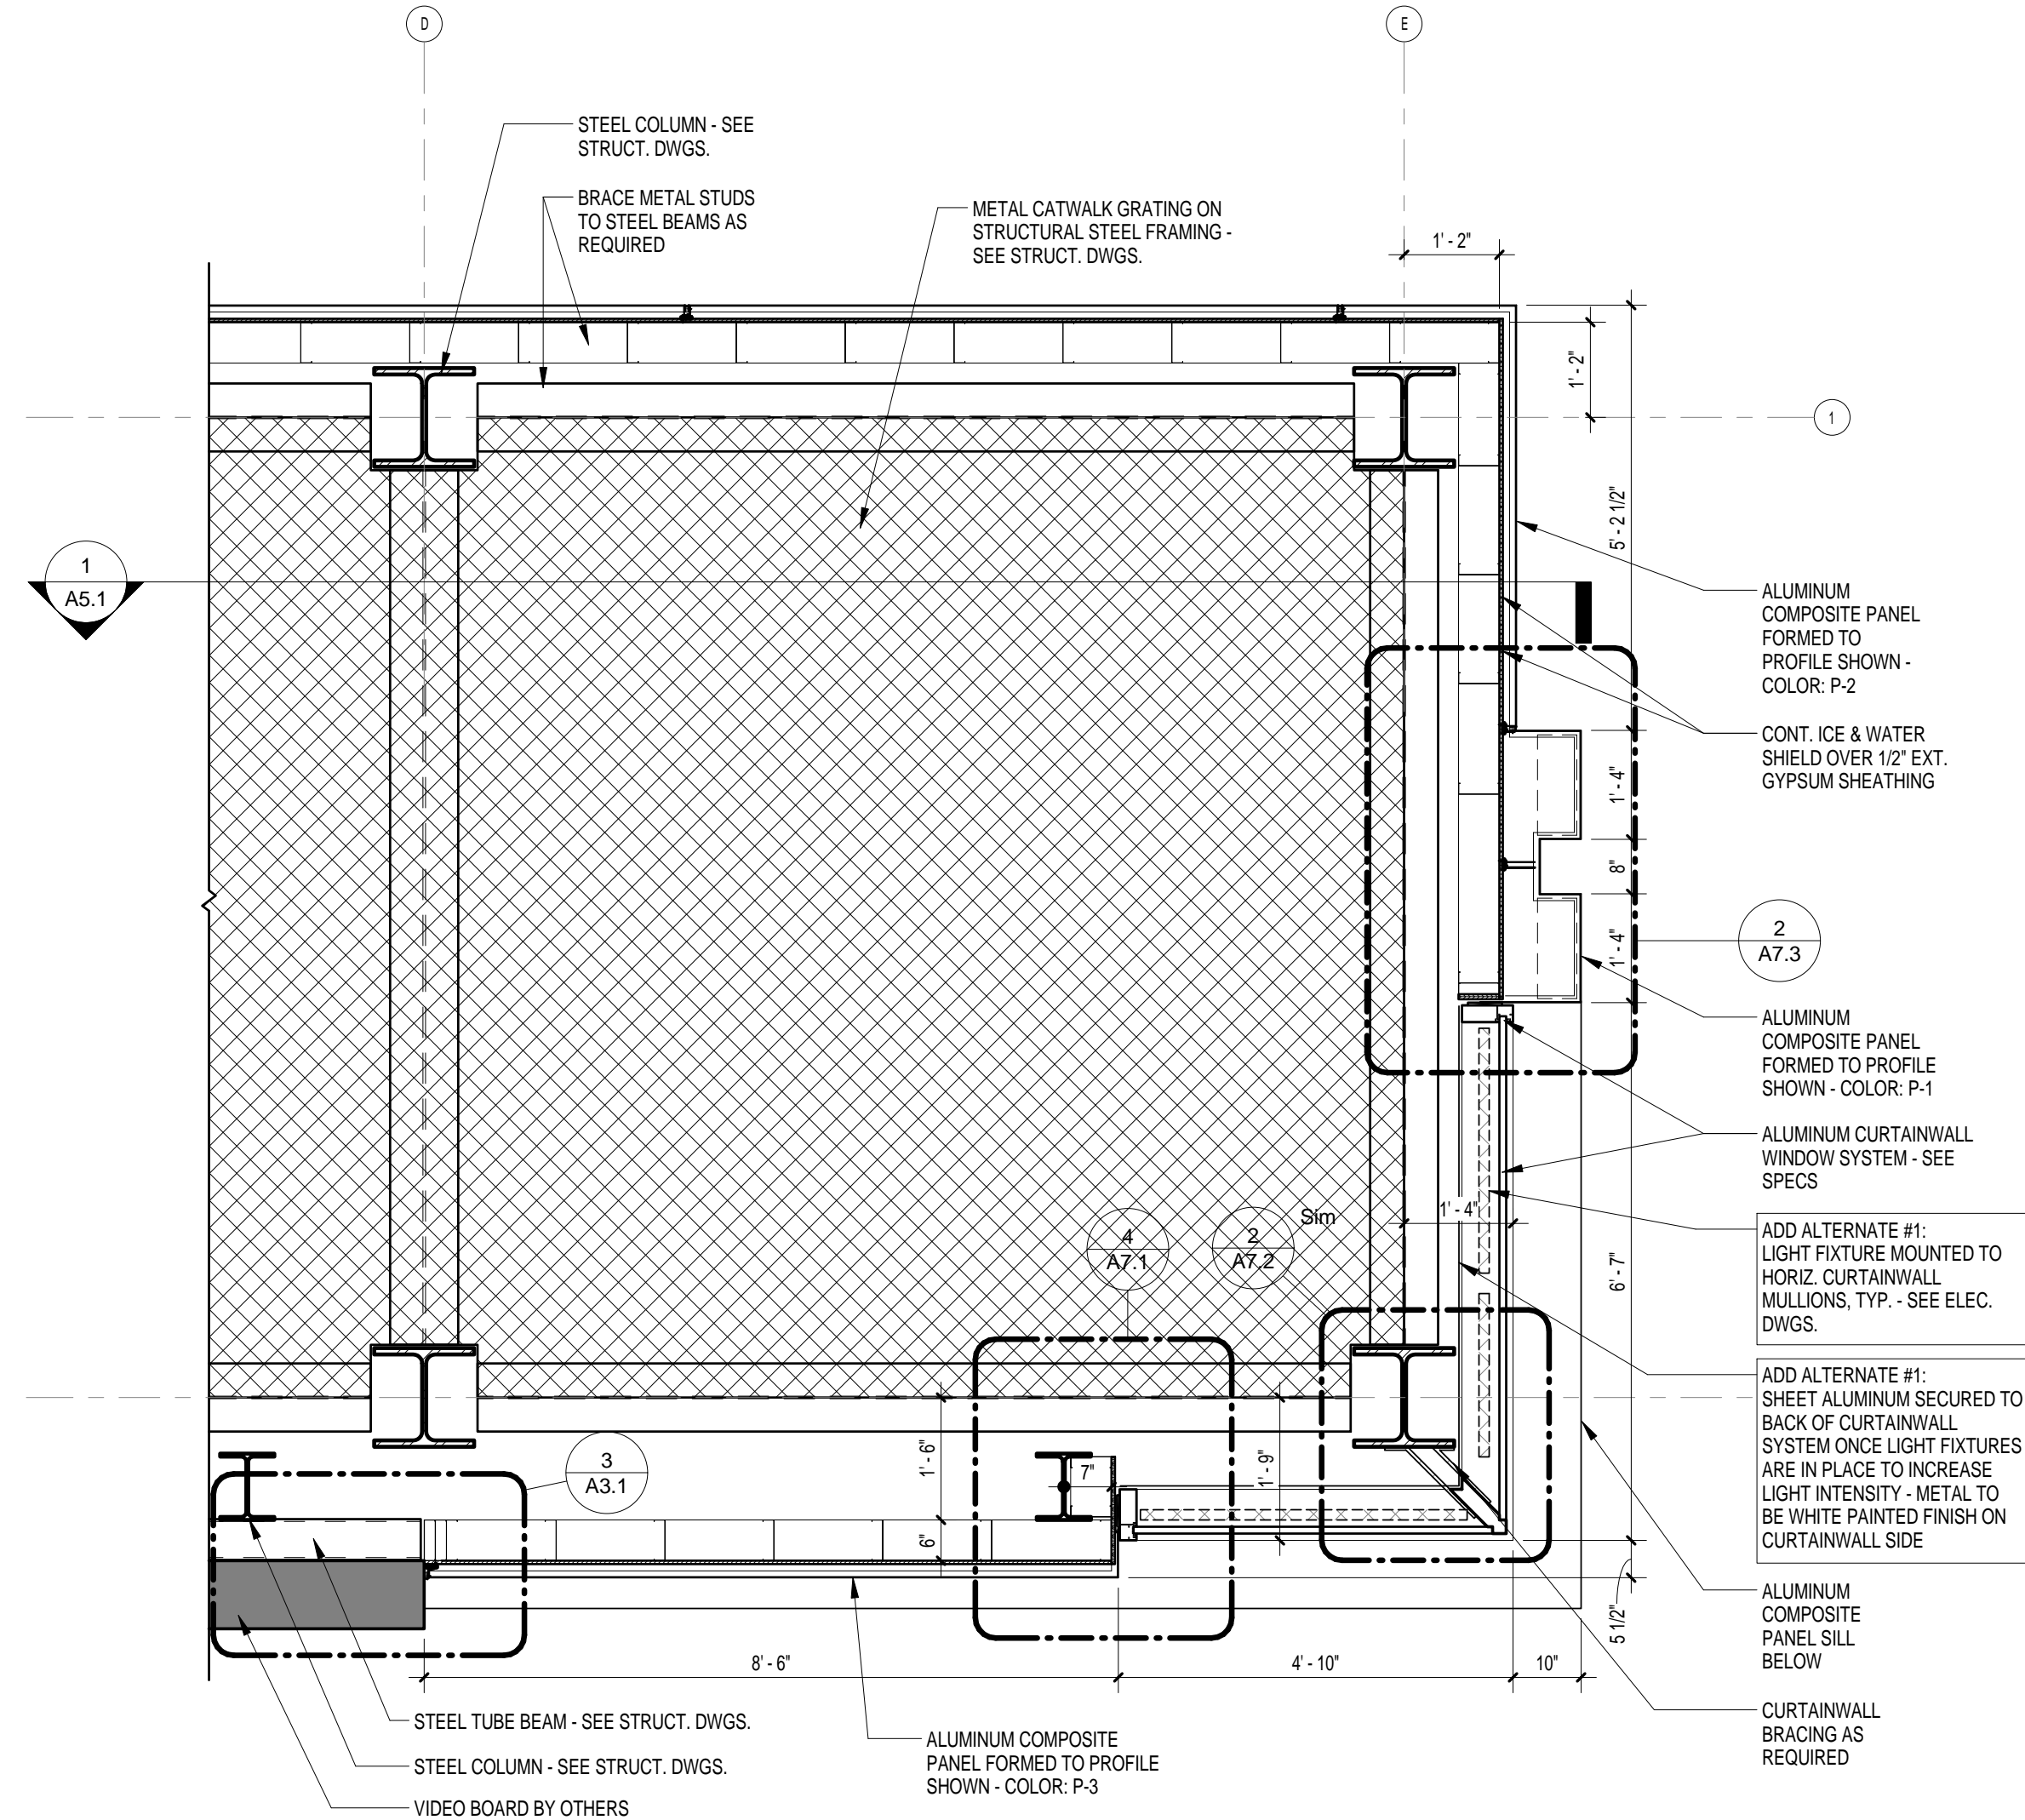

1 ENLARGED PLAN
A3.1 1/2" = 1'-0" REFERENCED ON: A1.1


NO.	REVISIONS	NAME	DATE

DRW BY: Author
CHKD BY: Checker
THIS DRAWING AND THE DESIGN HEREON ARE THE PROPERTY OF GARVIN DESIGN GROUP, INC. THE USER OF THIS DRAWING AGREES TO HOLD GARVIN DESIGN GROUP, INC. HARMLESS AND TO INDEMNIFY AND DEFEND GARVIN DESIGN GROUP, INC. FROM AND AGAINST ALL CLAIMS, DAMAGES, LOSSES AND EXPENSES, INCLUDING REASONABLE ATTORNEY'S FEES, THAT MAY BE ASSERTED AGAINST OR INCURRED BY GARVIN DESIGN GROUP, INC. IN CONNECTION WITH THIS DRAWING.

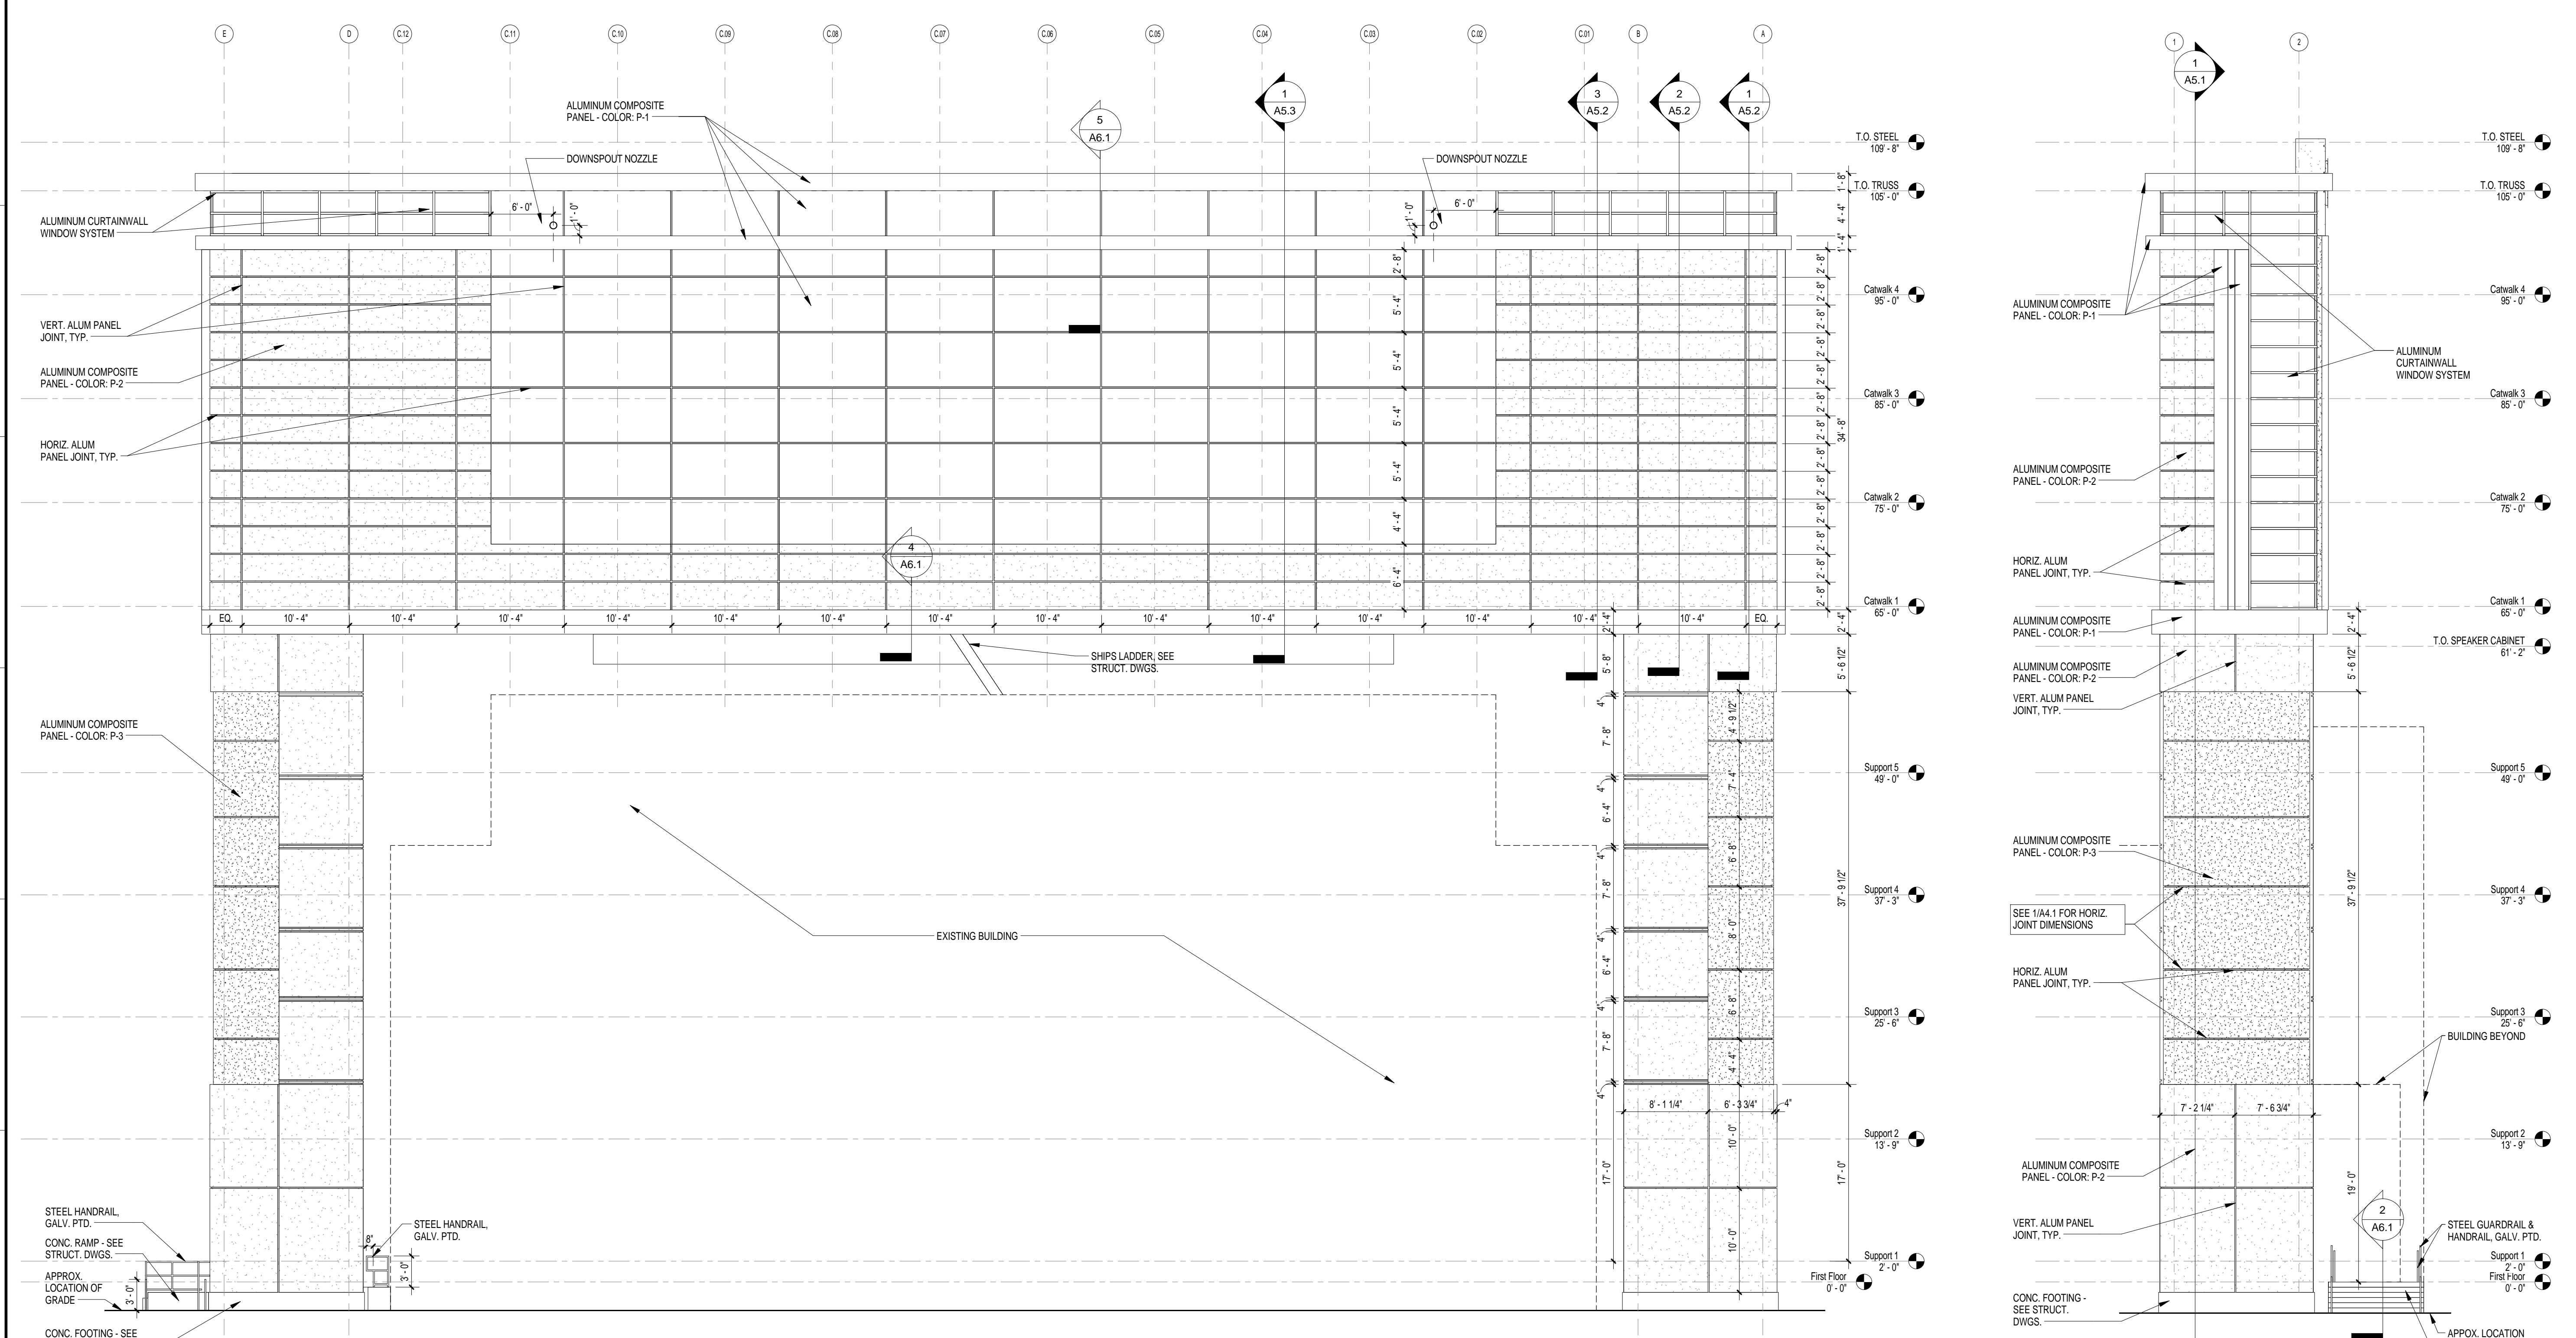

1 NORTH ELEVATION
 A4.1 1/8" = 1'-0" REFERENCED ON: A1.1

2 WEST ELEVATION
 A4.1 1/8" = 1'-0" REFERENCED ON: A1.1

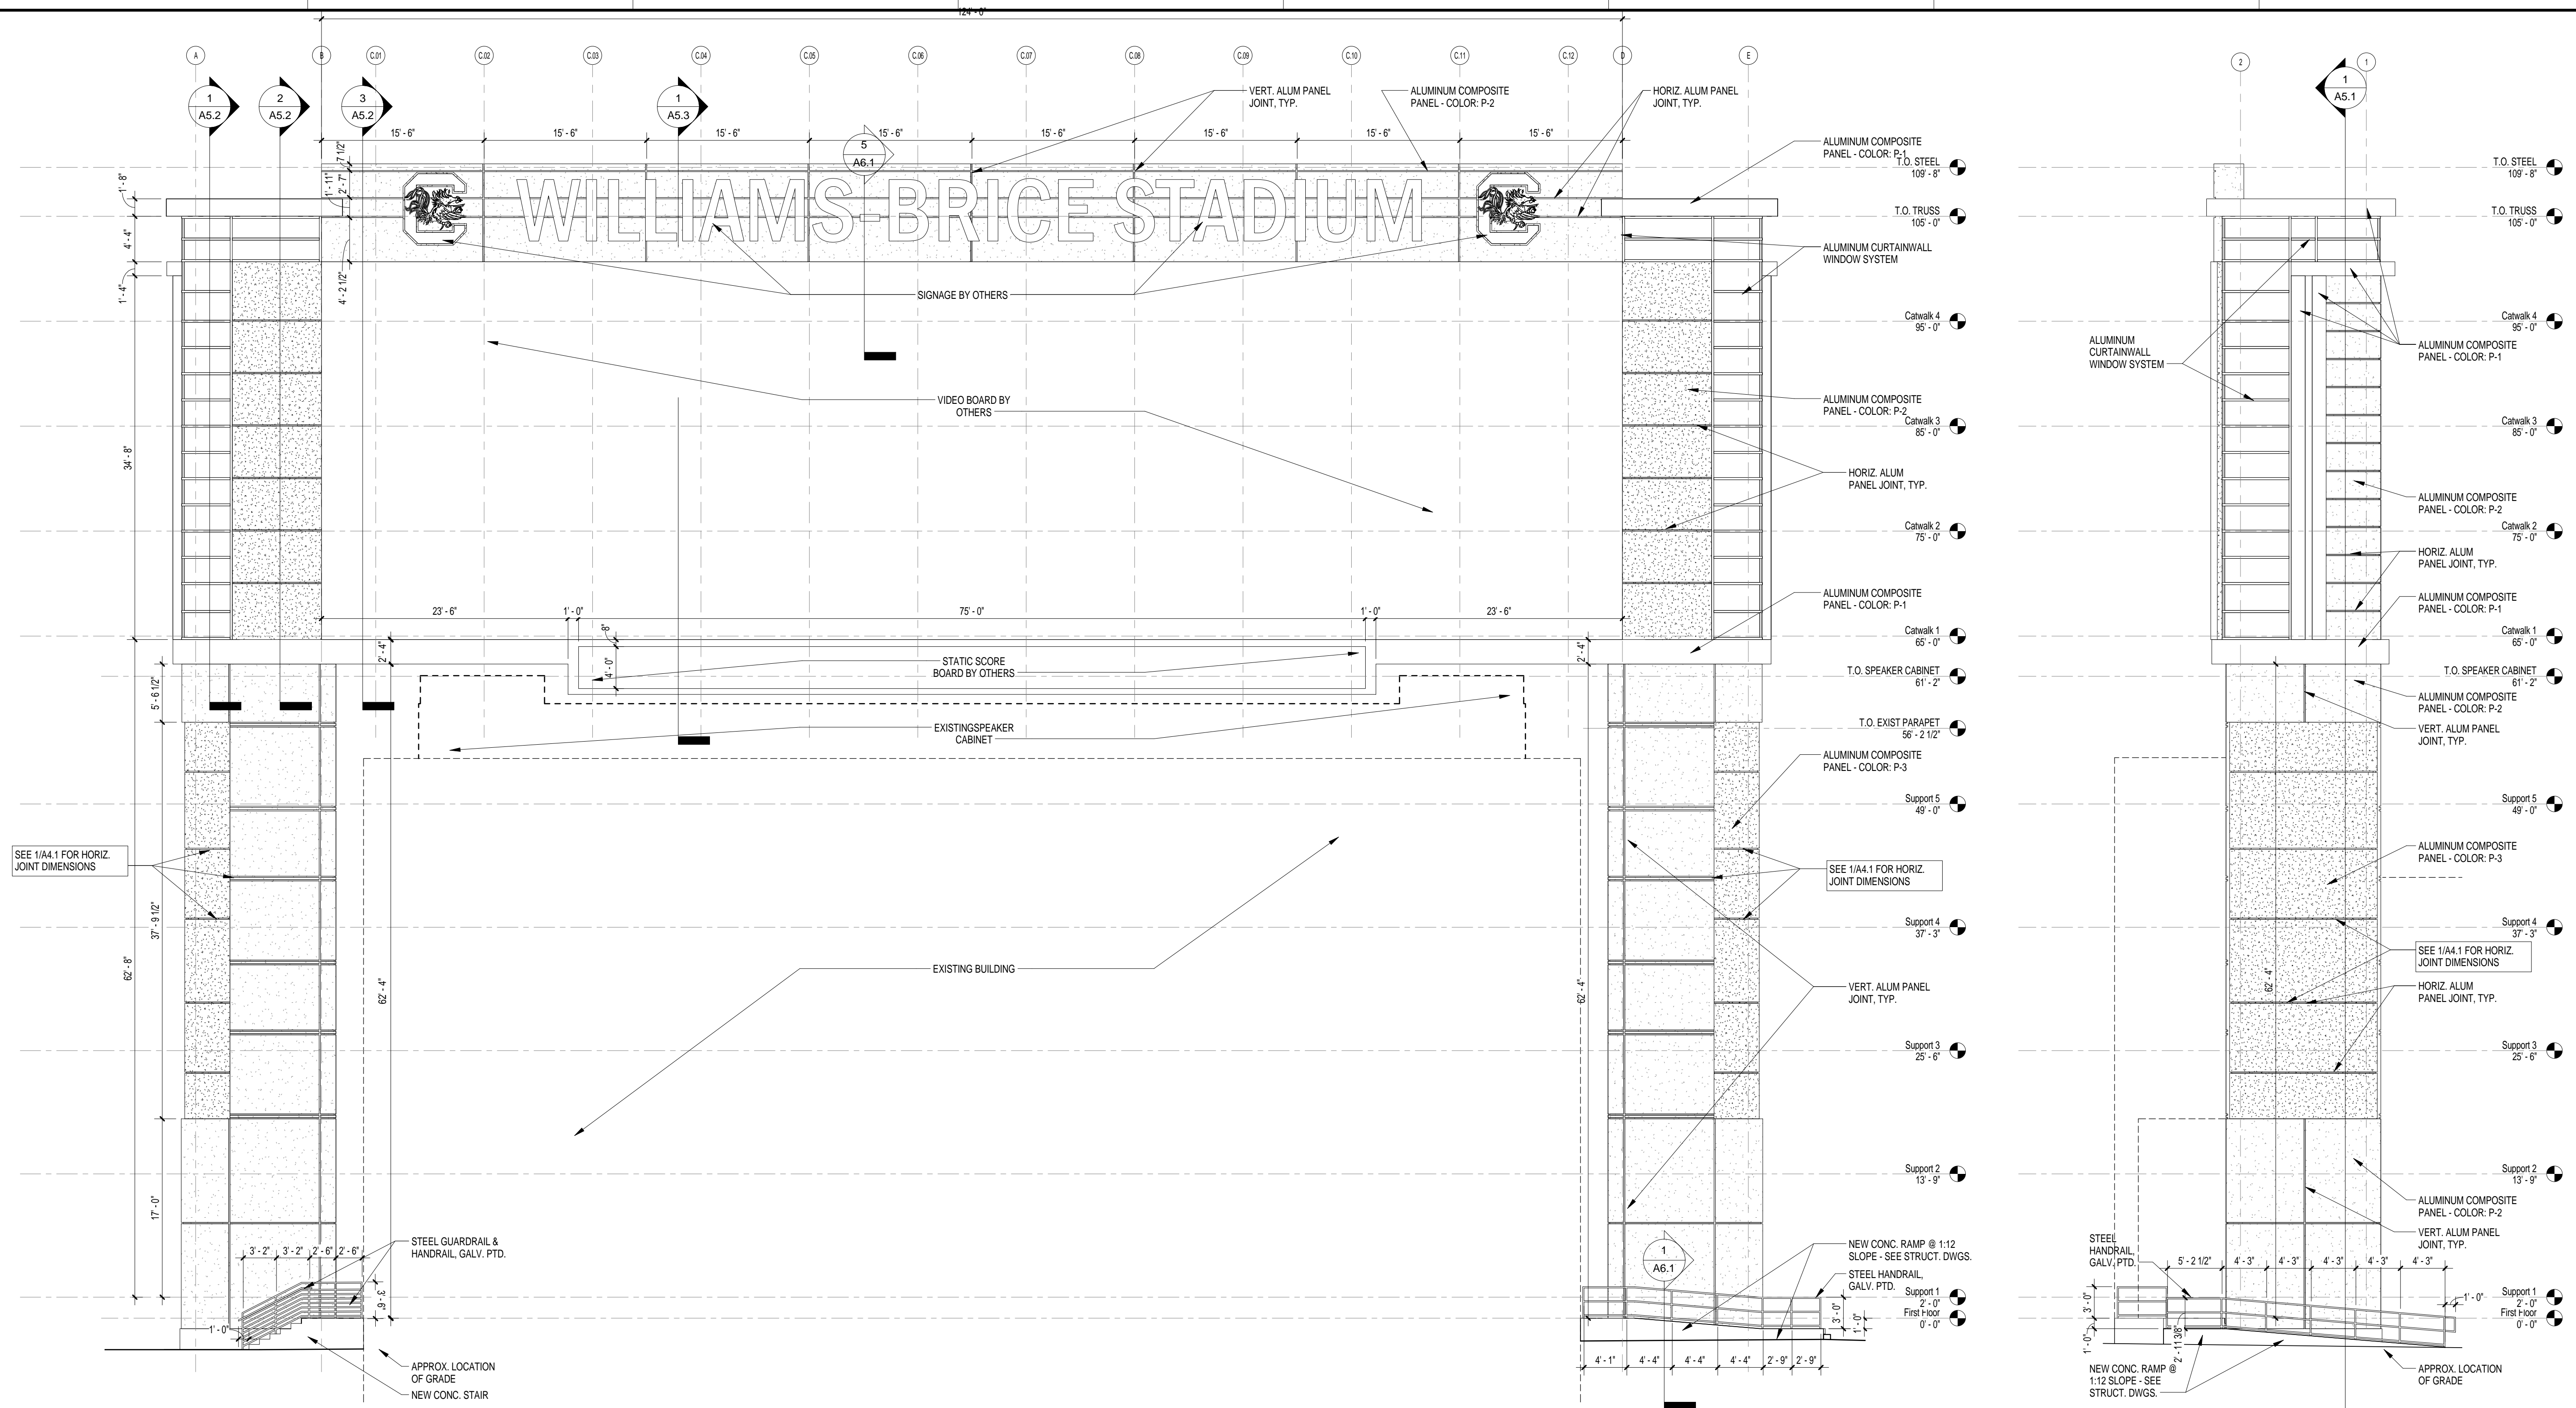

1 SOUTH ELEVATION
 A4.2 1/8" = 1'-0" REFERENCED ON: A1.1

2 EAST ELEVATION
 A4.2 1/8" = 1'-0" REFERENCED ON: A1.1

PROJECT TITLE
WILLIAMS-BRICE STADIUM VIDEO BOARD SUPPORT CONSTRUCTION
 UNIVERSITY OF SOUTH CAROLINA
 COLUMBIA, SC
 STATE PROJECT NO. H27-6089-MJ


PROJECT NO. _____ DATE _____
 REVISIONS NAME _____ DATE _____
 NO. _____

DRW BY: Author
 CHKD BY: Checker


DRAWING TITLE
ELEVATIONS

PROJECT NO. U291.11
 DATE 12-30-11
 DRAWING NO. **A4.2**


THIS DRAWING AND THE DESIGN HEREON ARE THE PROPERTY OF GARVIN DESIGN GROUP, INC. THE DESIGN HEREON IS THE PROPERTY OF GARVIN DESIGN GROUP, INC. AND IS NOT TO BE REPRODUCED OR TRANSMITTED IN ANY FORM OR BY ANY MEANS, ELECTRONIC OR MECHANICAL, INCLUDING PHOTOCOPYING, RECORDING, OR BY ANY INFORMATION STORAGE AND RETRIEVAL SYSTEM, WITHOUT THE WRITTEN PERMISSION OF GARVIN DESIGN GROUP, INC.

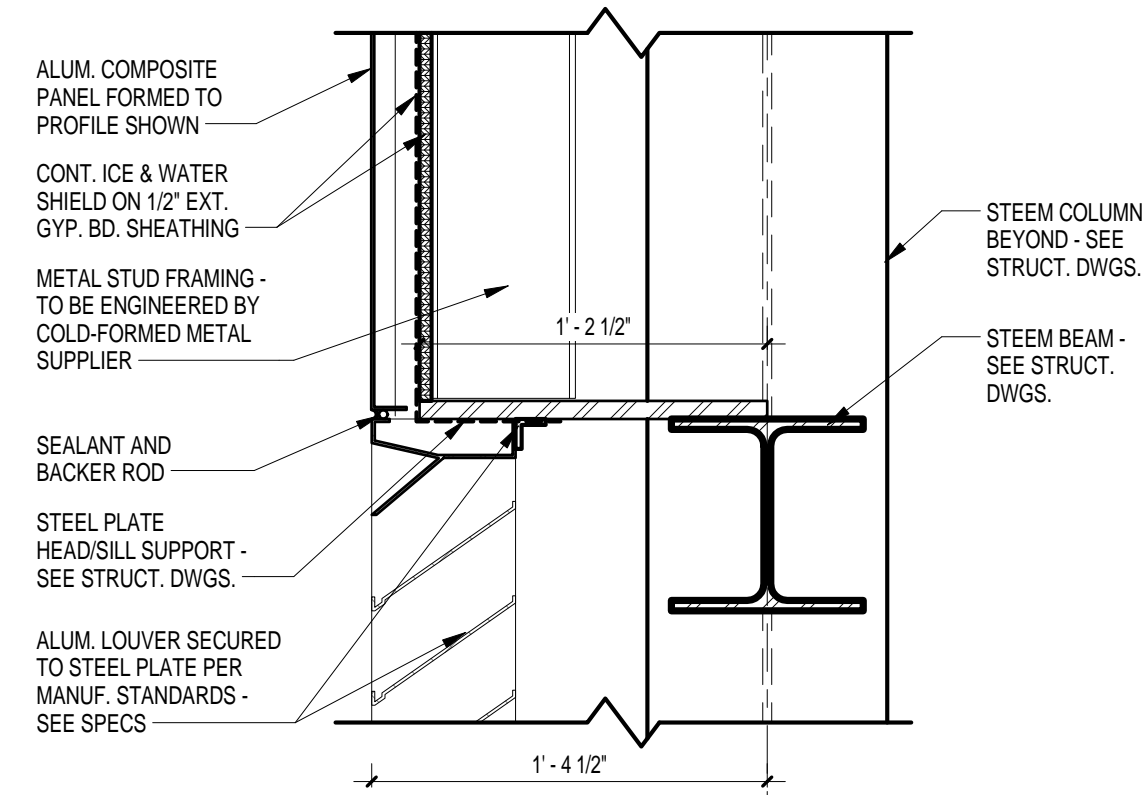


4 LOUVER HEAD SECTION DETAIL
A4.3 1 1/2" = 1'-0" REFERENCED ON: A4.3

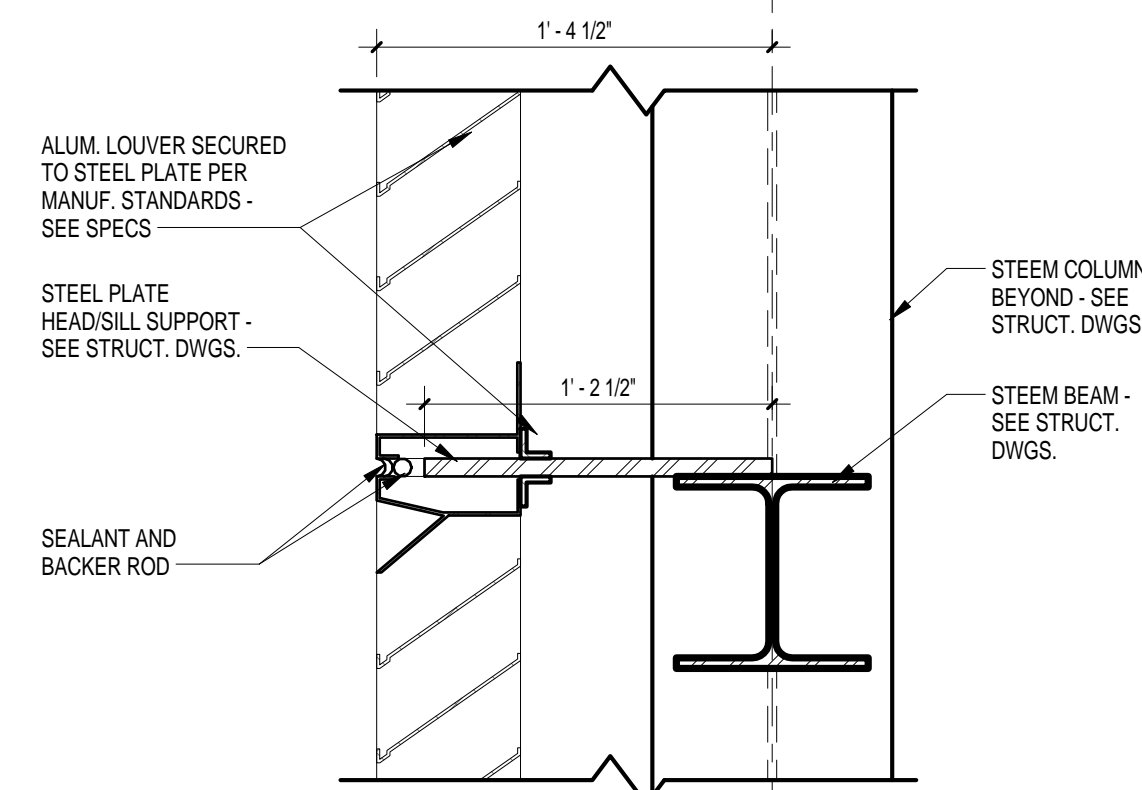


5 LOUVER HEAD/SILL SECTION DETAIL
A4.3 1 1/2" = 1'-0" REFERENCED ON: A4.3

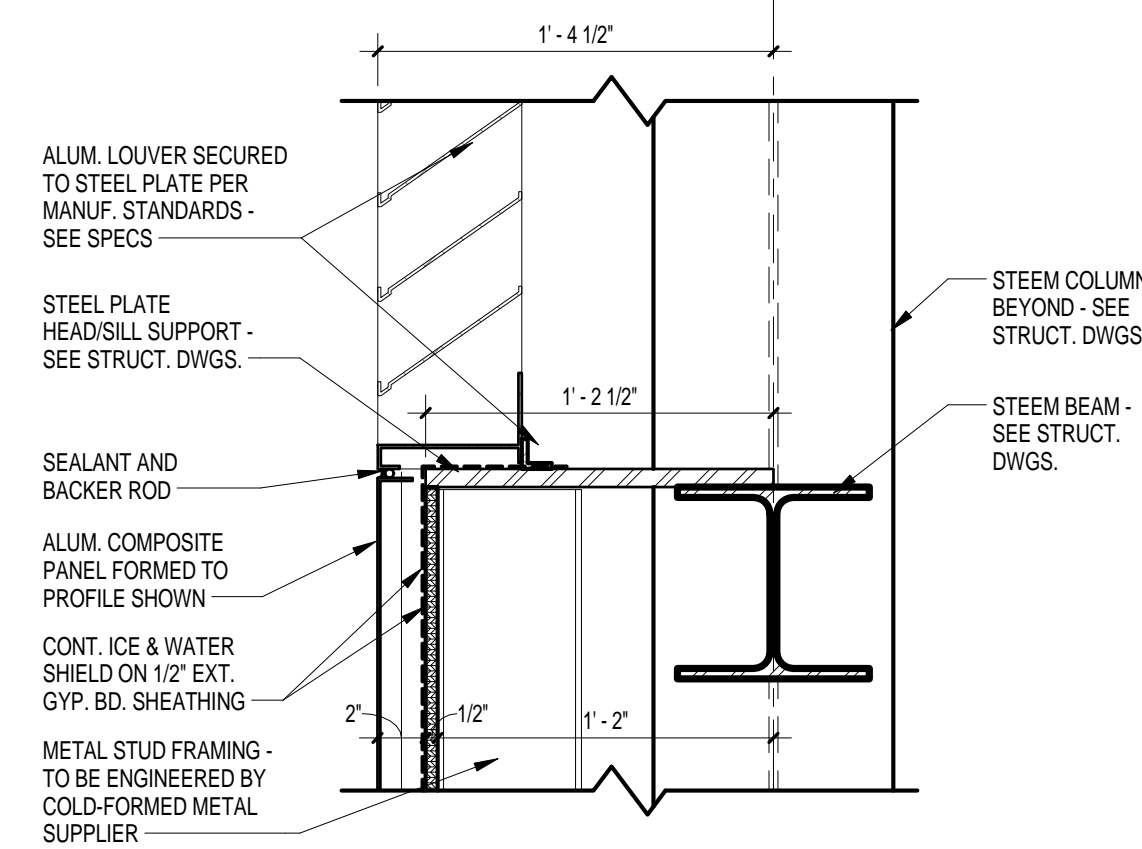


6 LOUVER SILL SECTION DETAIL
A4.3 1 1/2" = 1'-0" REFERENCED ON: A4.3

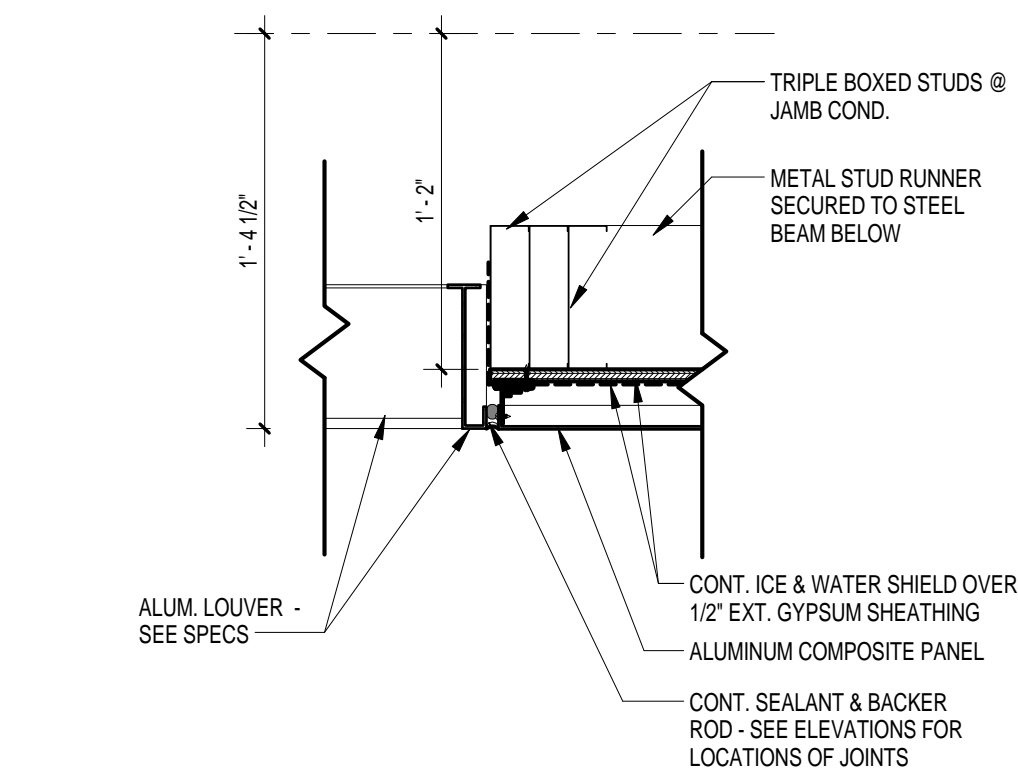


7 LOUVER JAMB PLAN DETAIL
A4.3 1 1/2" = 1'-0" REFERENCED ON: A4.3

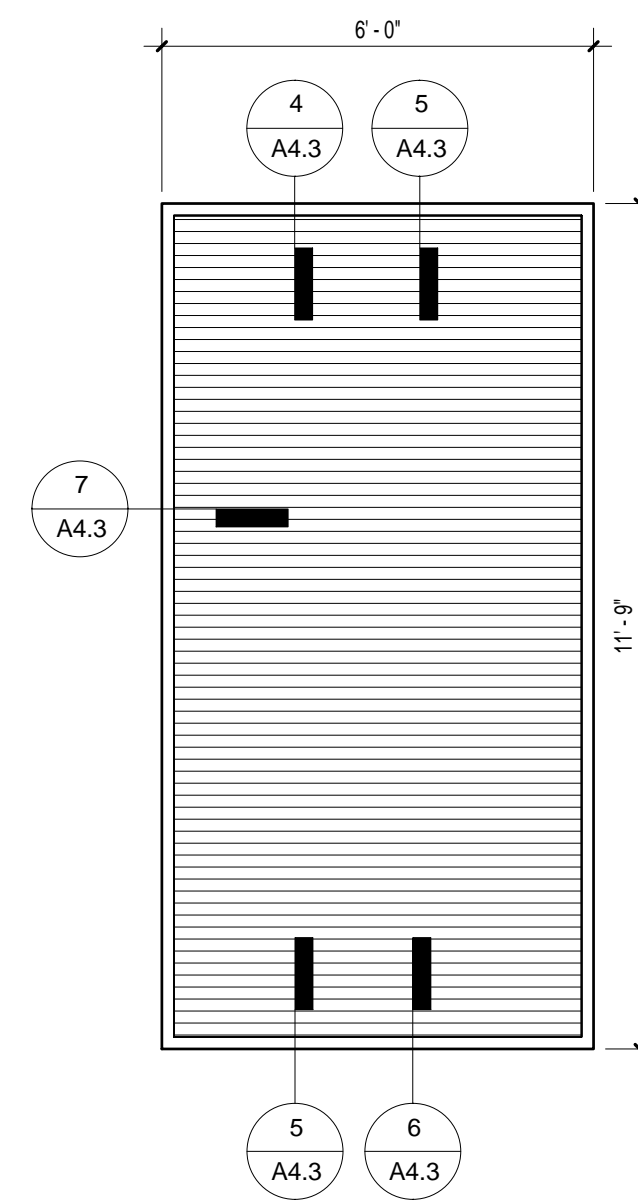

LOUVER L1
EXTERIOR ALUMINUM

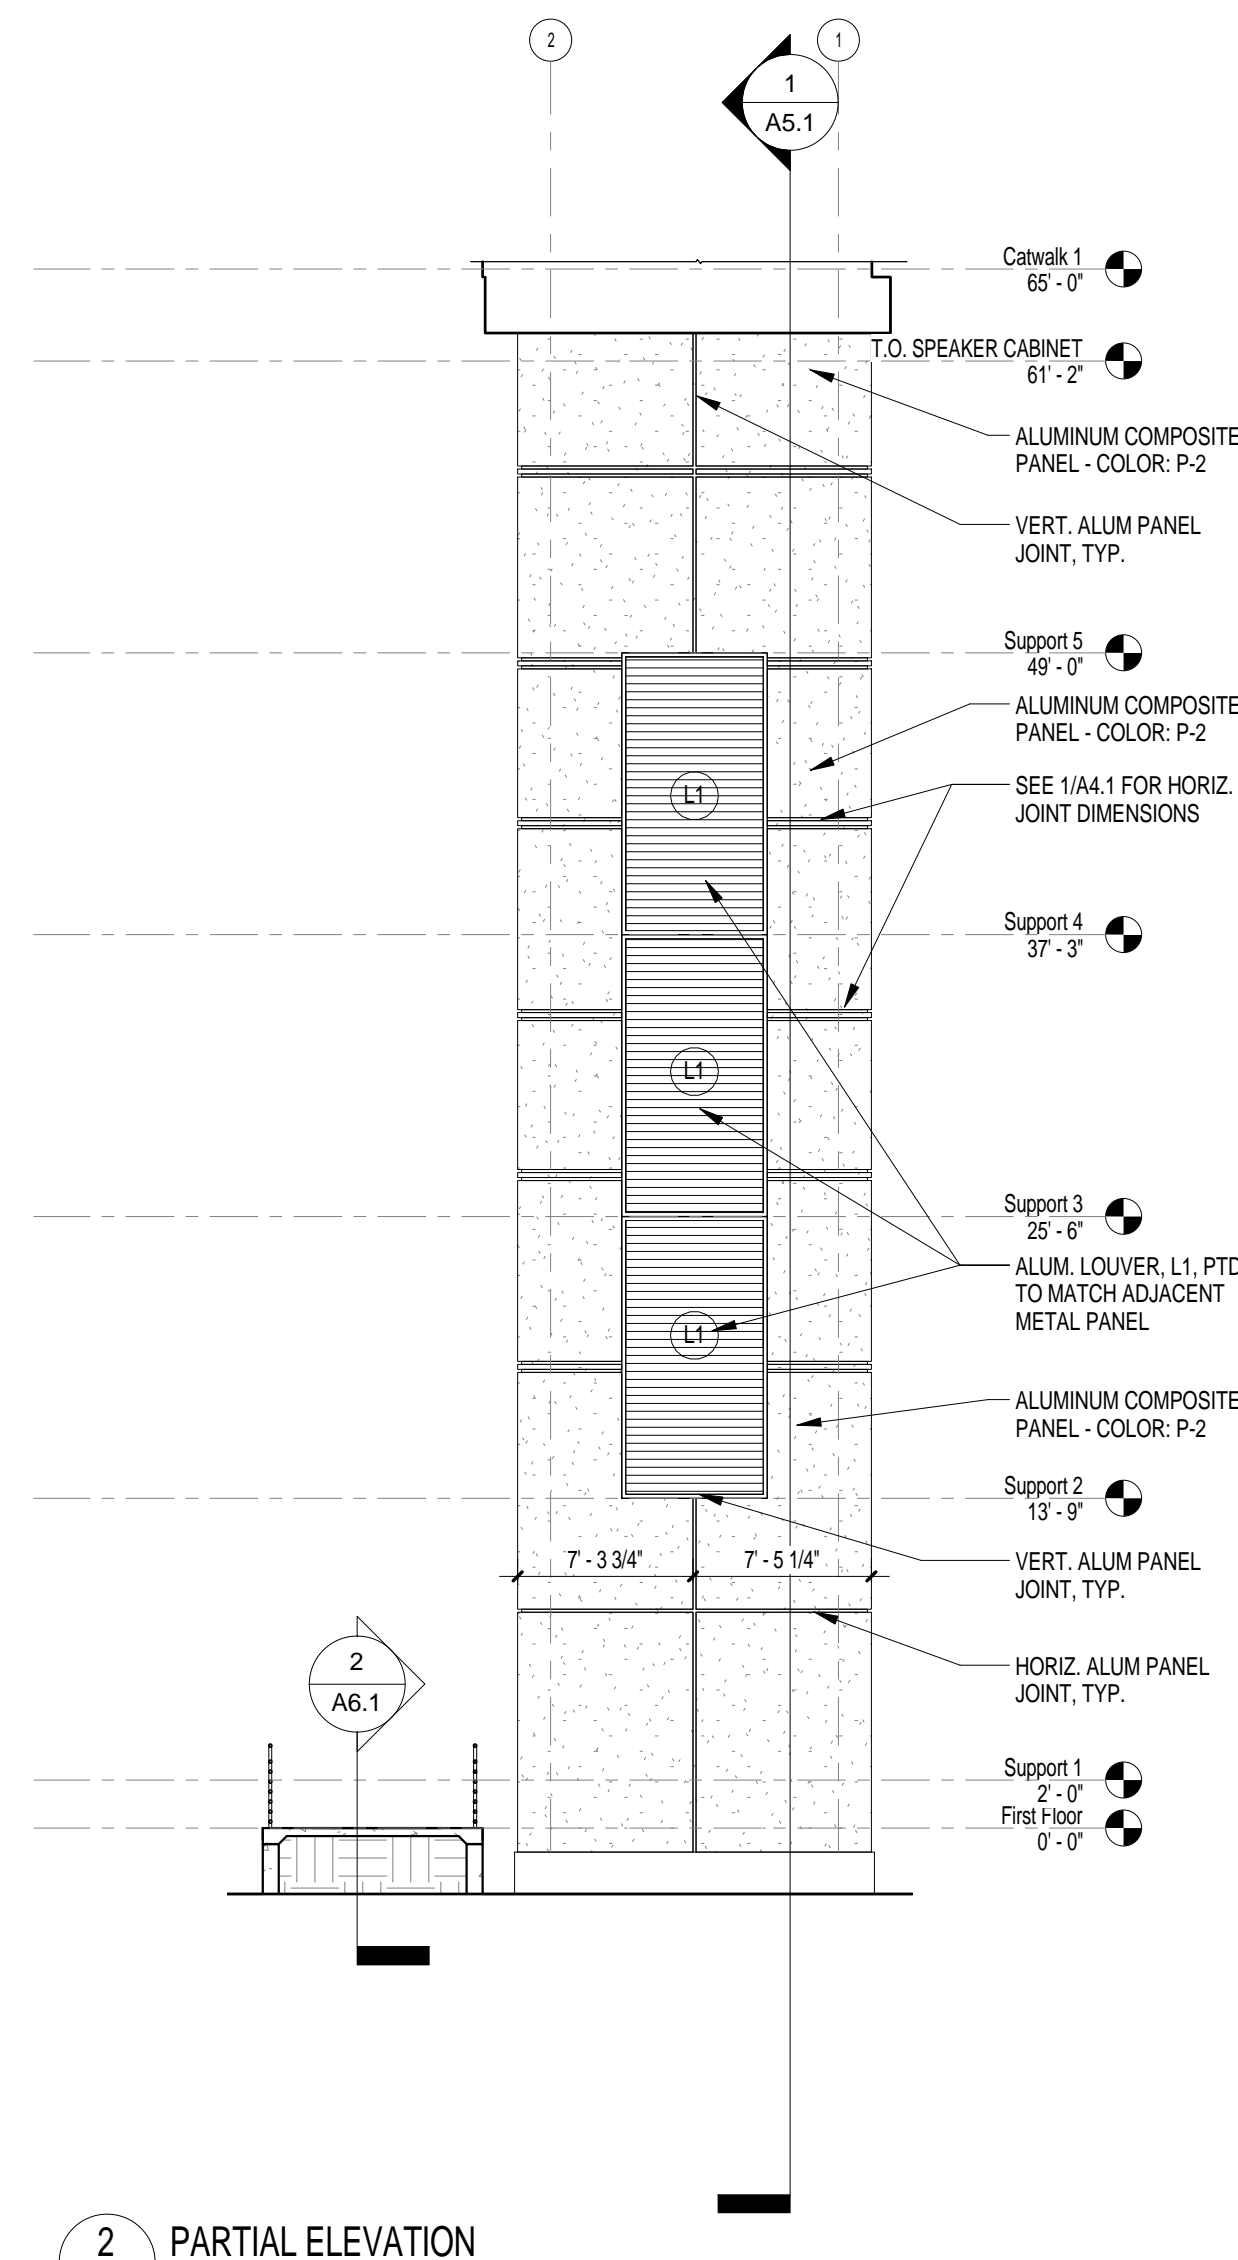

2 PARTIAL ELEVATION
A4.3 1/8" = 1'-0" REFERENCED ON: A1.1

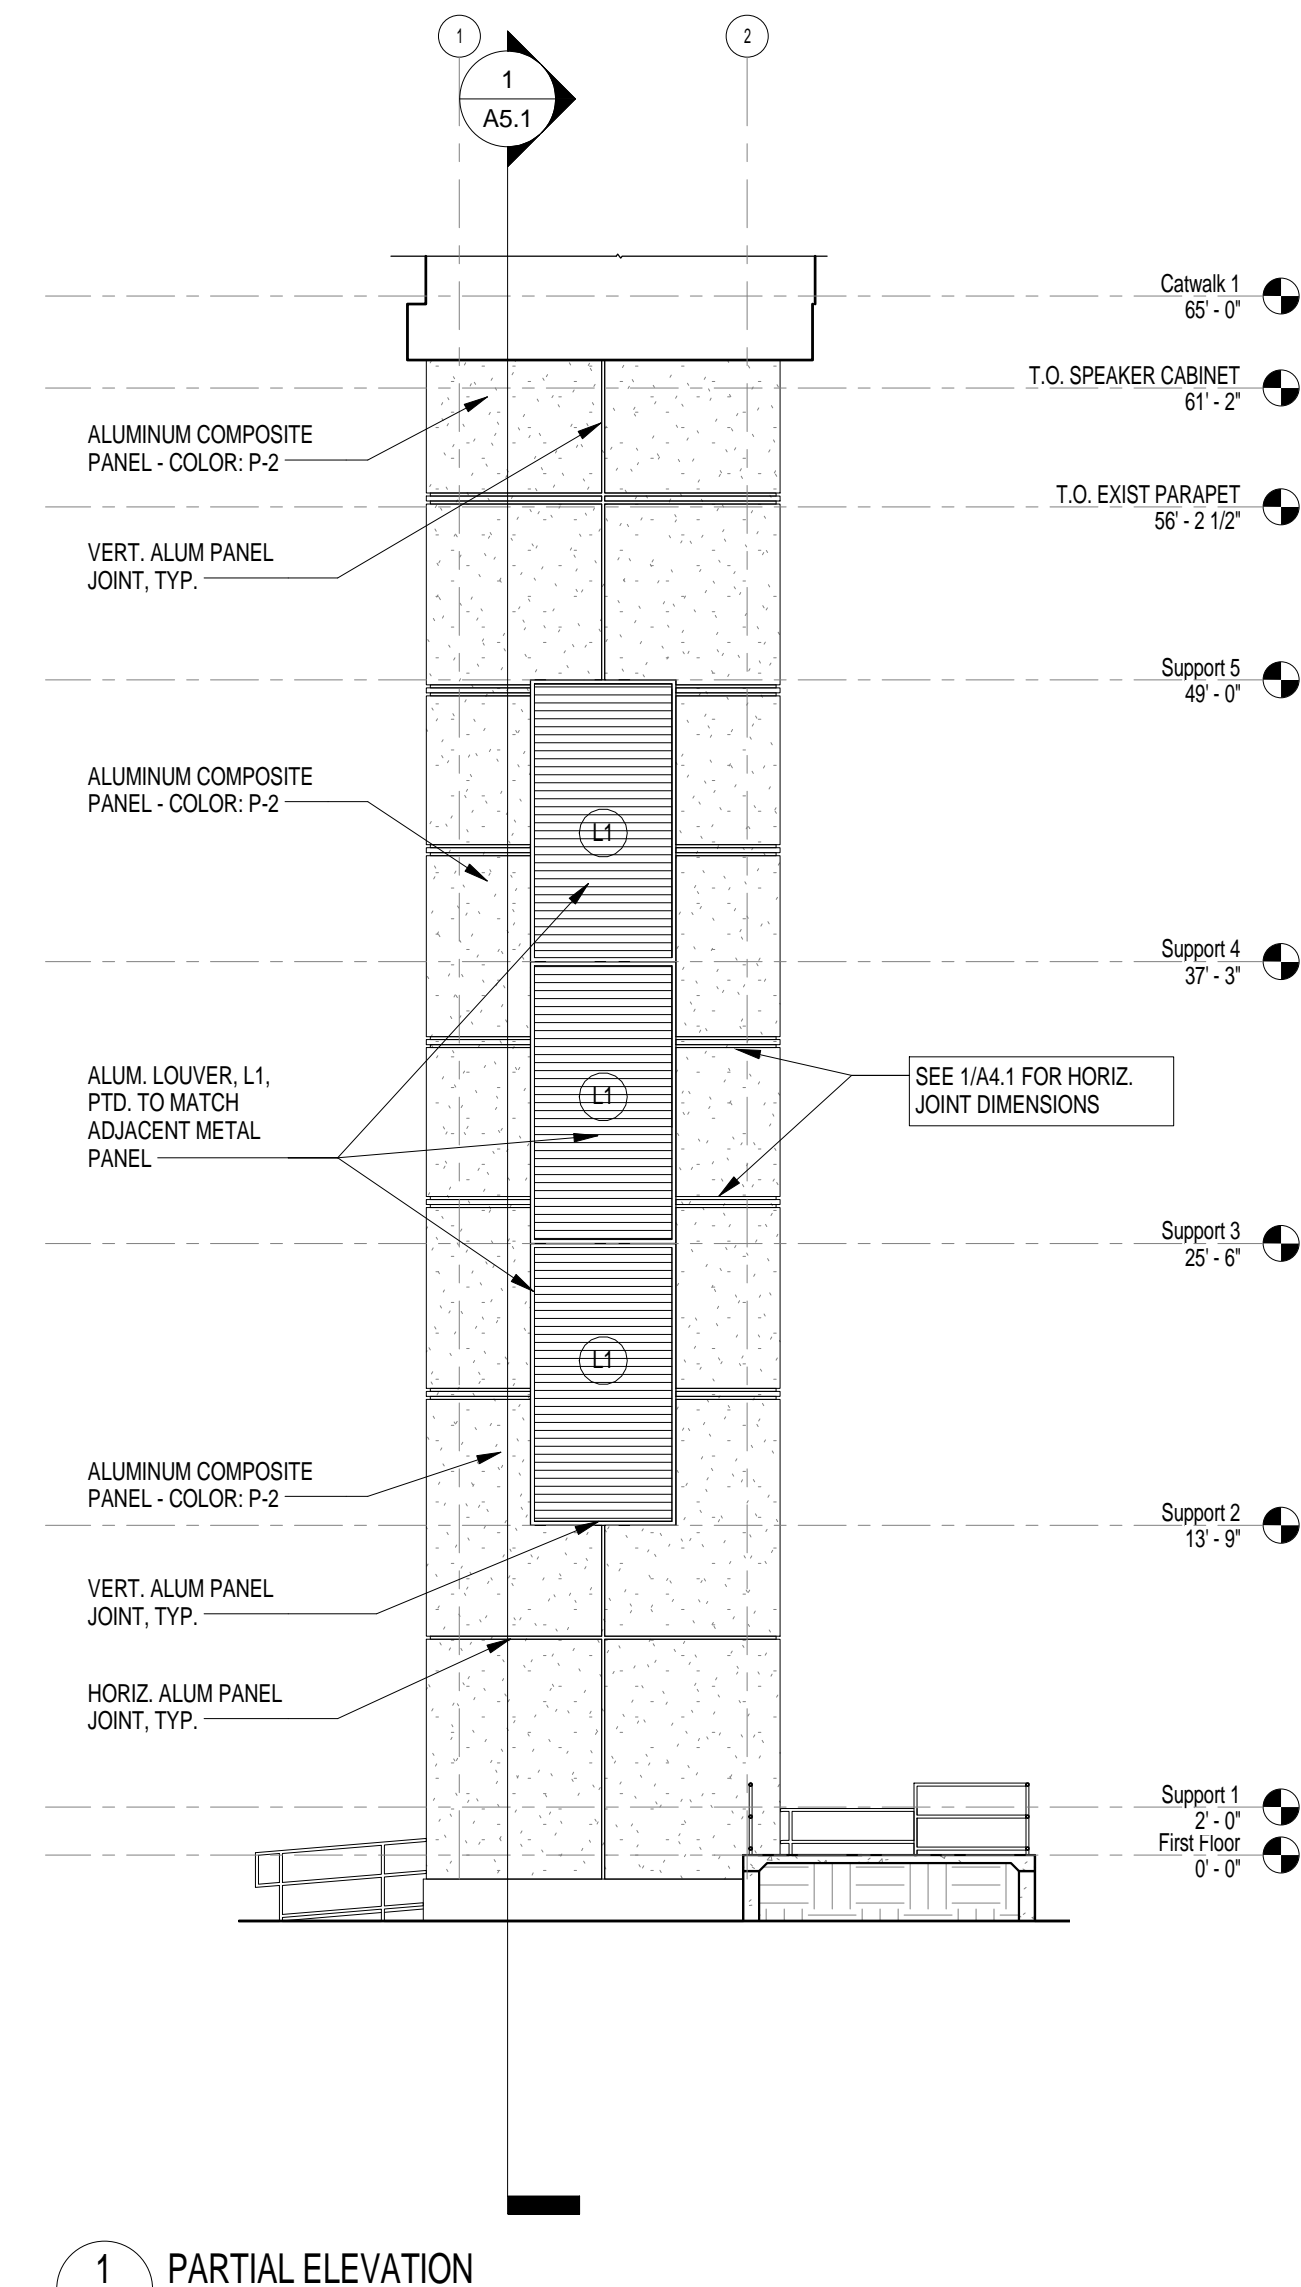

1 PARTIAL ELEVATION
A4.3 1/8" = 1'-0" REFERENCED ON: A1.1

AE SEAL

AE SEAL

PROJECT TITLE
WILLIAMS-BRICE STADIUM
VIDEO BOARD SUPPORT
CONSTRUCTION

UNIVERSITY OF SOUTH CAROLINA
COLUMBIA, SC
STATE PROJECT NO. H27-6089-MJ


NO.	REVISIONS	NAME	DATE

DRW BY: Author
CHKD BY: Checker


THIS DRAWING AND THE DESIGN THEREON ARE THE PROPERTY OF GARVIN DESIGN GROUP, INC. THE USER OF THIS DRAWING SHALL BE RESPONSIBLE FOR OBTAINING ALL NECESSARY PERMITS AND ANY REVISIONS TO THIS DRAWING SHALL BE THE RESPONSIBILITY OF THE USER. SUBJECT TO REGULATION, GARVIN DESIGN GROUP, INC.

DRAWING TITLE
ELEVATIONS,
LOUVER ELEVATIONS
& DETAILS


PROJECT NO. U291.11
DATE 12-30-11
DRAWING NO. **A4.3**

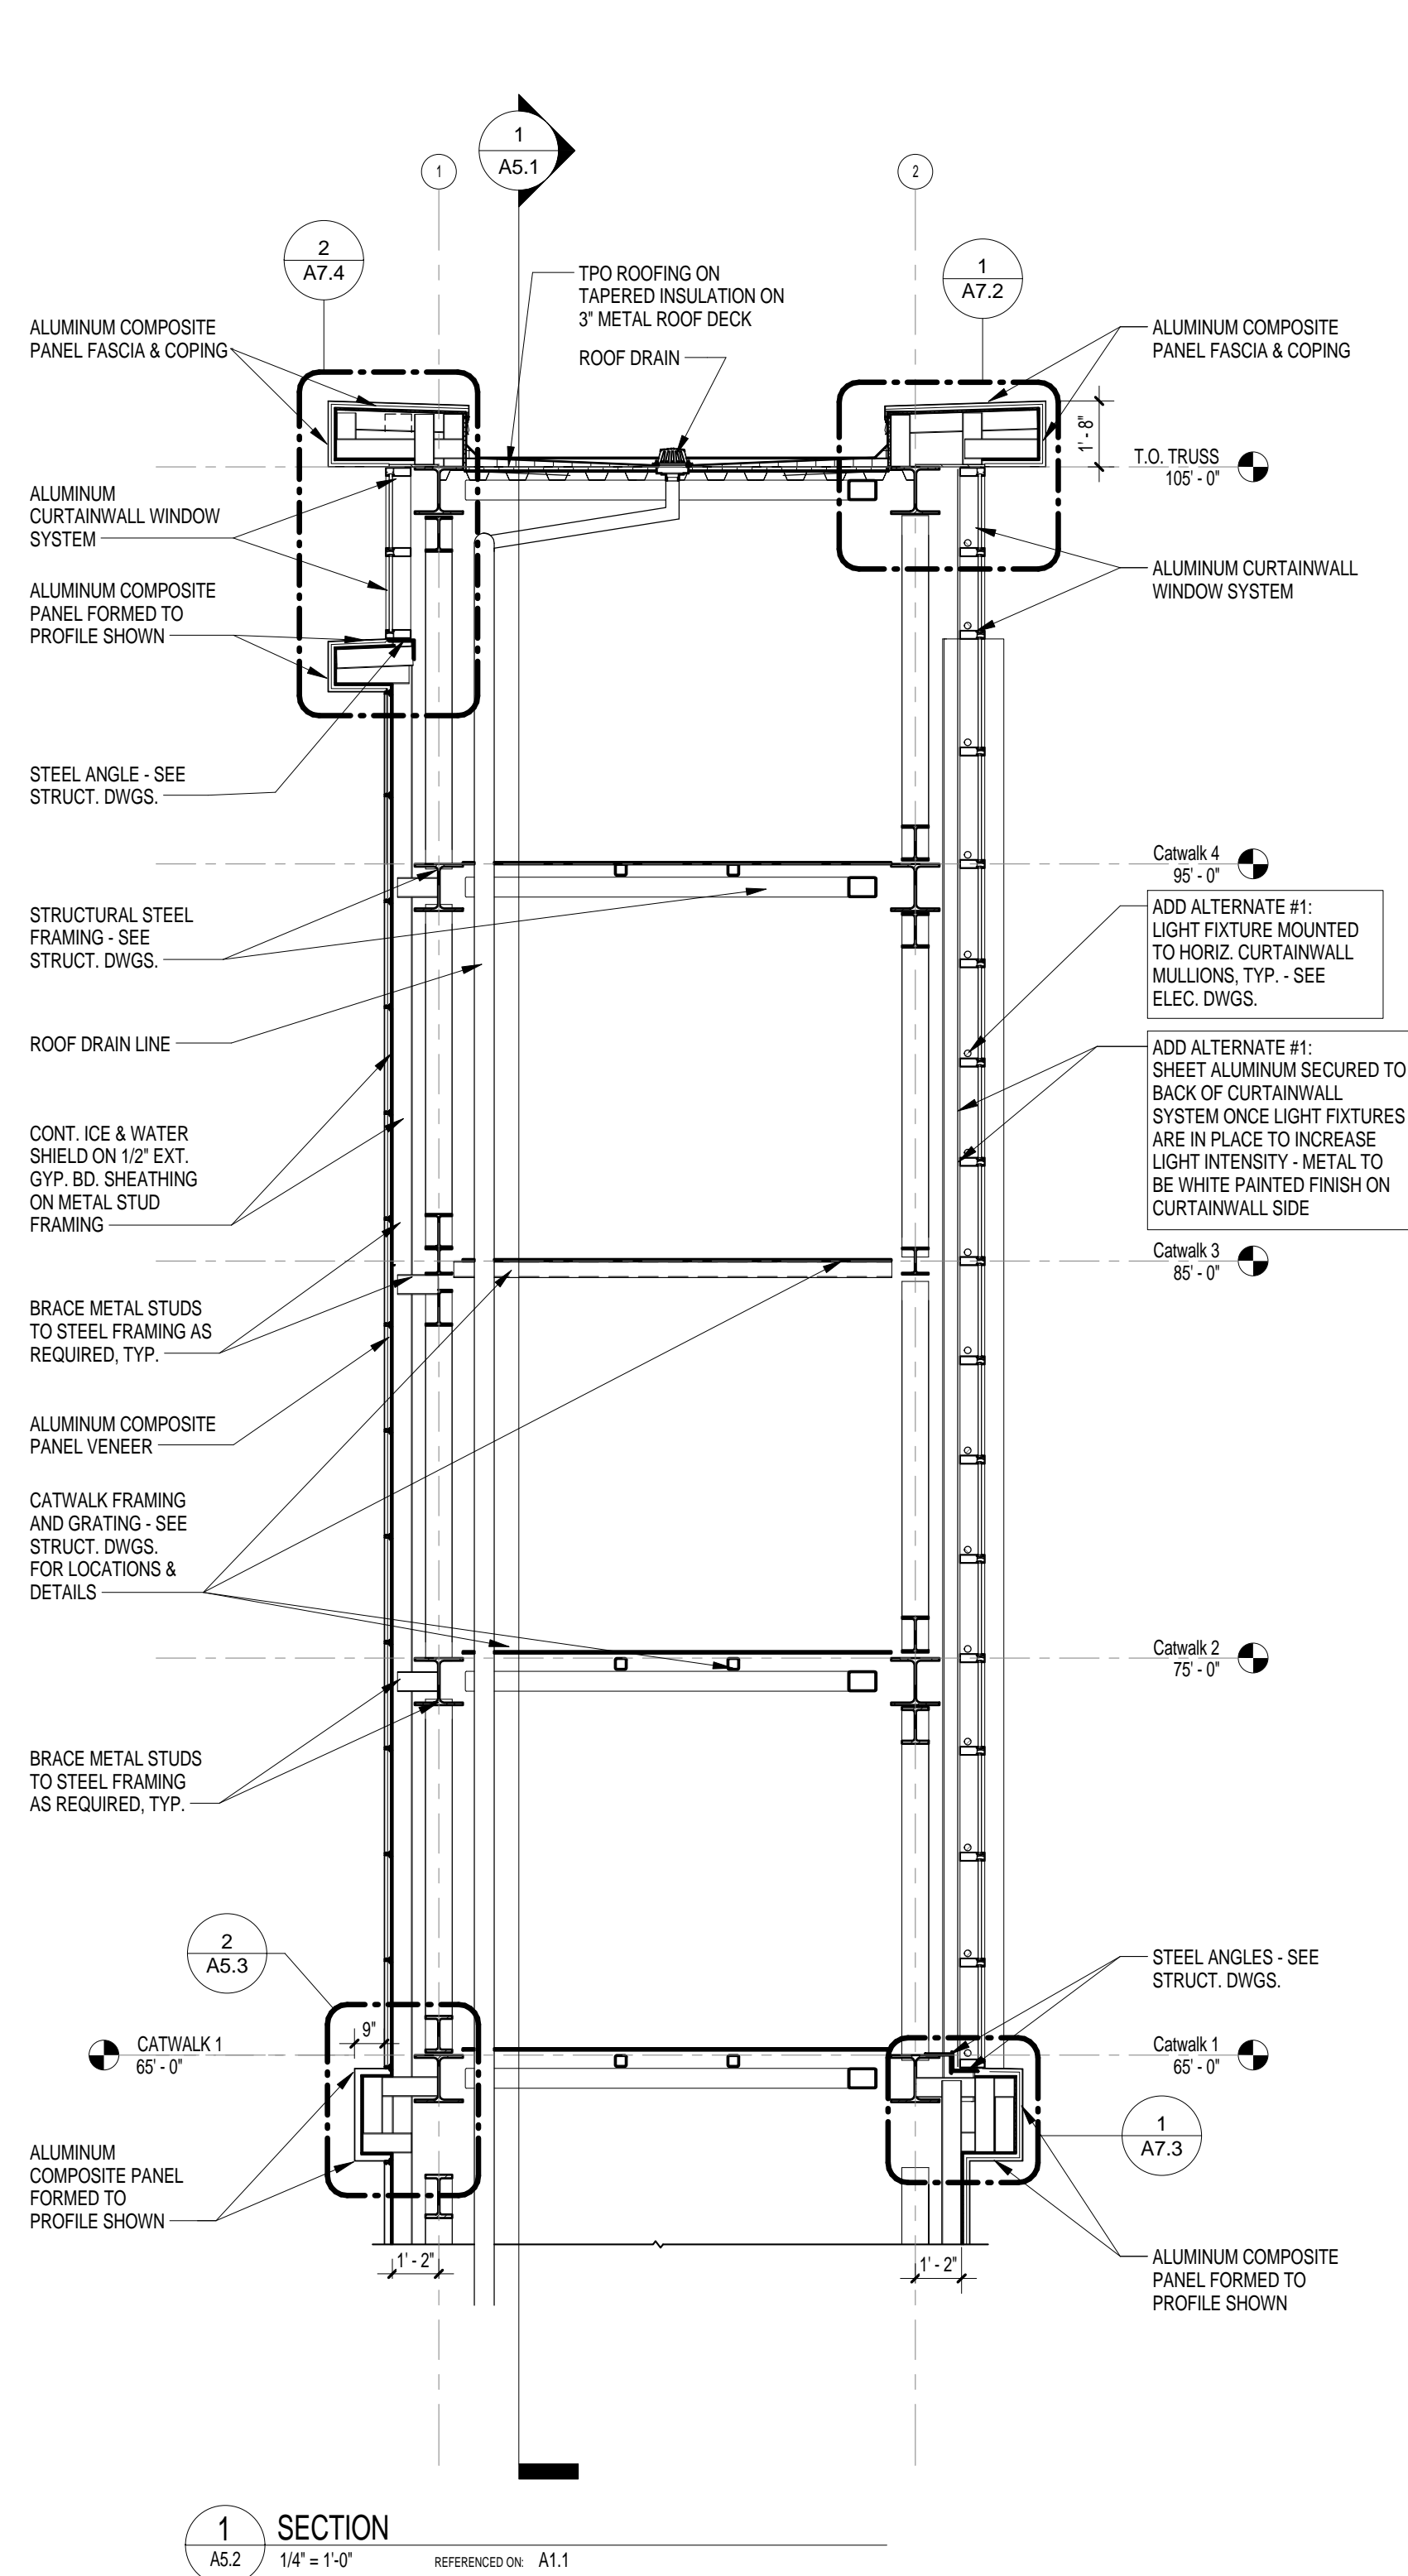

1 SECTION
A5.2 1/4" = 1'-0" REFERENCED ON: A1.1

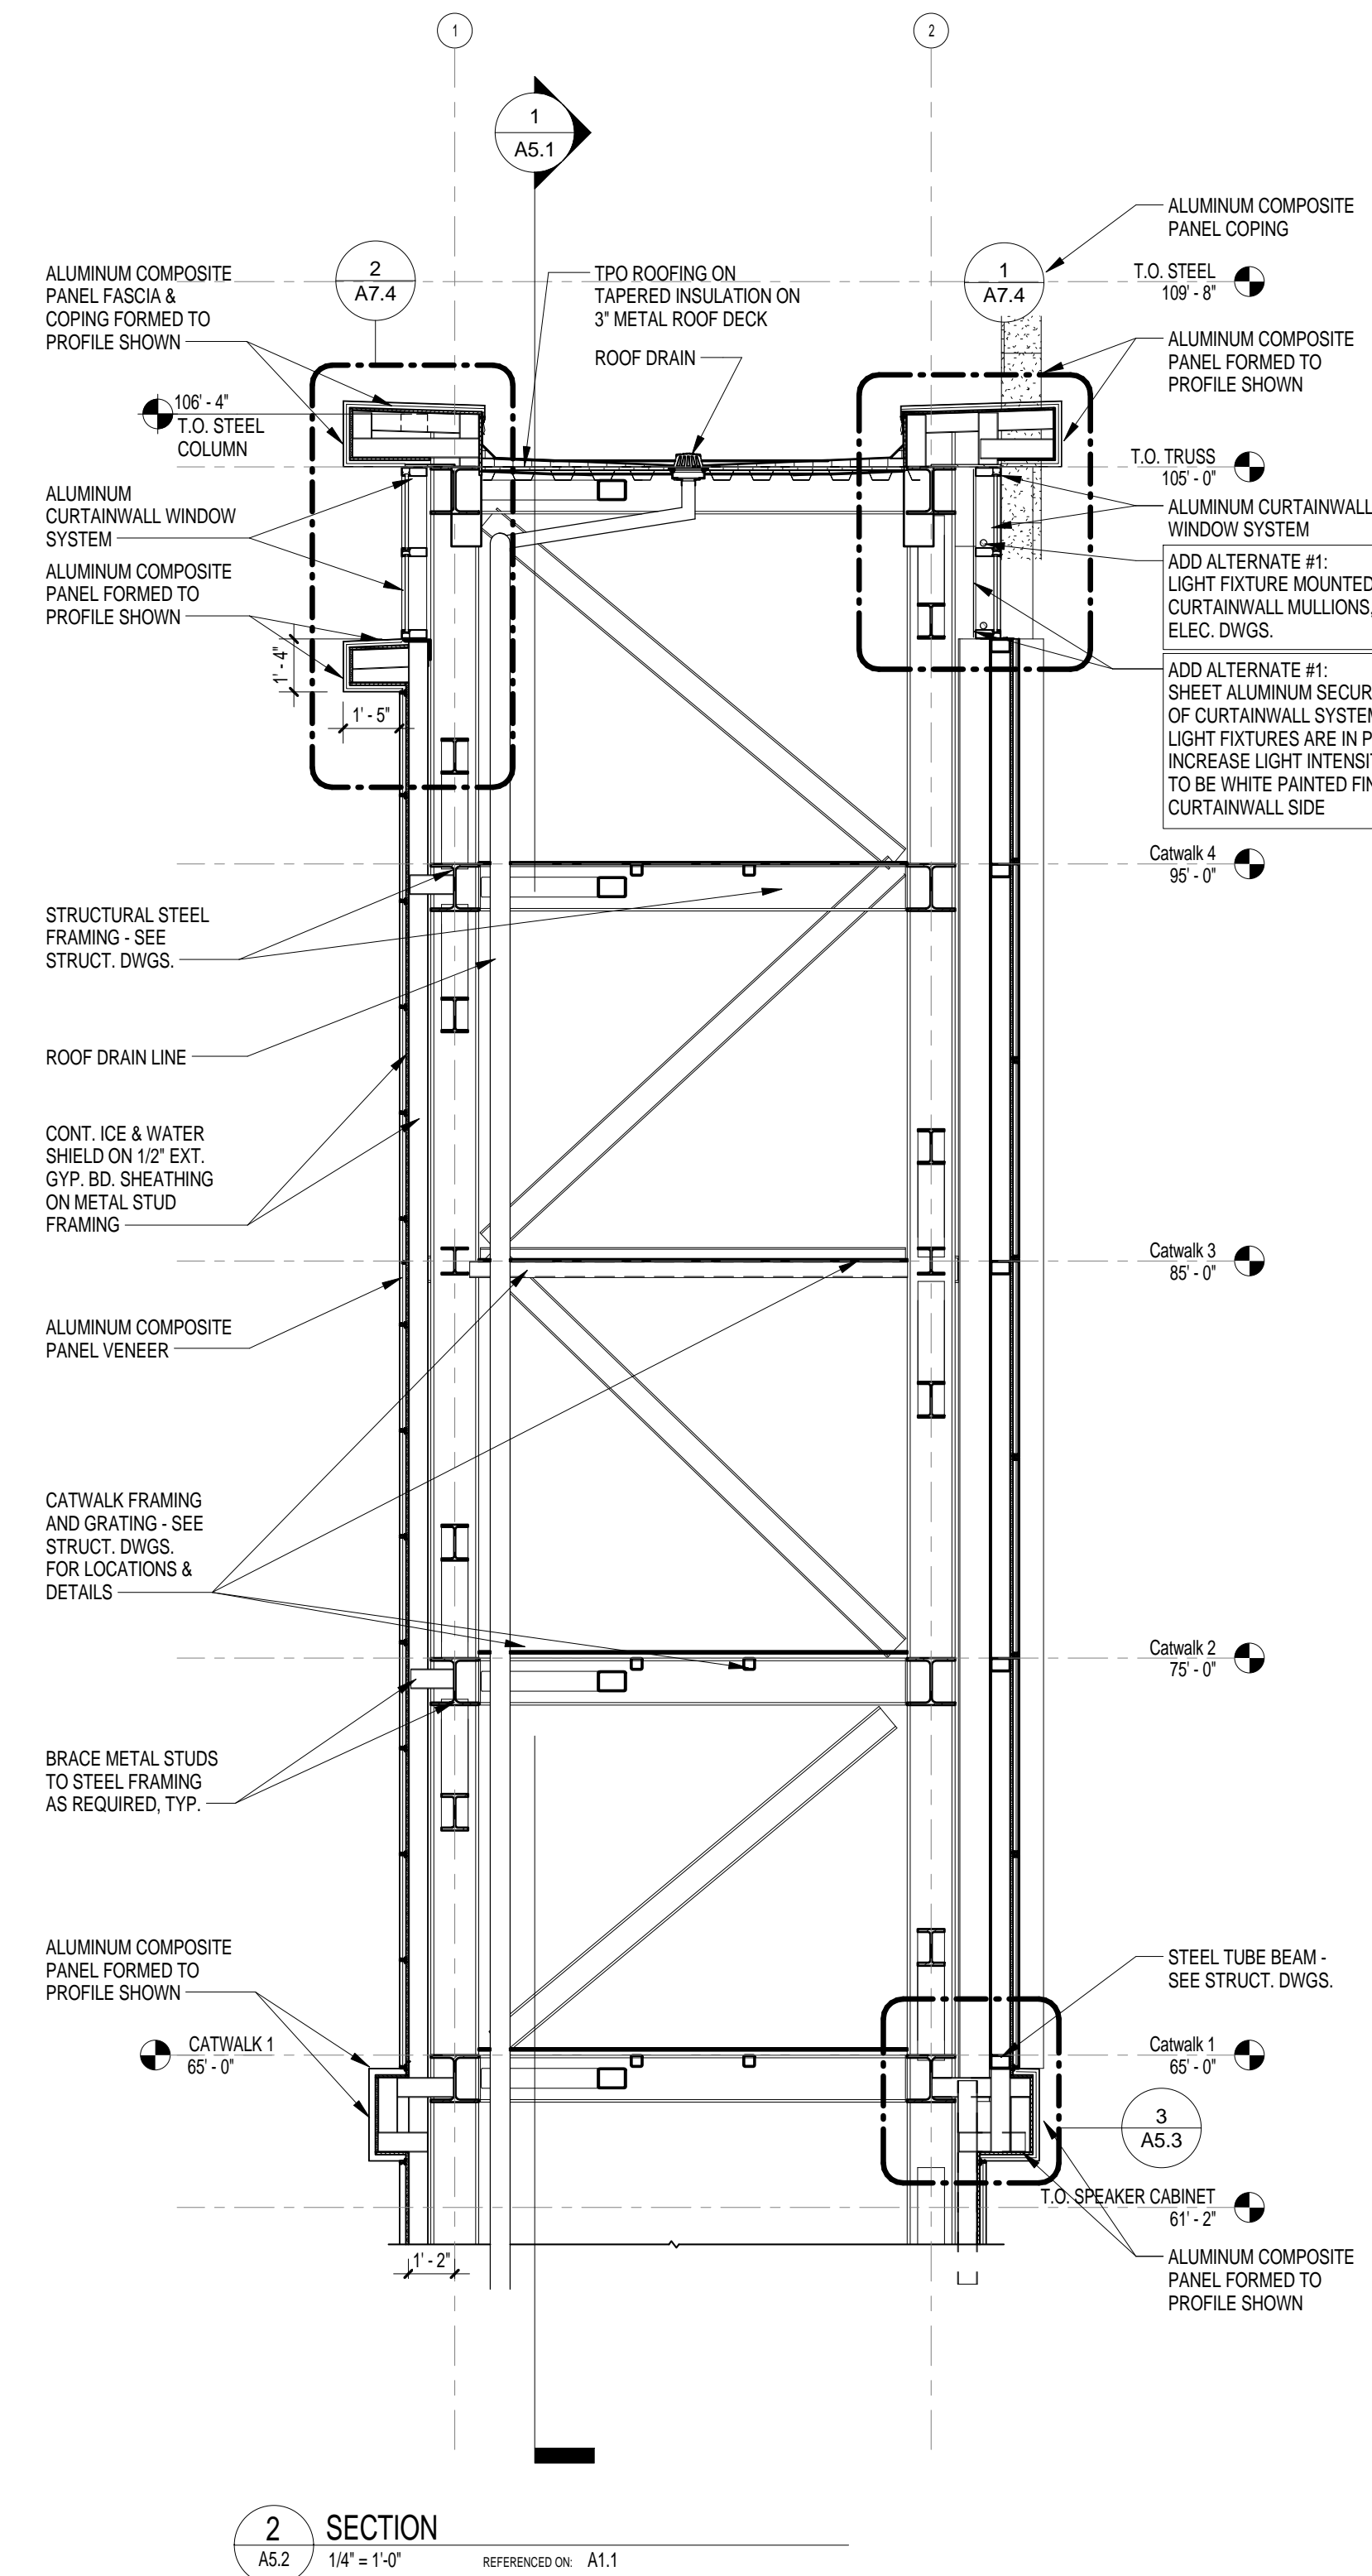

2 SECTION
A5.2 1/4" = 1'-0" REFERENCED ON: A1.1

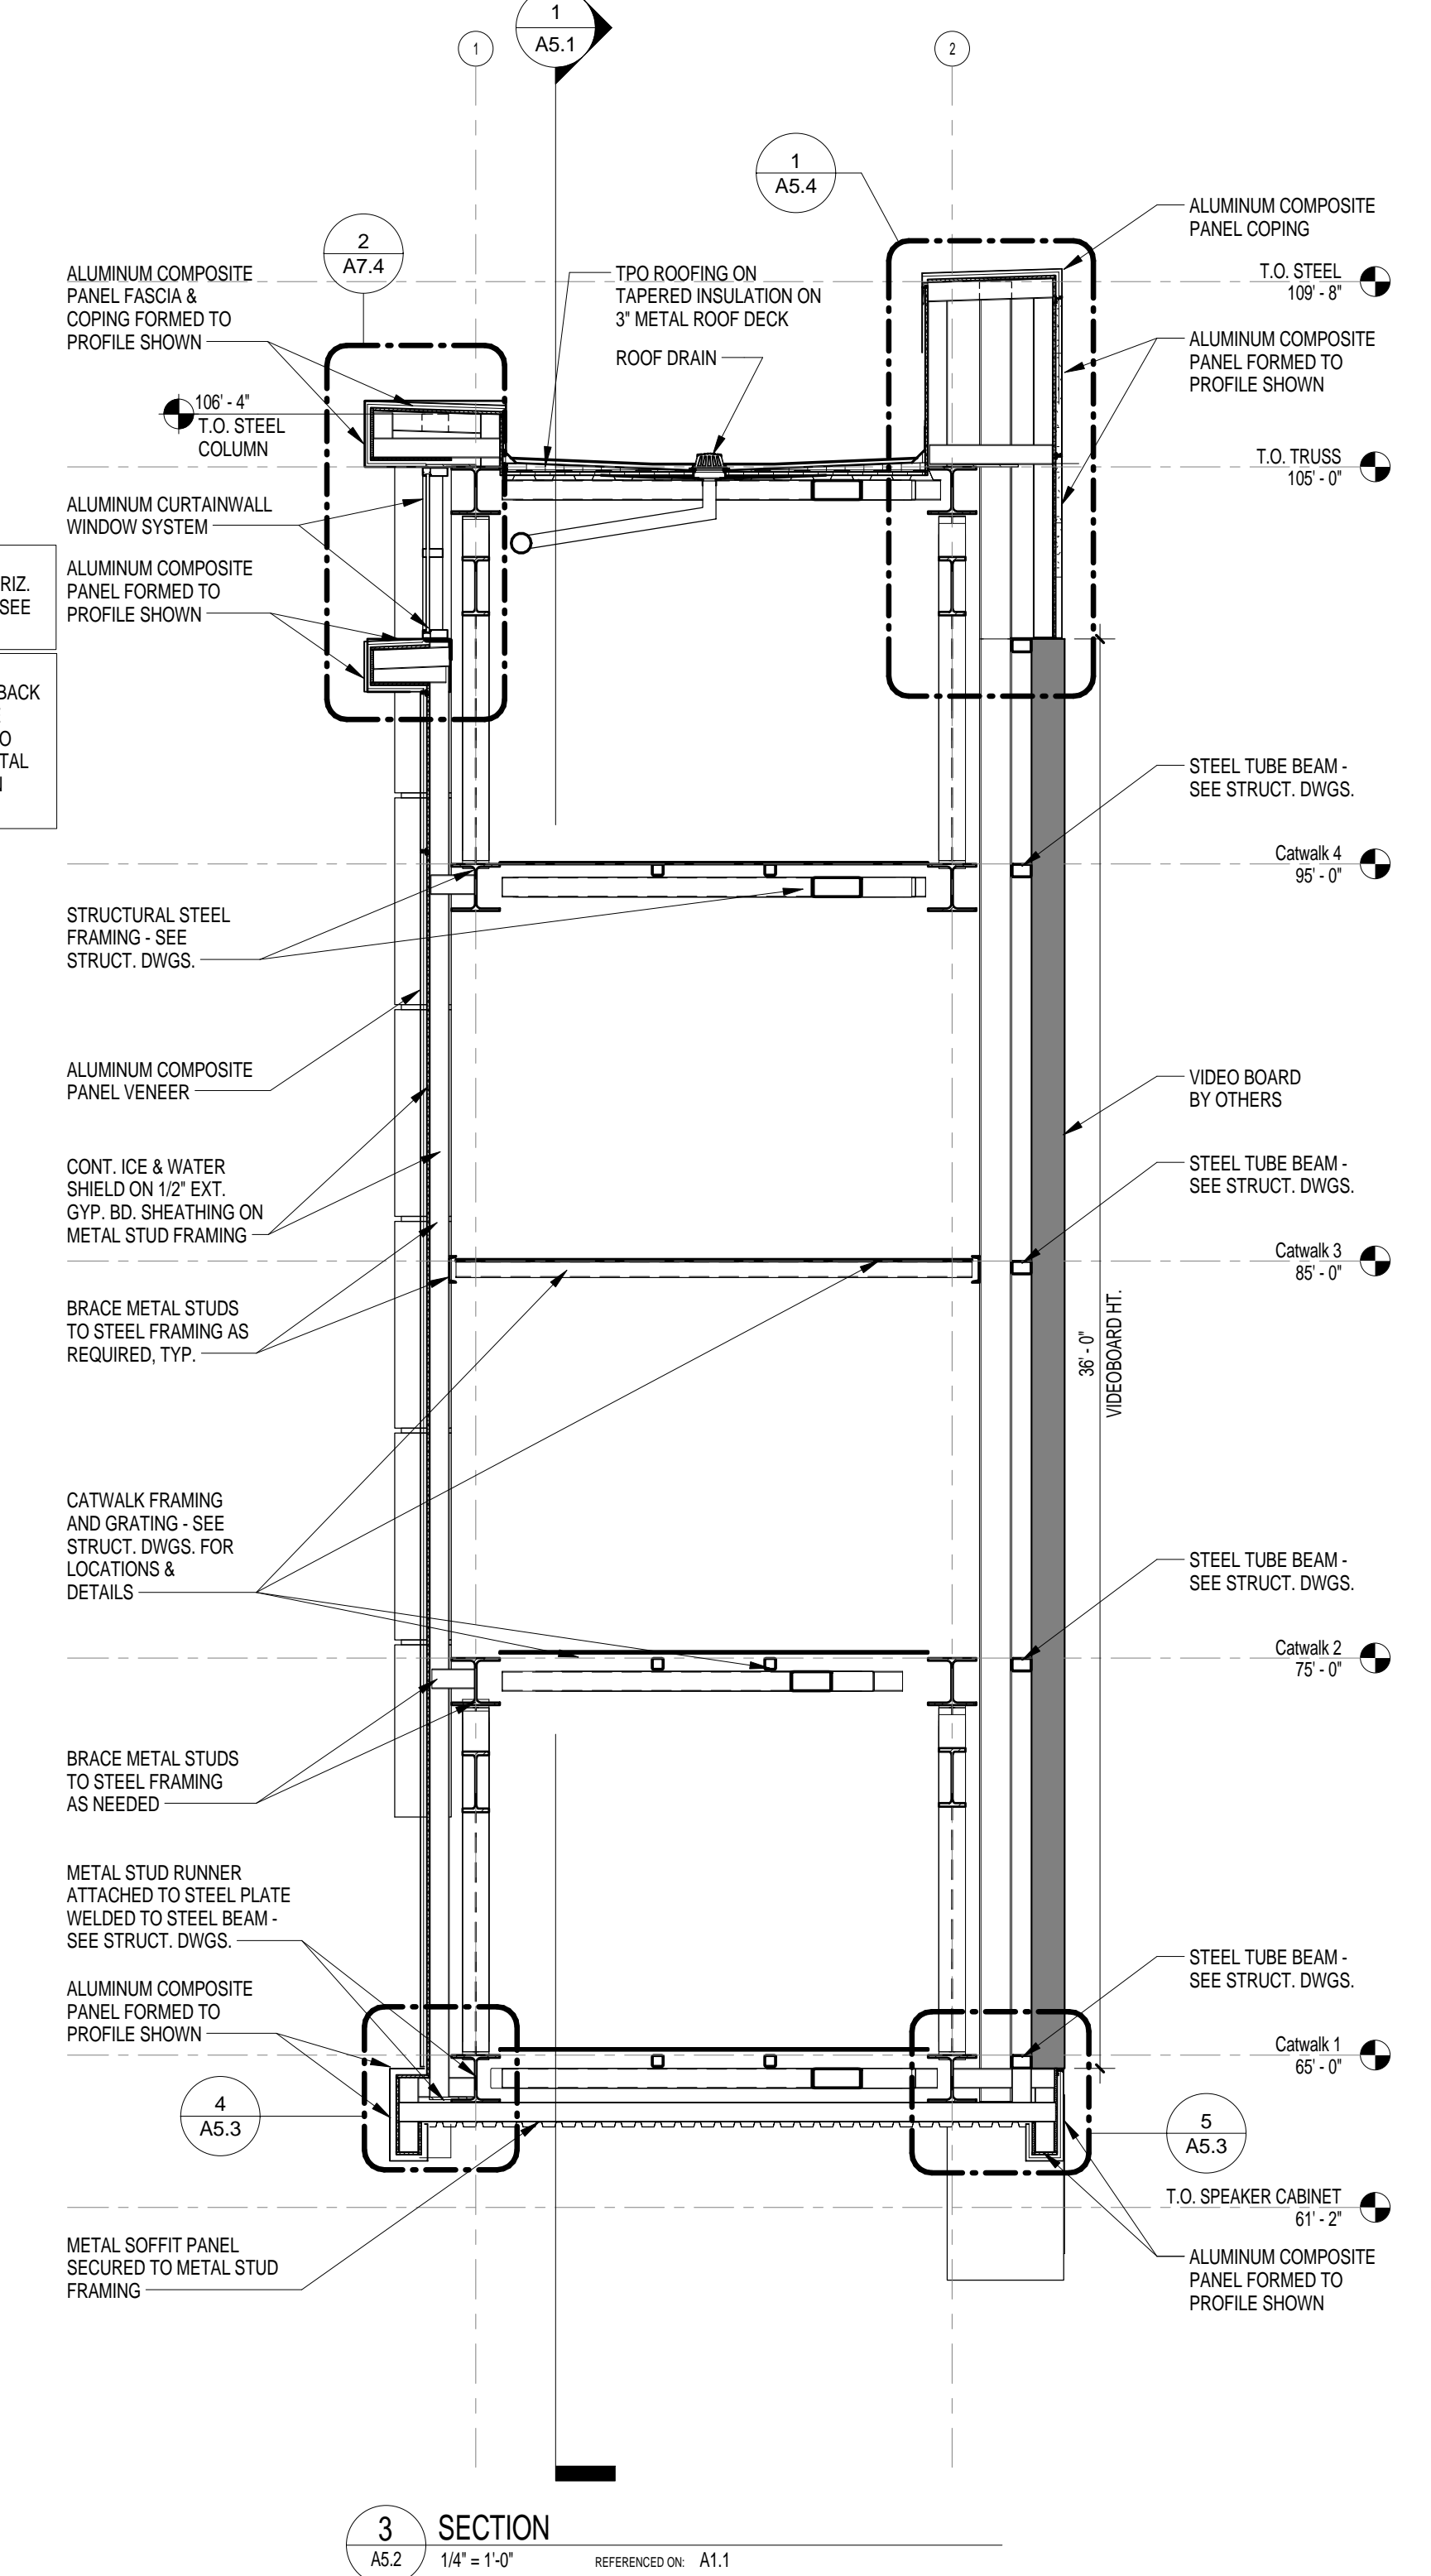

3 SECTION
A5.2 1/4" = 1'-0" REFERENCED ON: A1.1

AE SEAL
AE SEAL

PROJECT TITLE
WILLIAMS-BRICE STADIUM
VIDEO BOARD SUPPORT
CONSTRUCTION
UNIVERSITY OF SOUTH CAROLINA
COLUMBIA, SC
STATE PROJECT NO. H27-6089-MJ

NO.	REVISIONS	NAME	DATE

DRAWN BY: Author
CHKD BY: Checker
THIS DRAWING AND THE DESIGN HEREON ARE THE PROPERTY OF GARVIN DESIGN GROUP, INC. THE USER OF THIS DRAWING AGREES TO HOLD GARVIN DESIGN GROUP, INC. HARMLESS AND TO INDEMNIFY AND DEFEND GARVIN DESIGN GROUP, INC. FROM AND AGAINST ALL SUCH CLAIMS, DAMAGES, LOSSES AND EXPENSES, INCLUDING REASONABLE ATTORNEY'S FEES, THAT MAY BE ASSERTED AGAINST OR INCURRED BY GARVIN DESIGN GROUP, INC.

DRAWING TITLE
SECTIONS

PROJECT NO. U291.11
DATE 12-30-11
DRAWING NO. A5.2

AE SEAL
 AE SEAL


PROJECT TITLE
WILLIAMS-BRICE STADIUM
VIDEO BOARD SUPPORT
CONSTRUCTION
 UNIVERSITY OF SOUTH CAROLINA
 COLUMBIA, SC
 STATE PROJECT NO. H27-6089-MJ

NO.	REVISIONS	NAME	DATE


DRAWN BY: Author
CHKD BY: Checker

DRAWING TITLE
SECTIONS, SECTION
DETAILS


PROJECT NO. U291.11
DATE 12.20.11
DRAWING NO.
A5.3

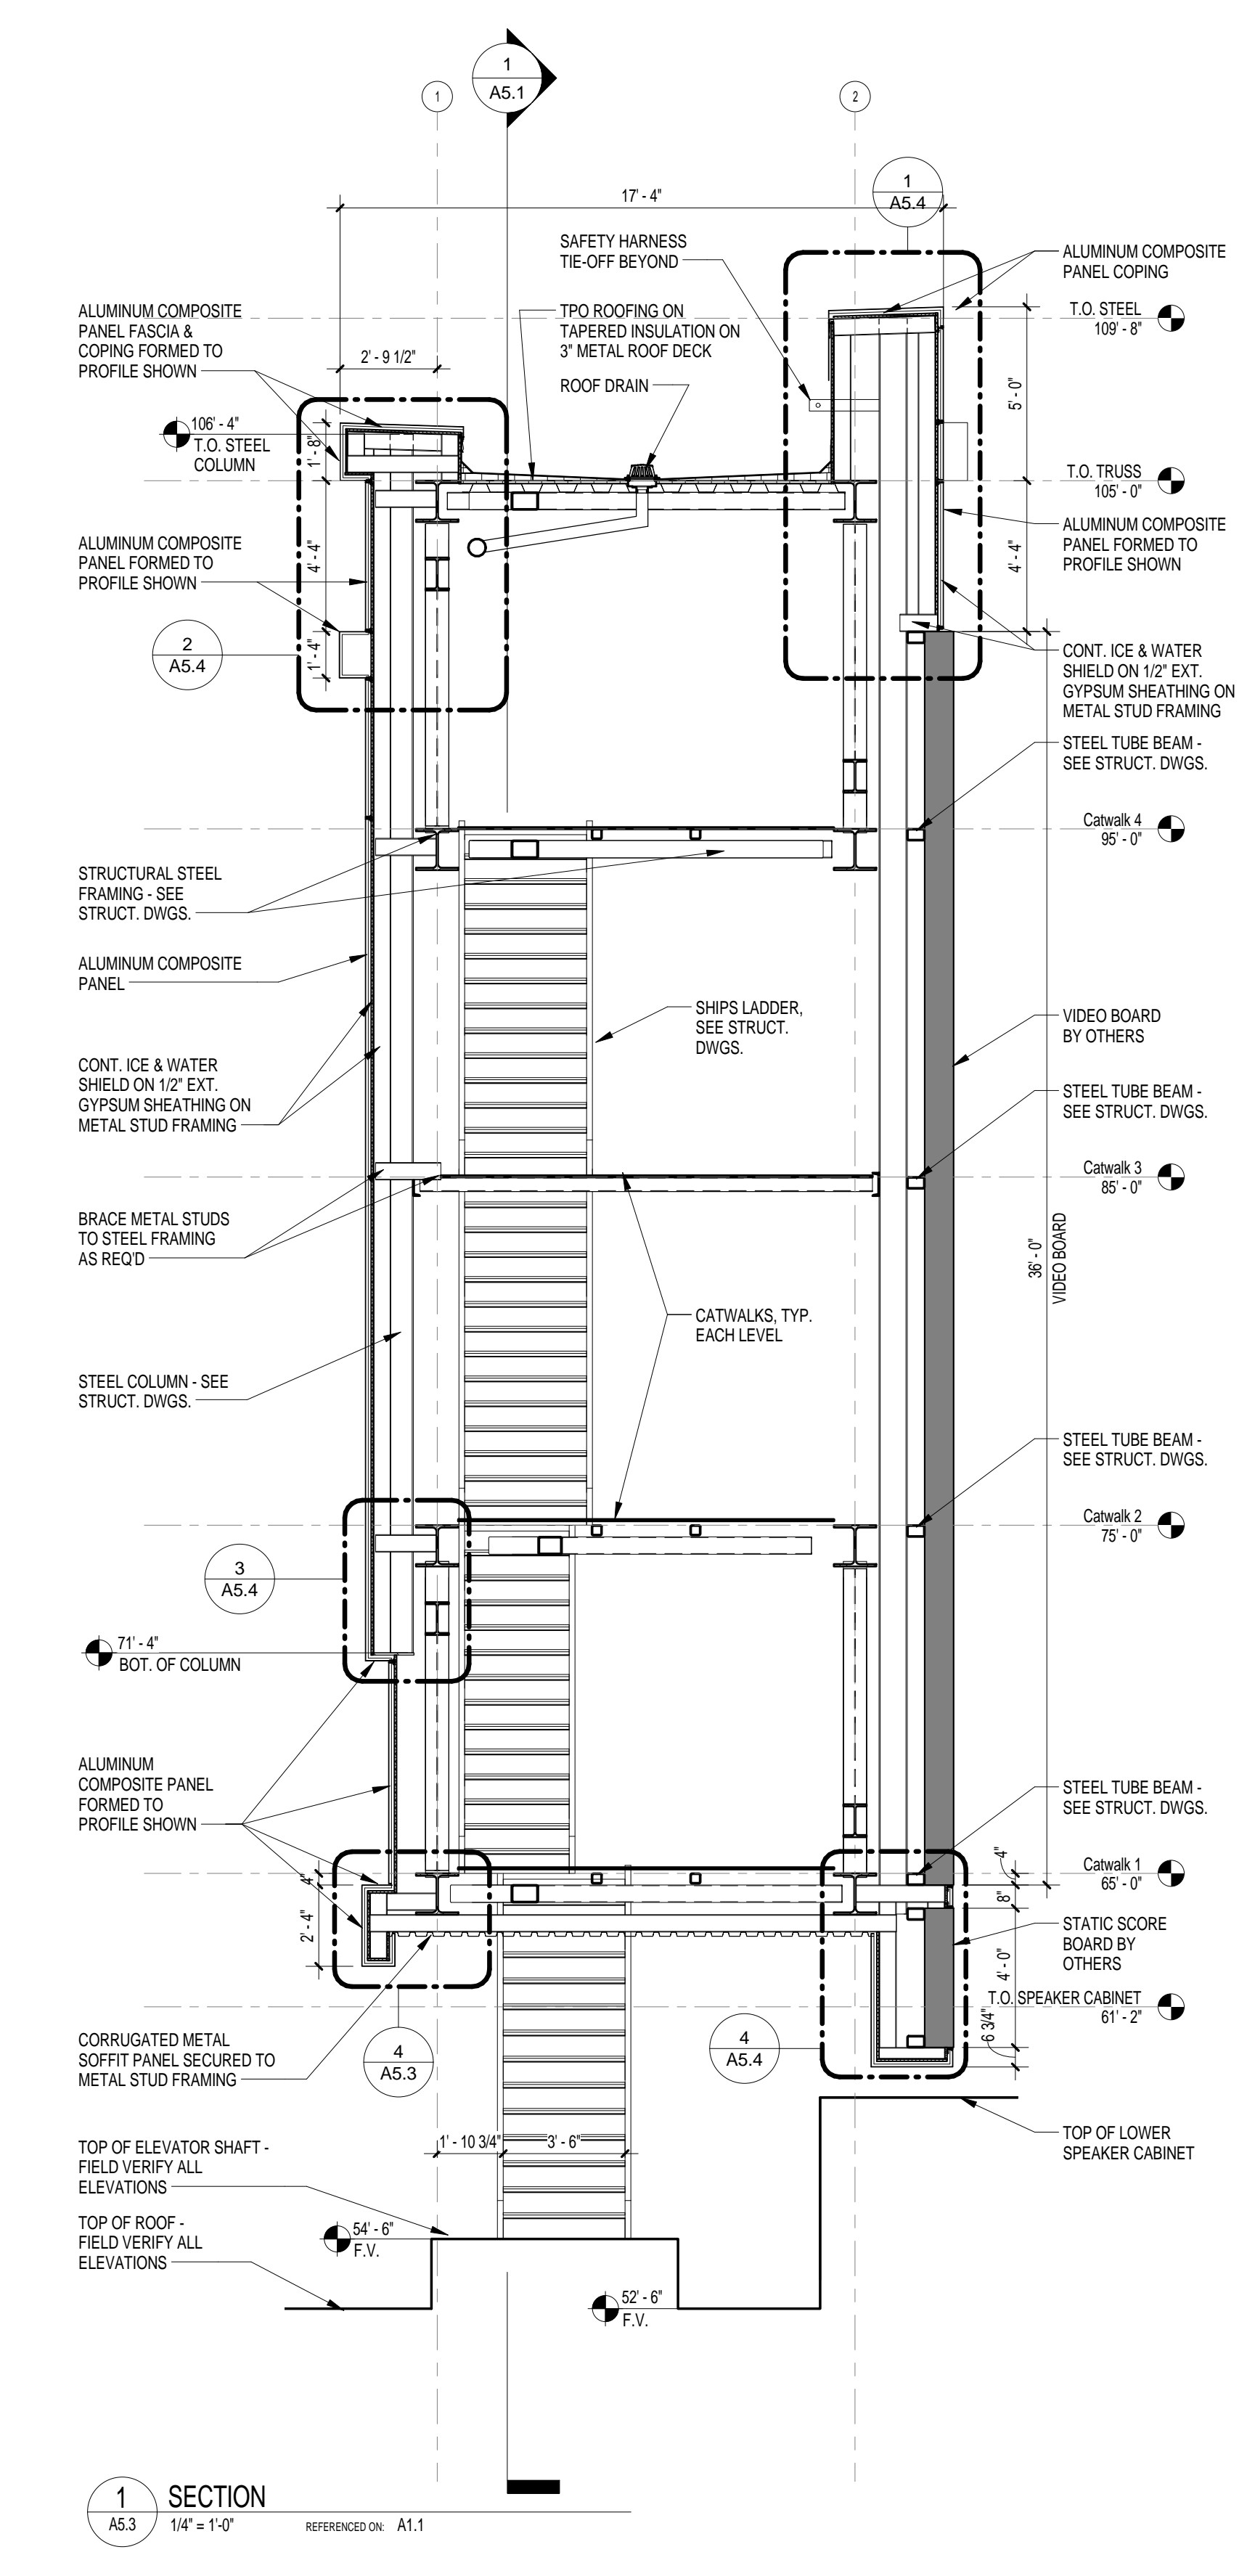


1 SECTION
 A5.3 1/4" = 1'-0" REFERENCED ON: A1.1

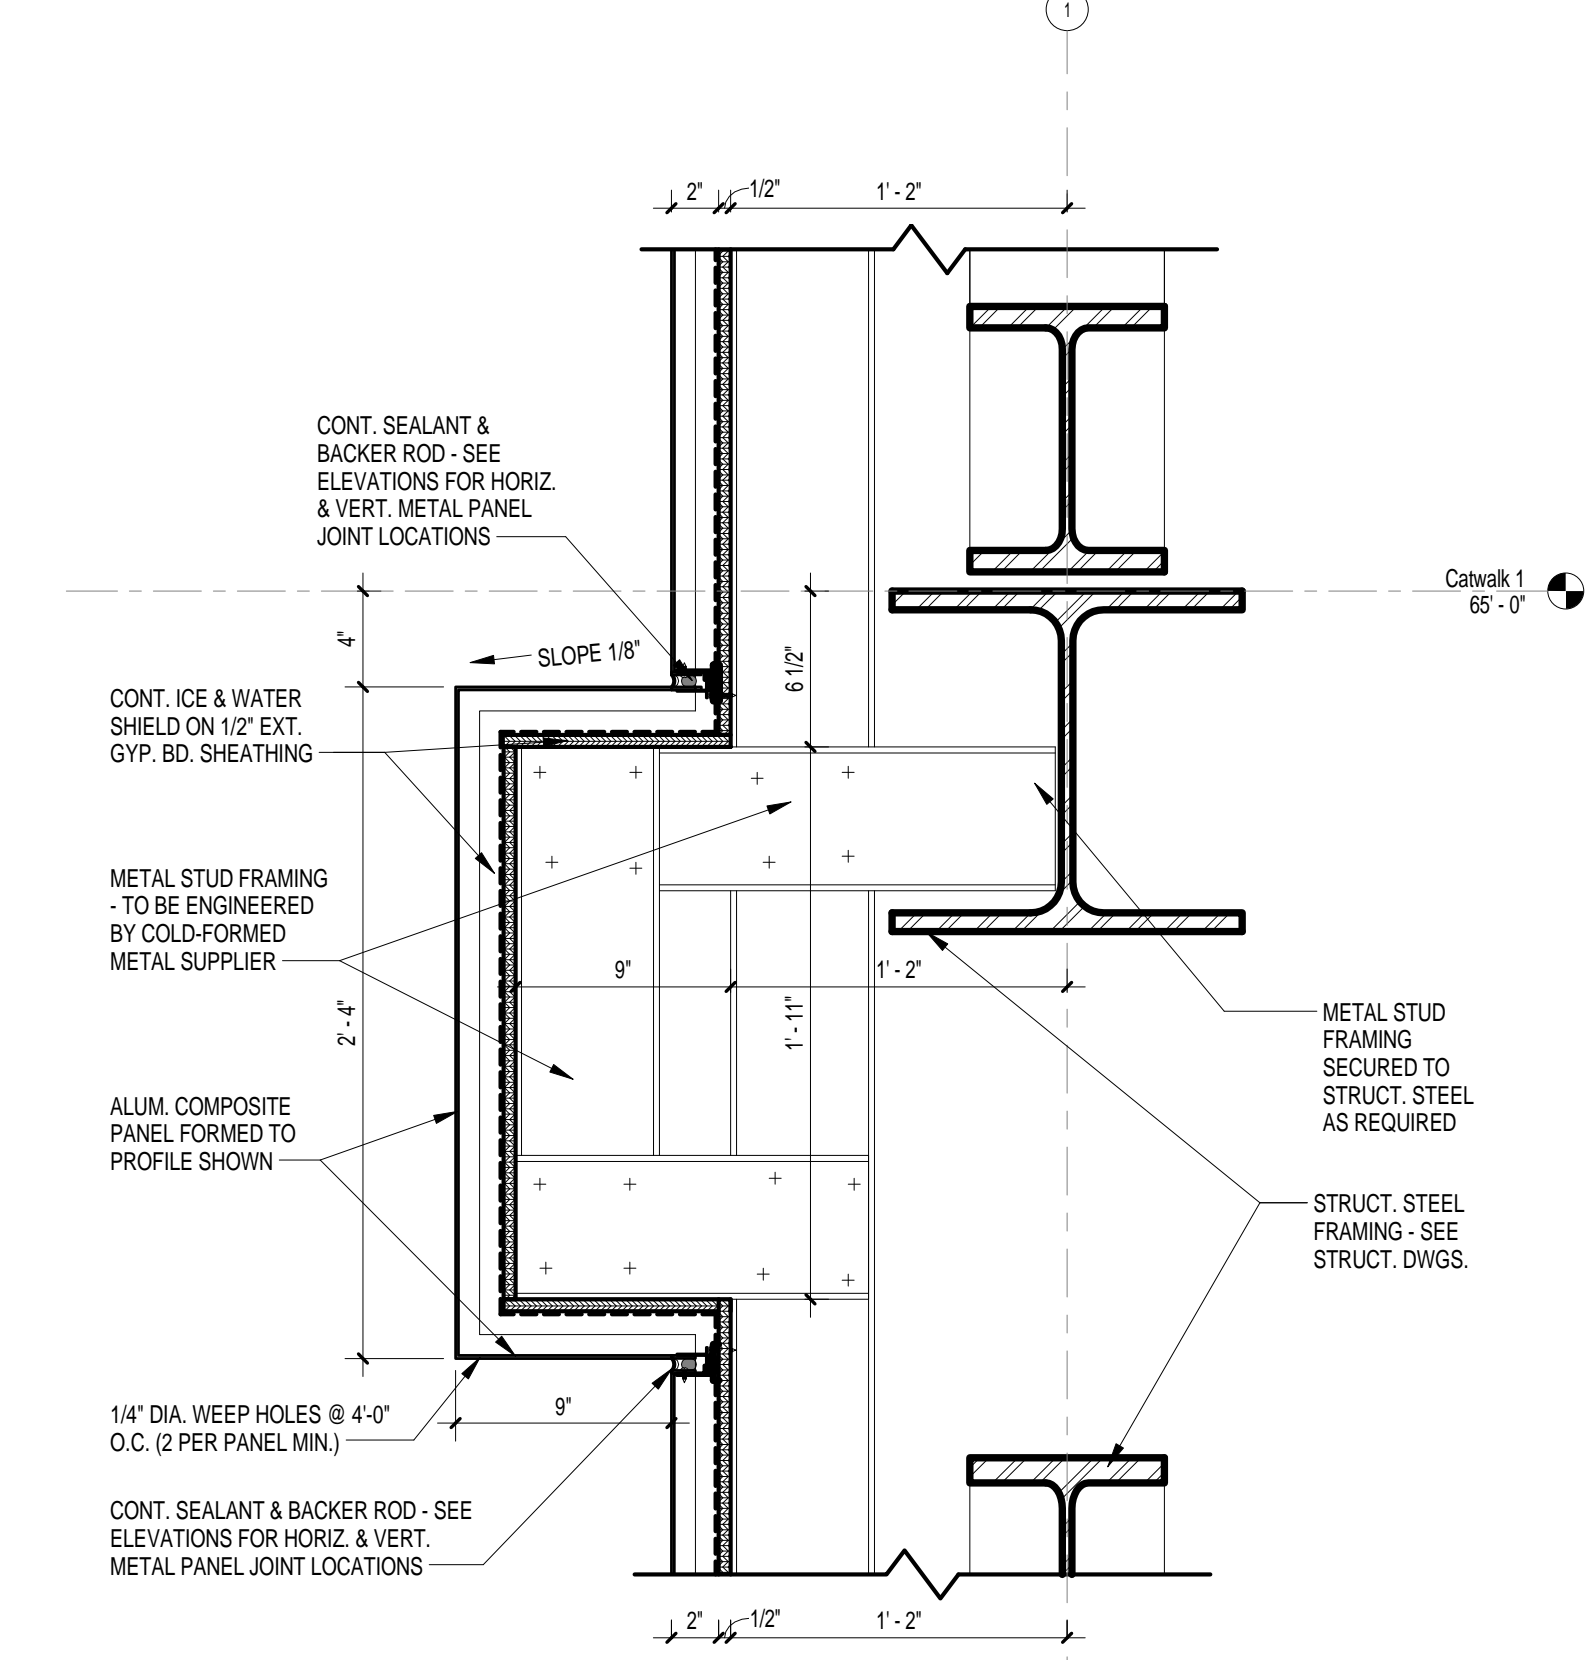


2 SECTION DETAIL
 A5.3 1 1/2" = 1'-0" REFERENCED ON: A5.2

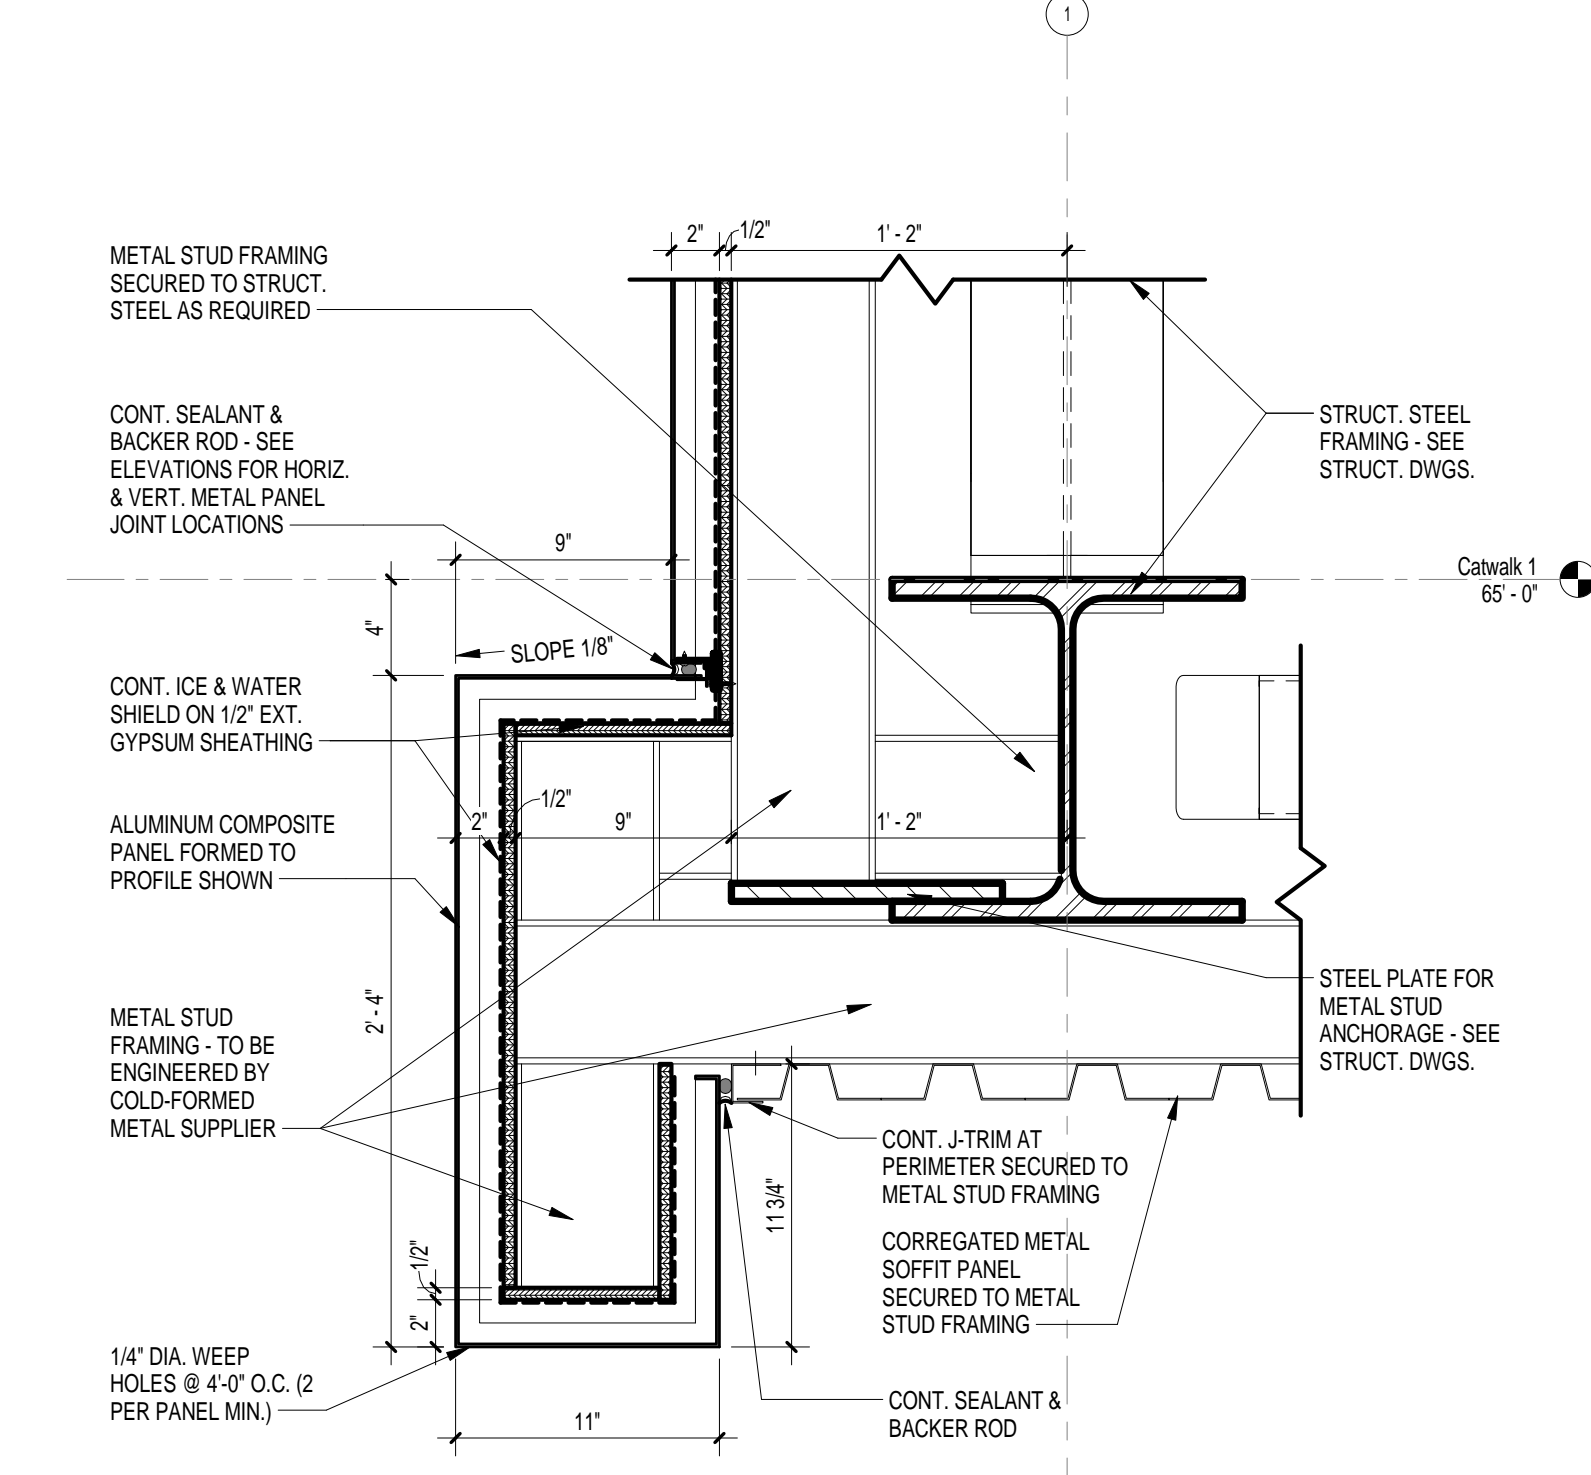


4 SECTION DETAIL
 A5.3 1 1/2" = 1'-0" REFERENCED ON: A5.2

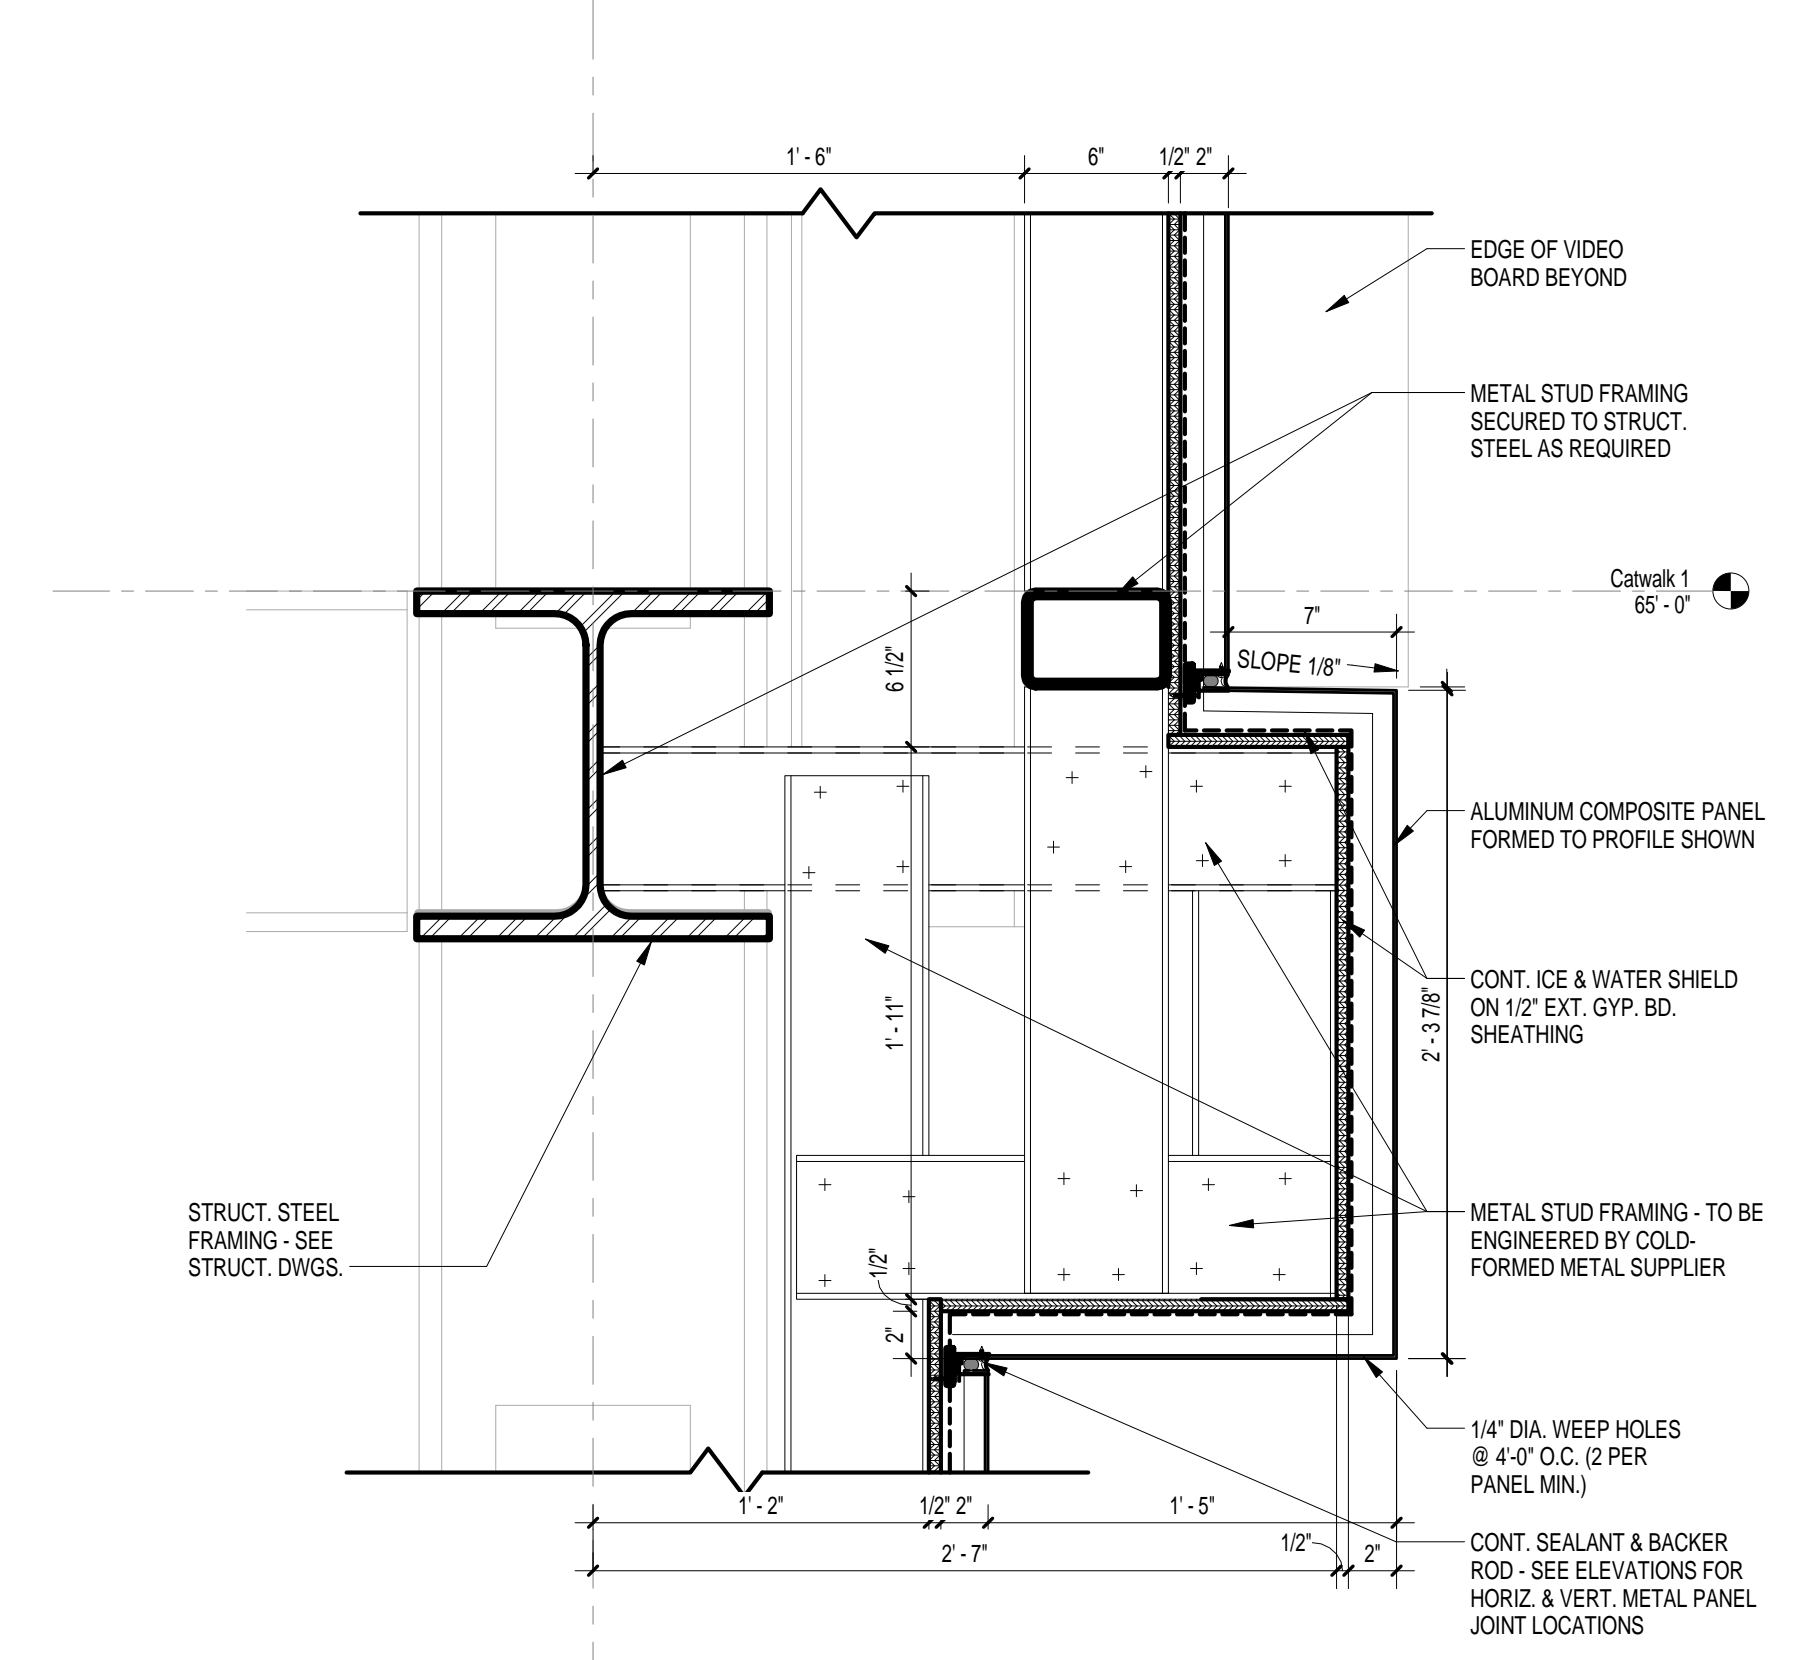


3 SECTION DETAIL
 A5.3 1 1/2" = 1'-0" REFERENCED ON: A5.2

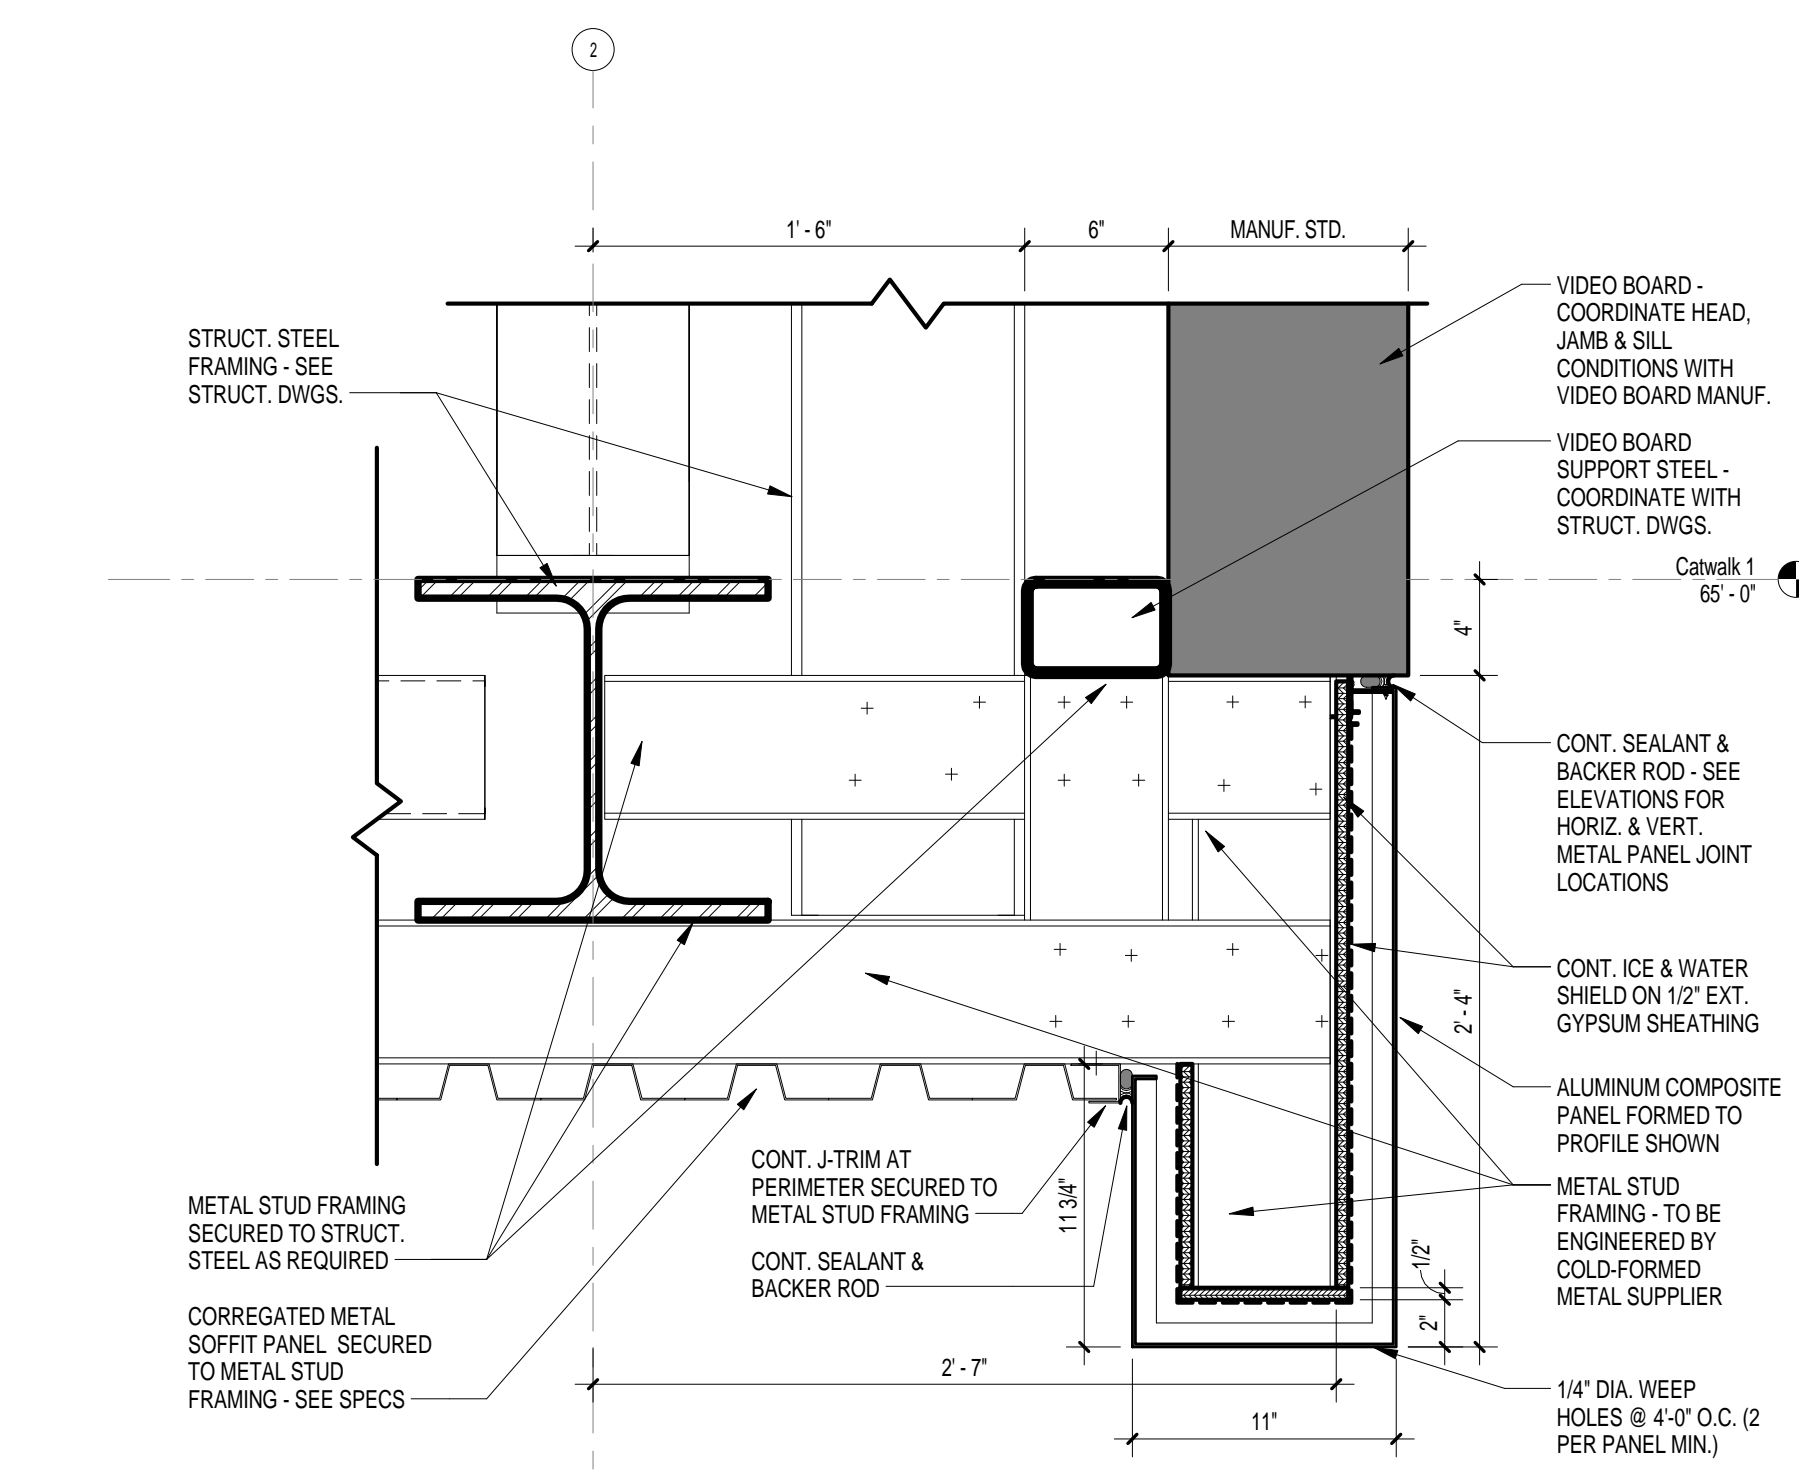


5 SECTION DETAIL
 A5.3 1 1/2" = 1'-0" REFERENCED ON: A5.2

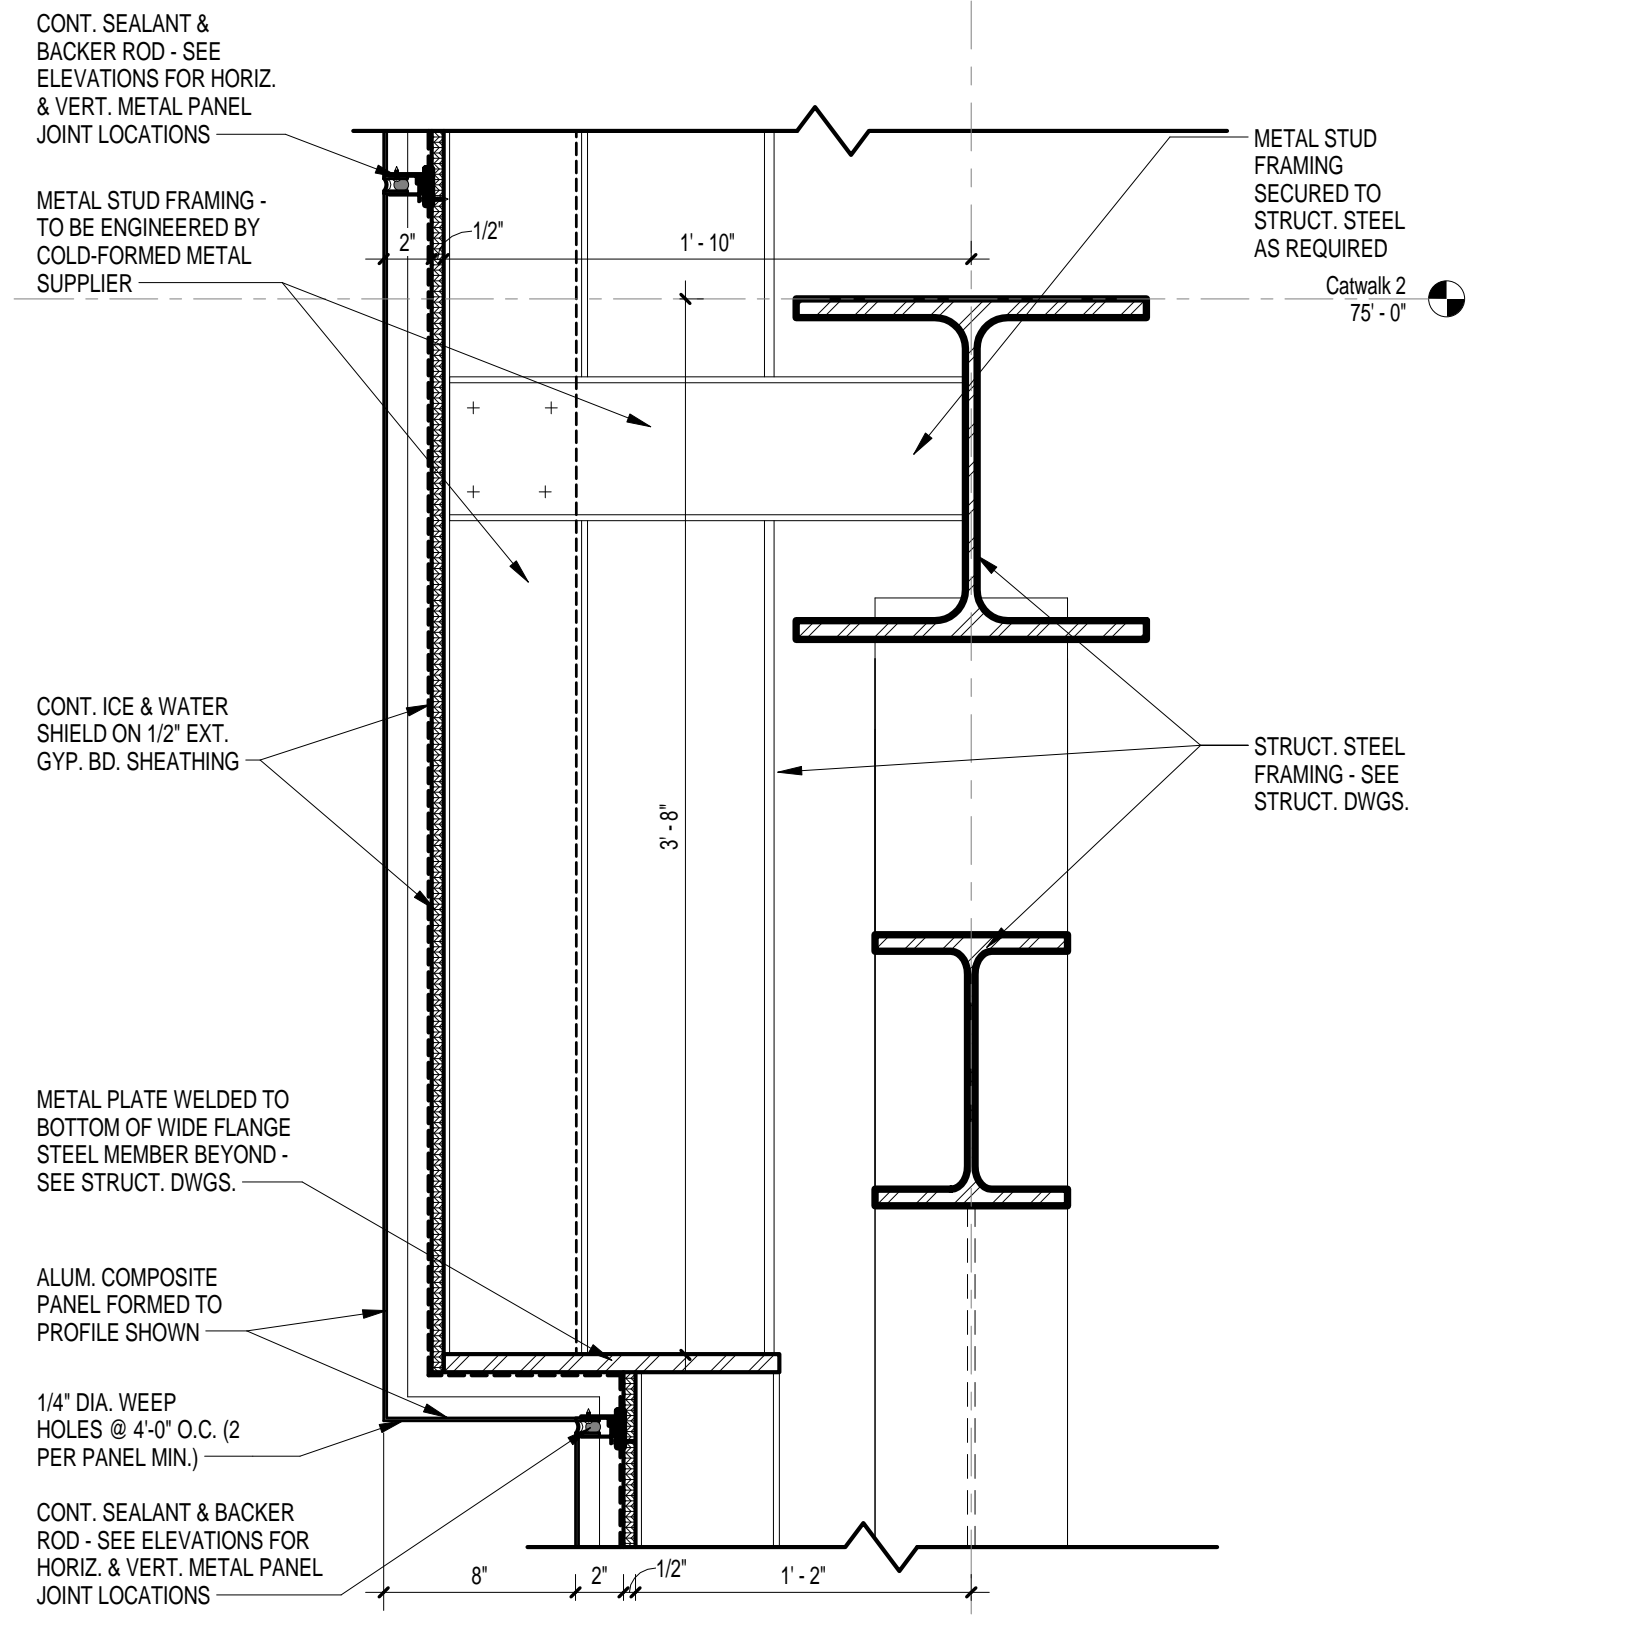


3 SECTION DETAIL
 A5.4 1 1/2" = 1'-0" REFERENCED ON: A5.3

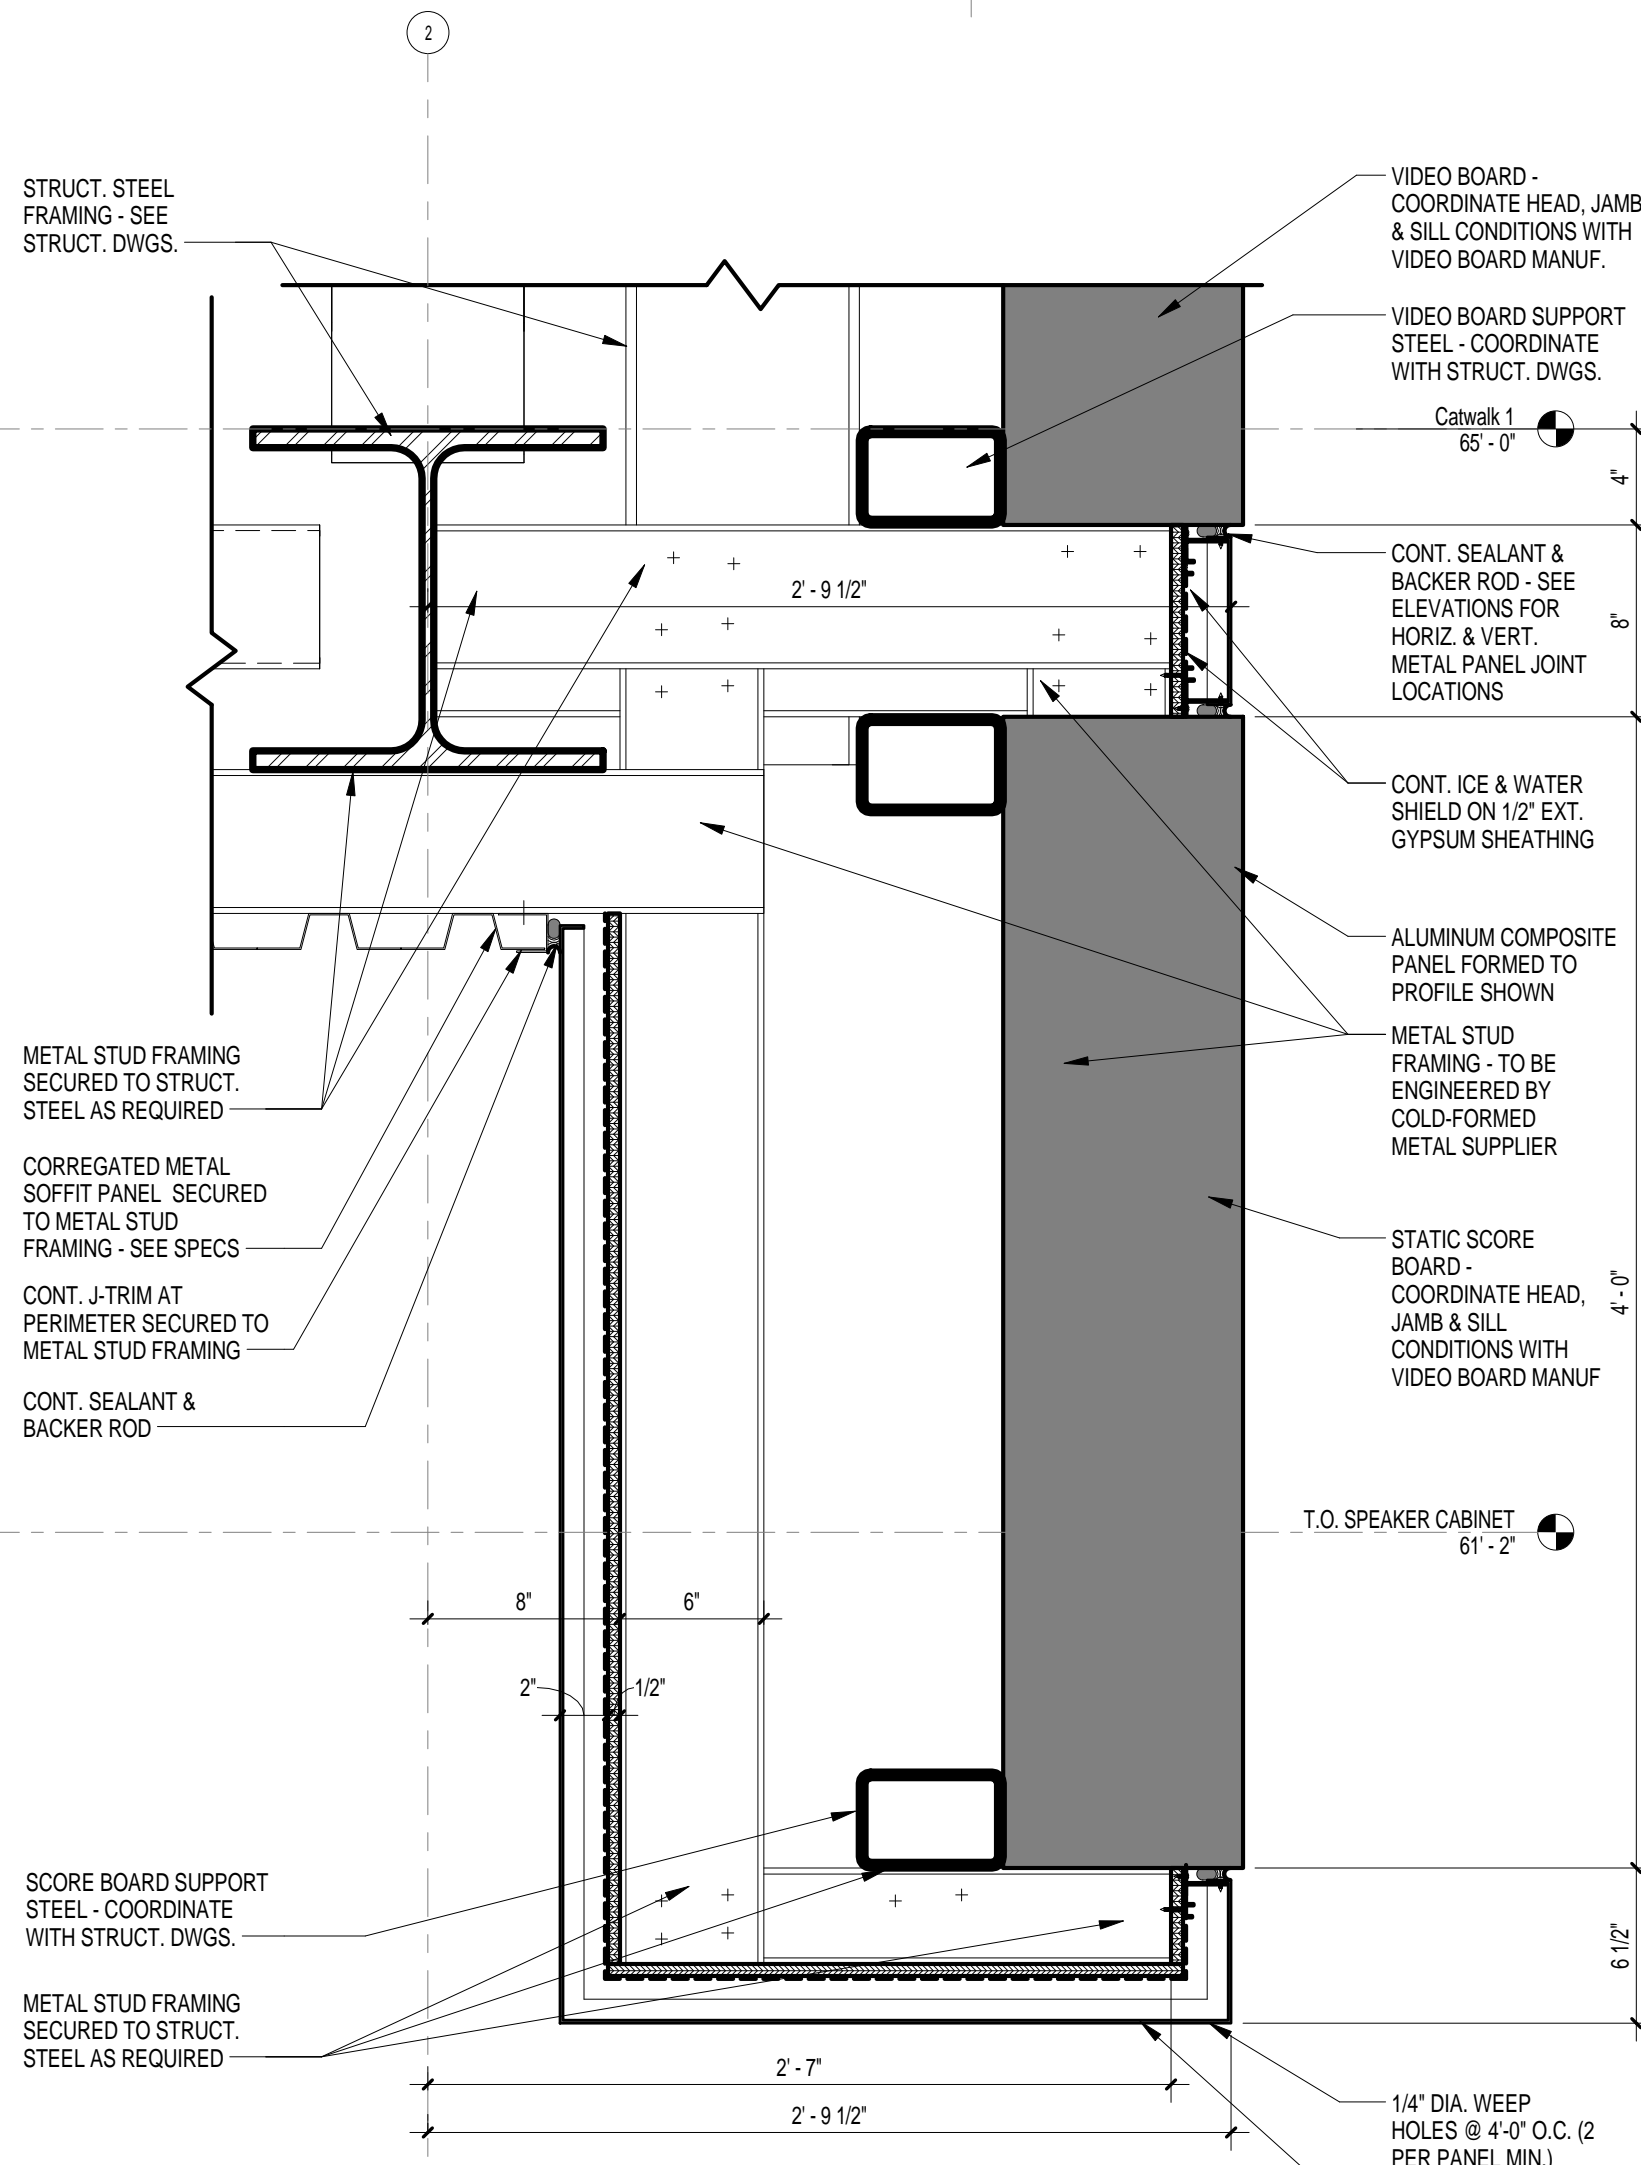

4 SECTION DETAIL
 A5.4 1 1/2" = 1'-0" REFERENCED ON: A5.3

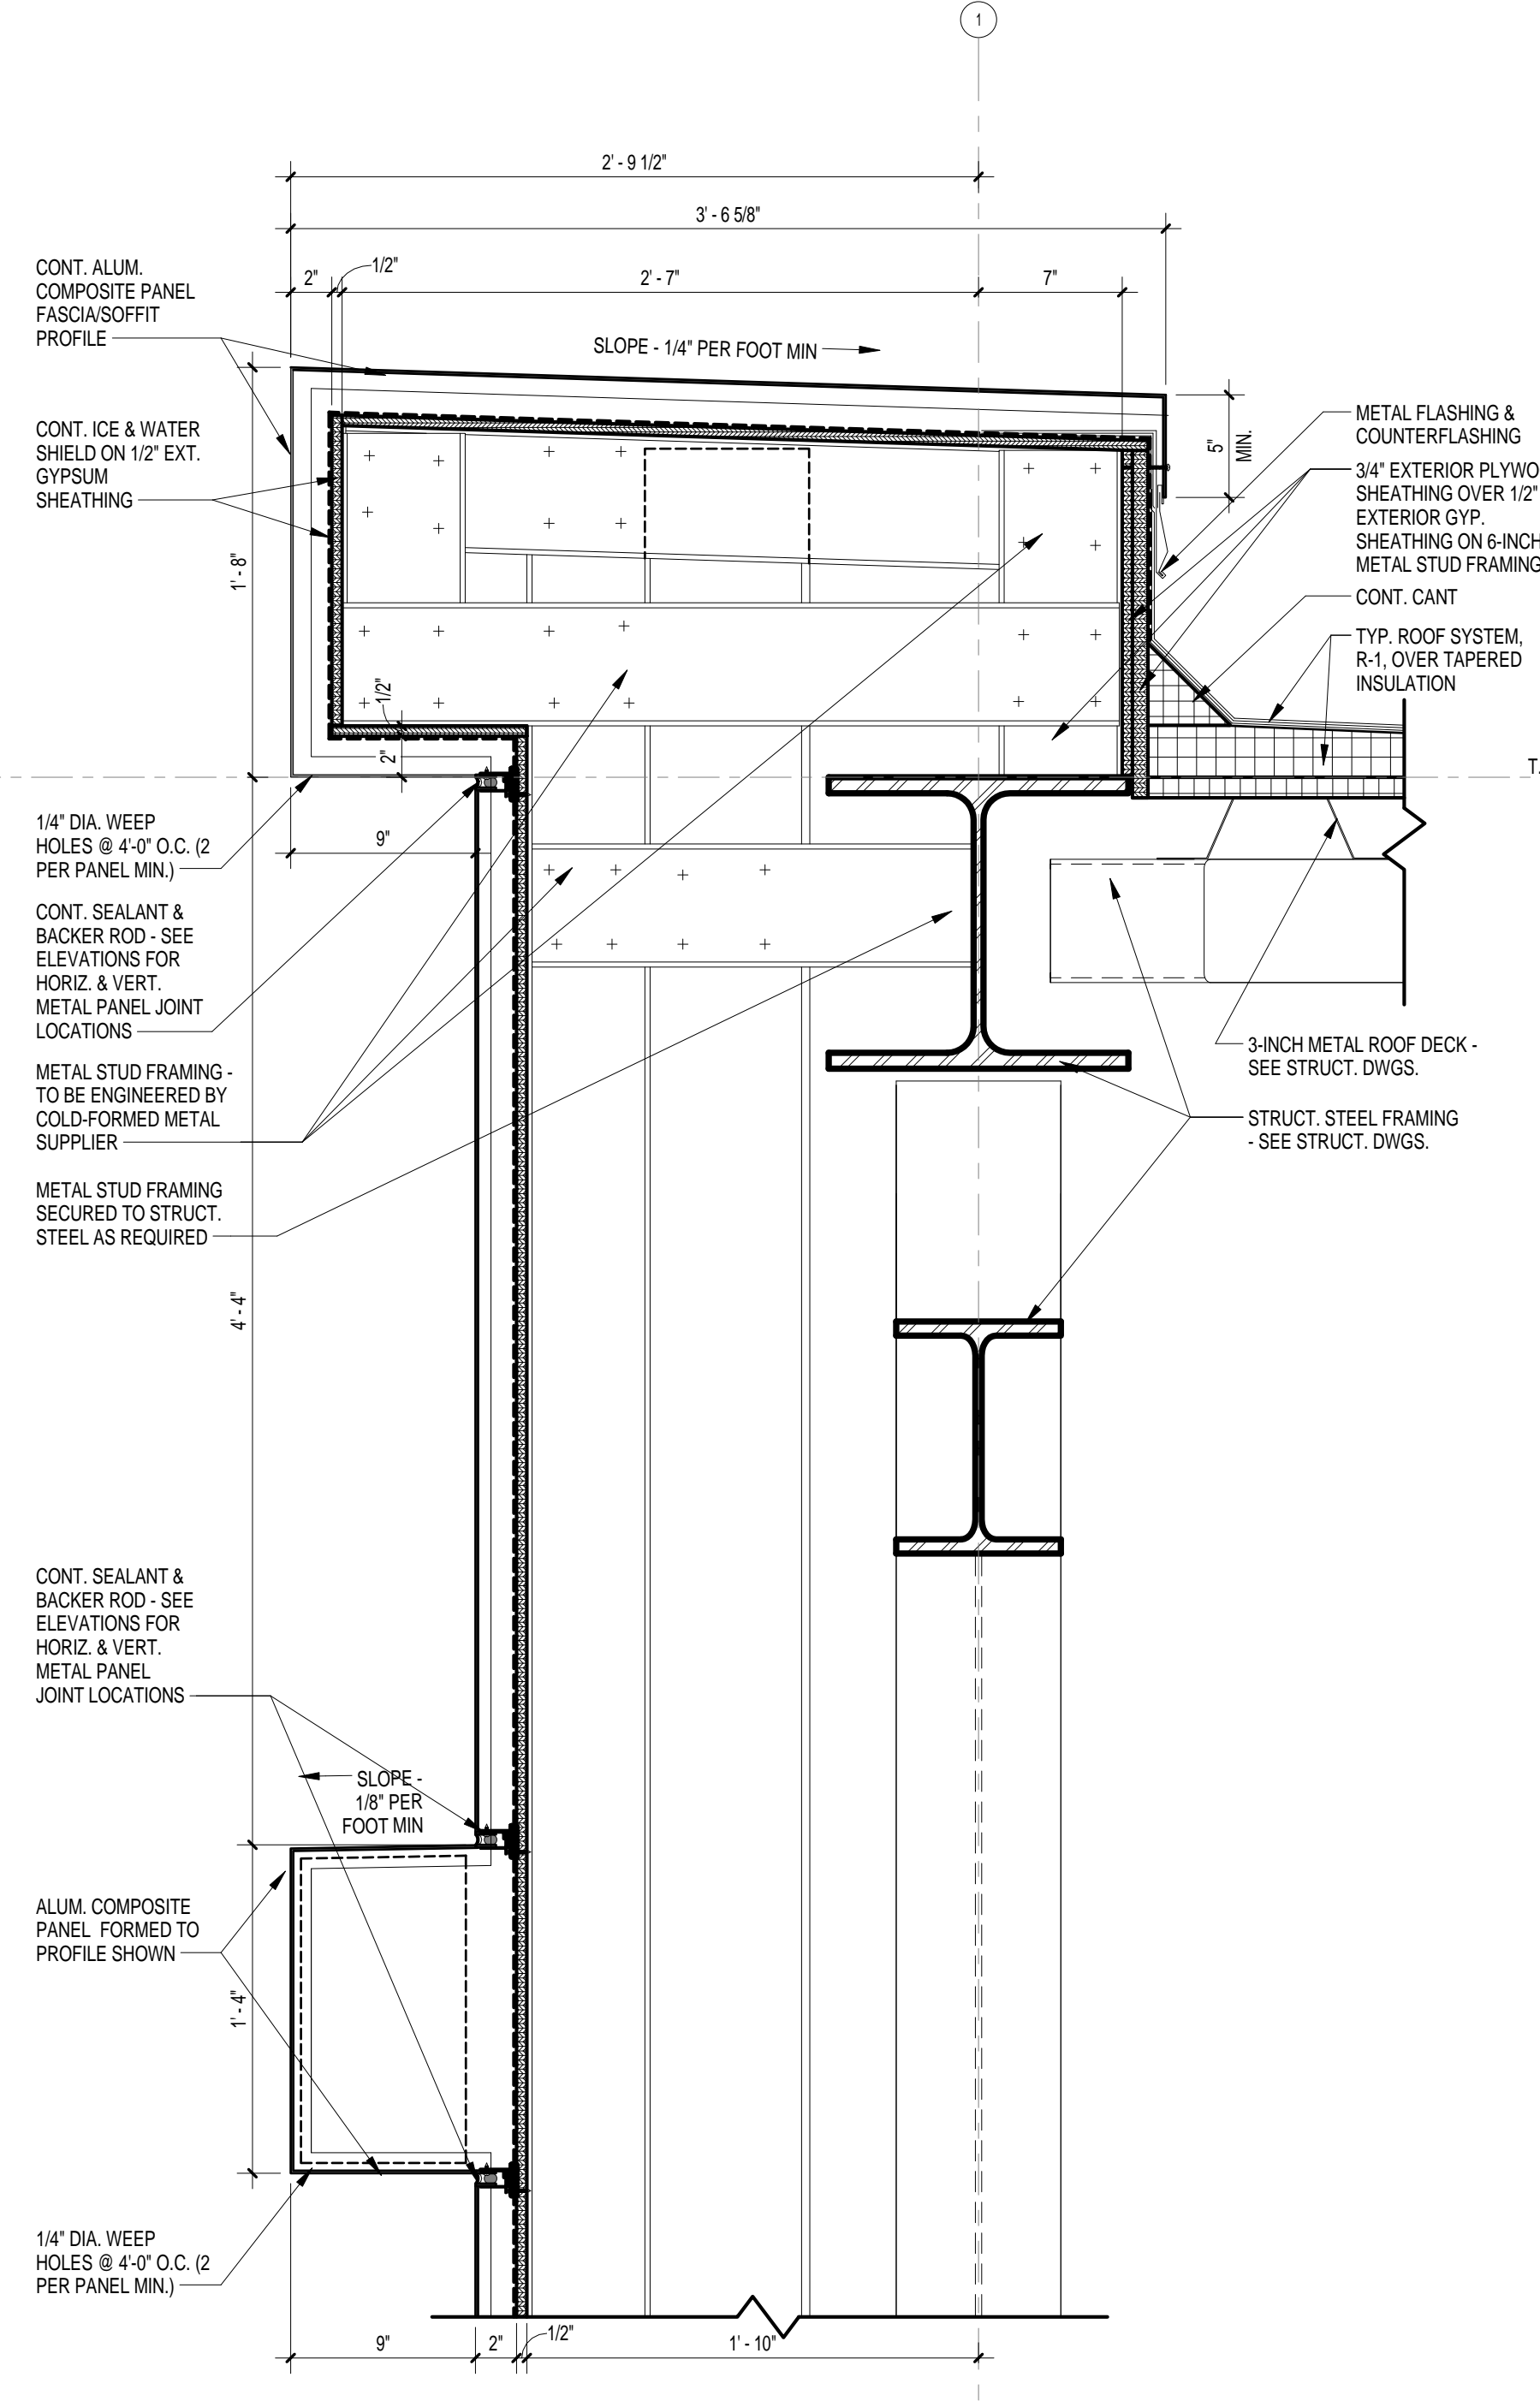

2 SECTION DETAIL
 A5.4 1 1/2" = 1'-0" REFERENCED ON: A5.3

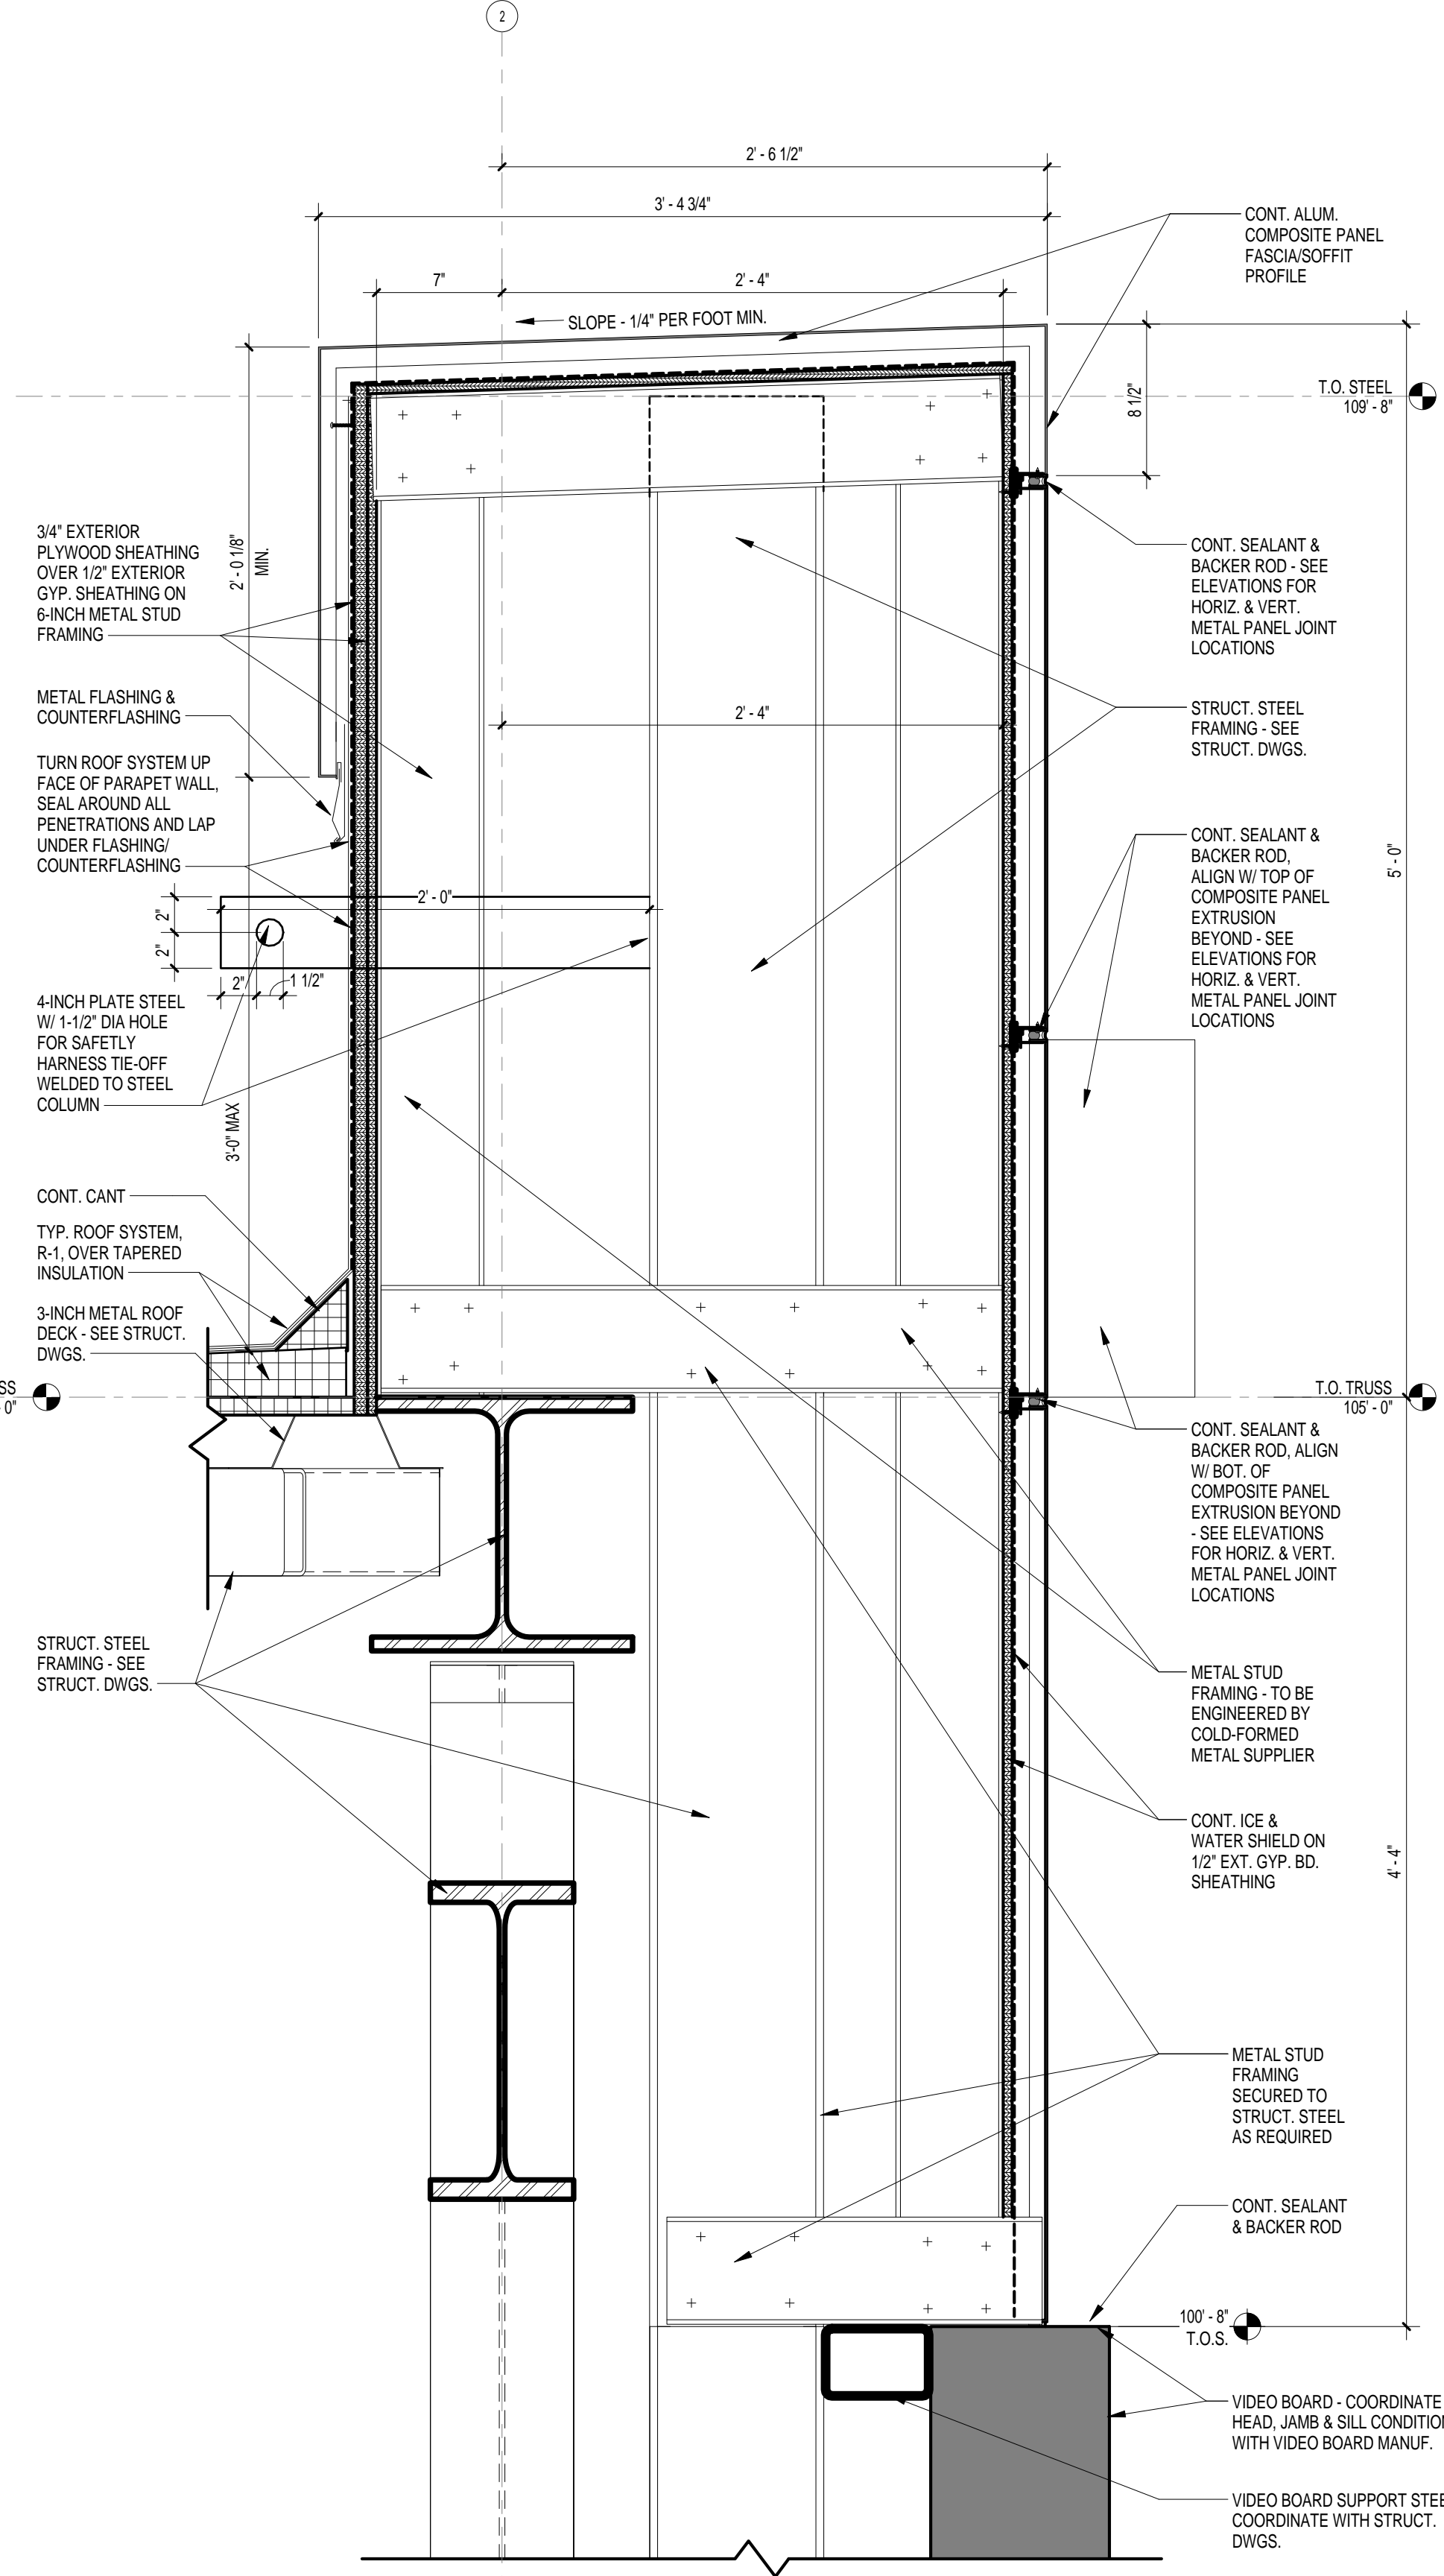


1 SECTION DETAIL
 A5.4 1 1/2" = 1'-0" REFERENCED ON: A5.2

NO.	REVISIONS	NAME	DATE


DRAWN BY: Author
CHKD BY: Checker
THIS DRAWING AND THE DESIGN THEREON ARE THE PROPERTY OF GARVIN DESIGN GROUP, INC. THE DESIGNER ASSUMES NO LIABILITY FOR ANY ERRORS OR OMISSIONS IN THIS DRAWING OR FOR ANY DAMAGE TO PERSONS OR PROPERTY CAUSED BY THE USE OF THIS DRAWING. THE USER OF THIS DRAWING SHALL BE RESPONSIBLE FOR OBTAINING ALL NECESSARY PERMITS AND FOR ANY SUBJECT TO LOCAL, STATE, AND FEDERAL LAWS AND REGULATIONS.

DRAWING TITLE
SECTION DETAILS


PROJECT NO. U291.11
DATE 12.30.11
DRAWING NO.
A5.4

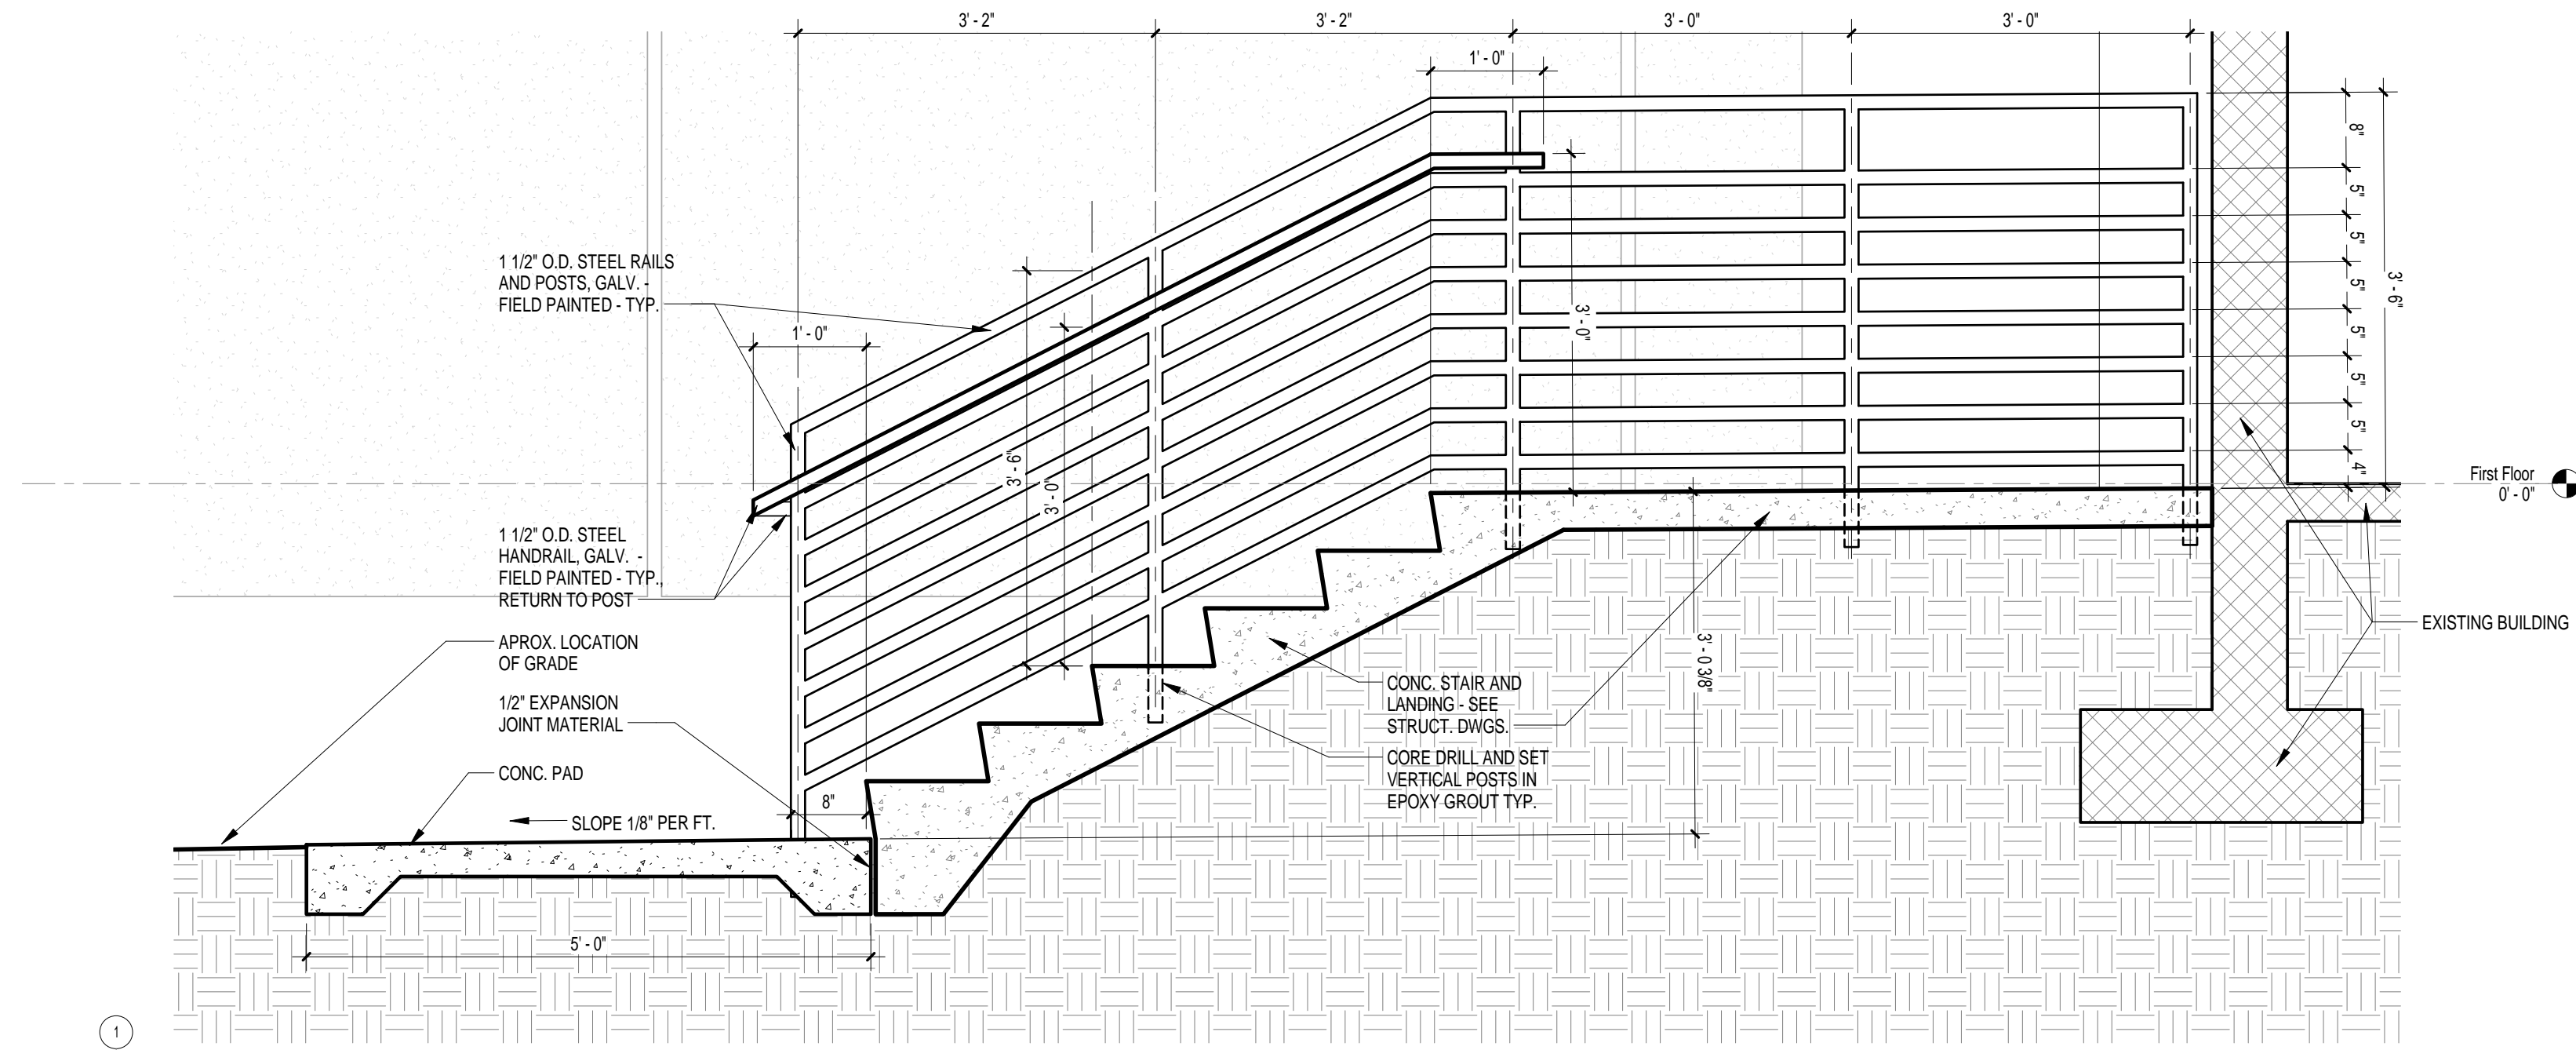


2 STAIR SECTION
A6.1 3/4" = 1'-0" REFERENCED ON: A1.1

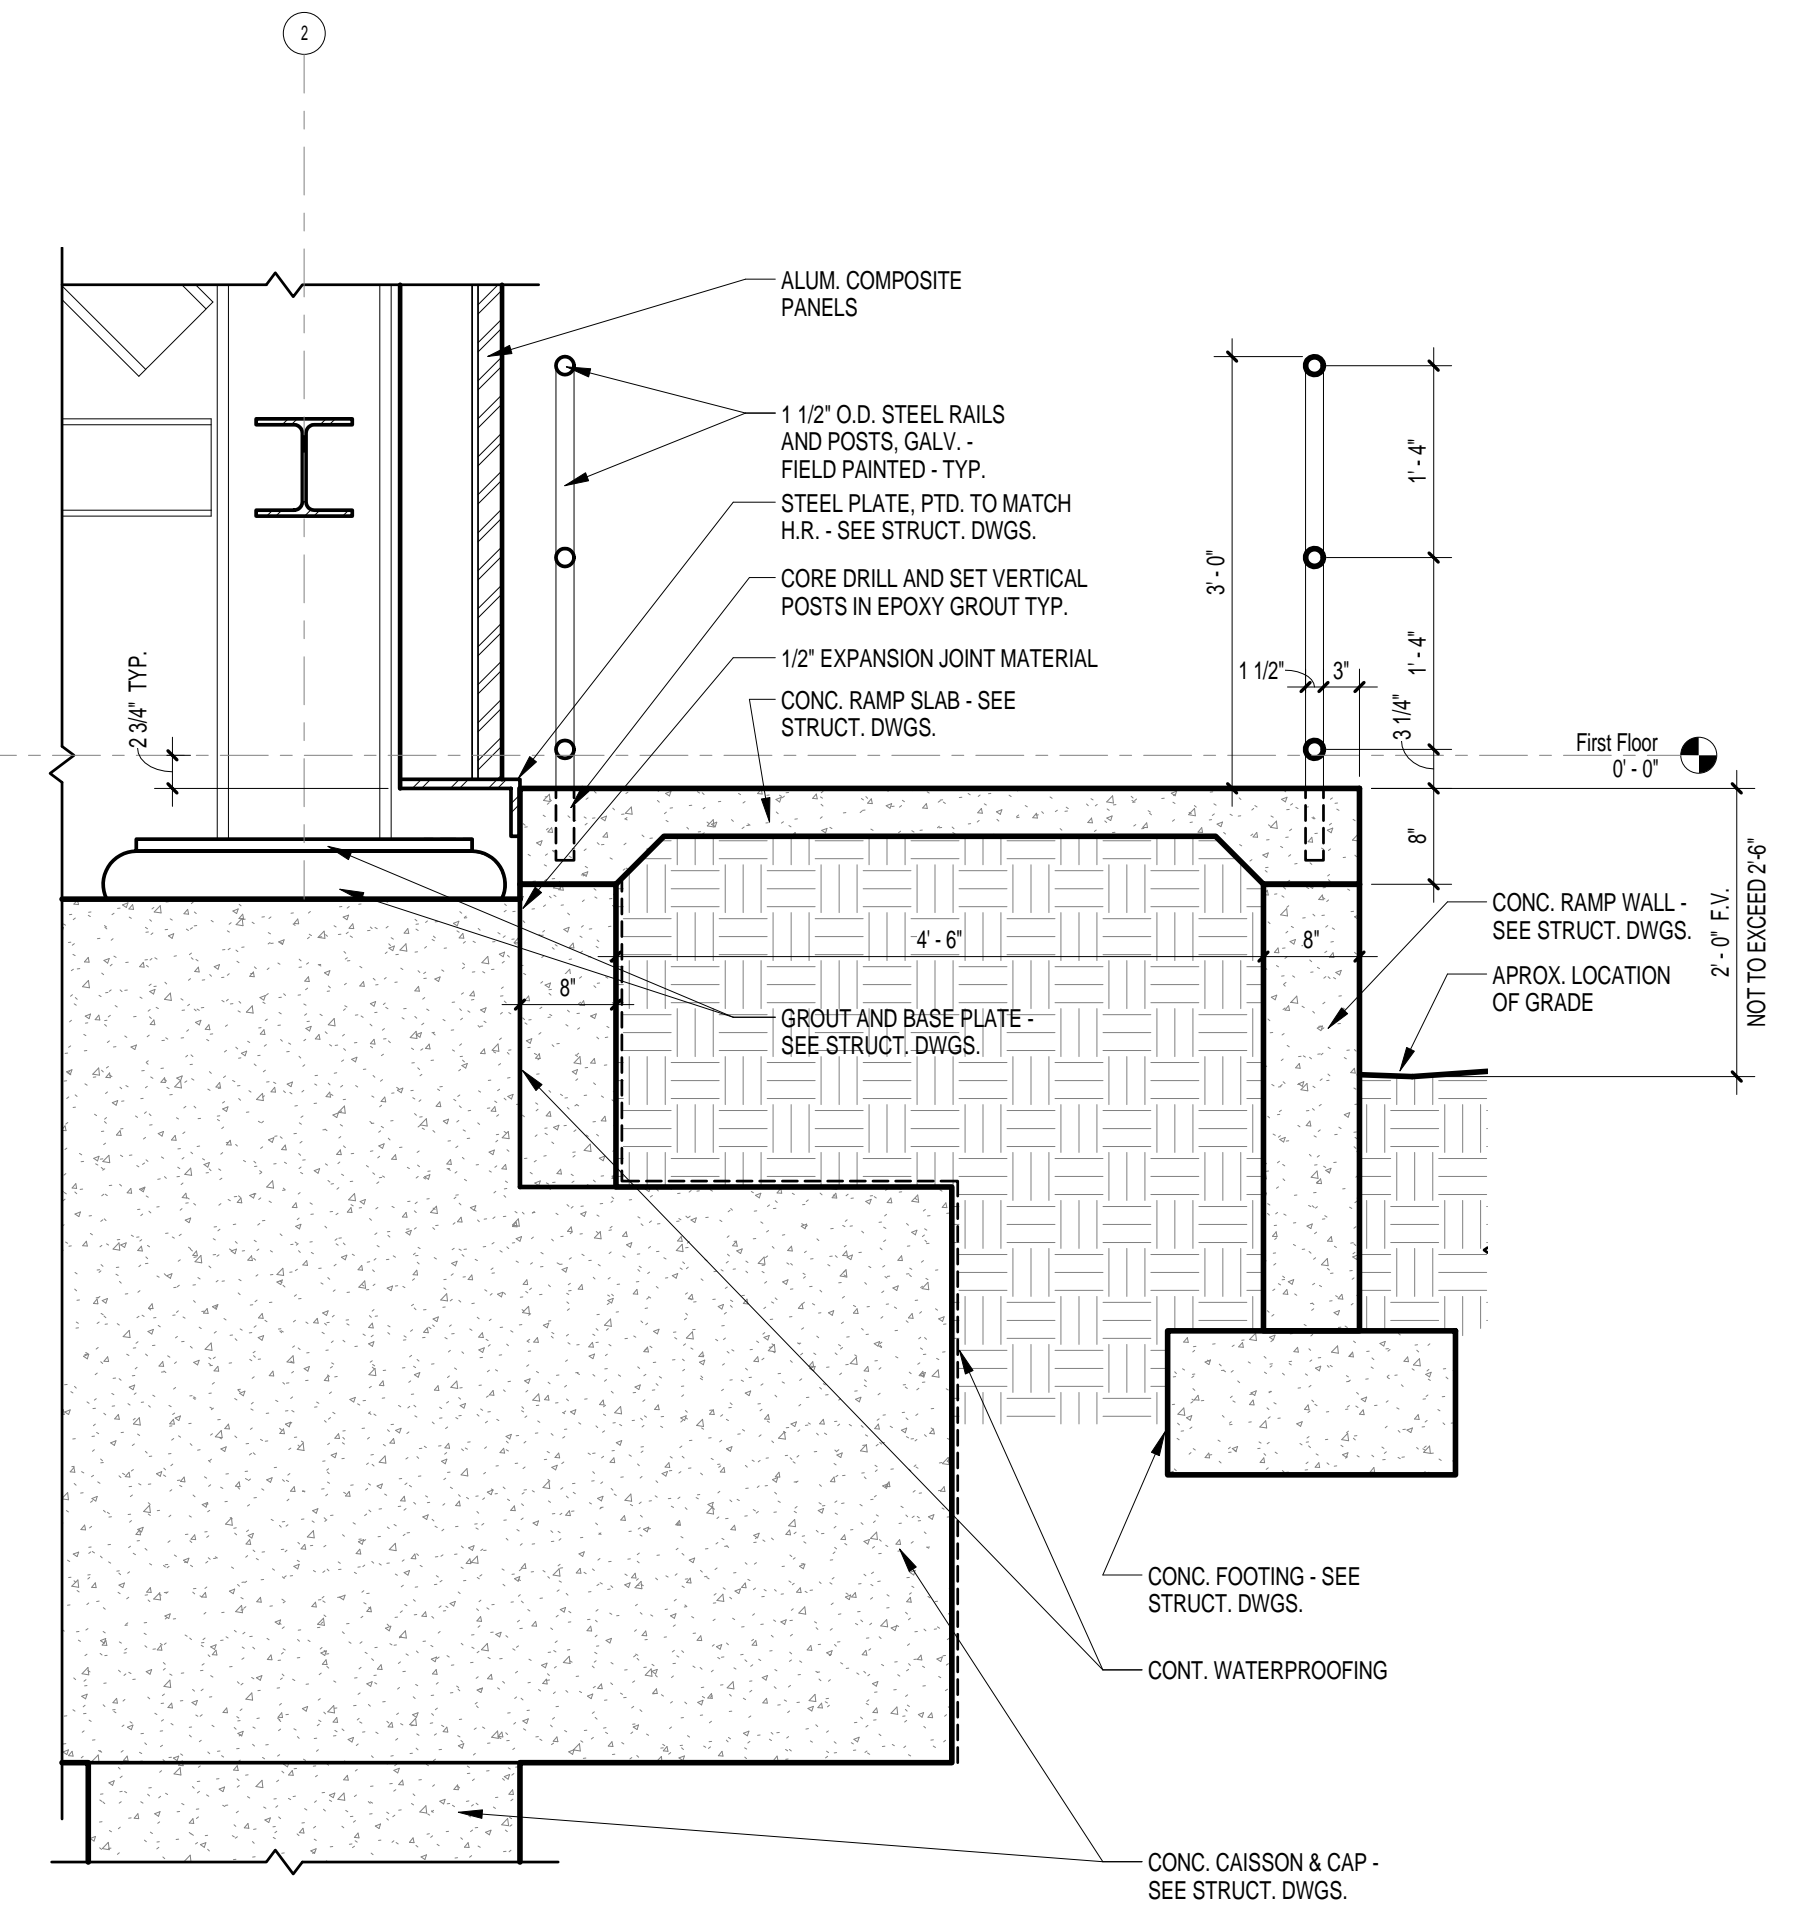


1 RAMP SECTION 1
A6.1 3/4" = 1'-0" REFERENCED ON: A1.1

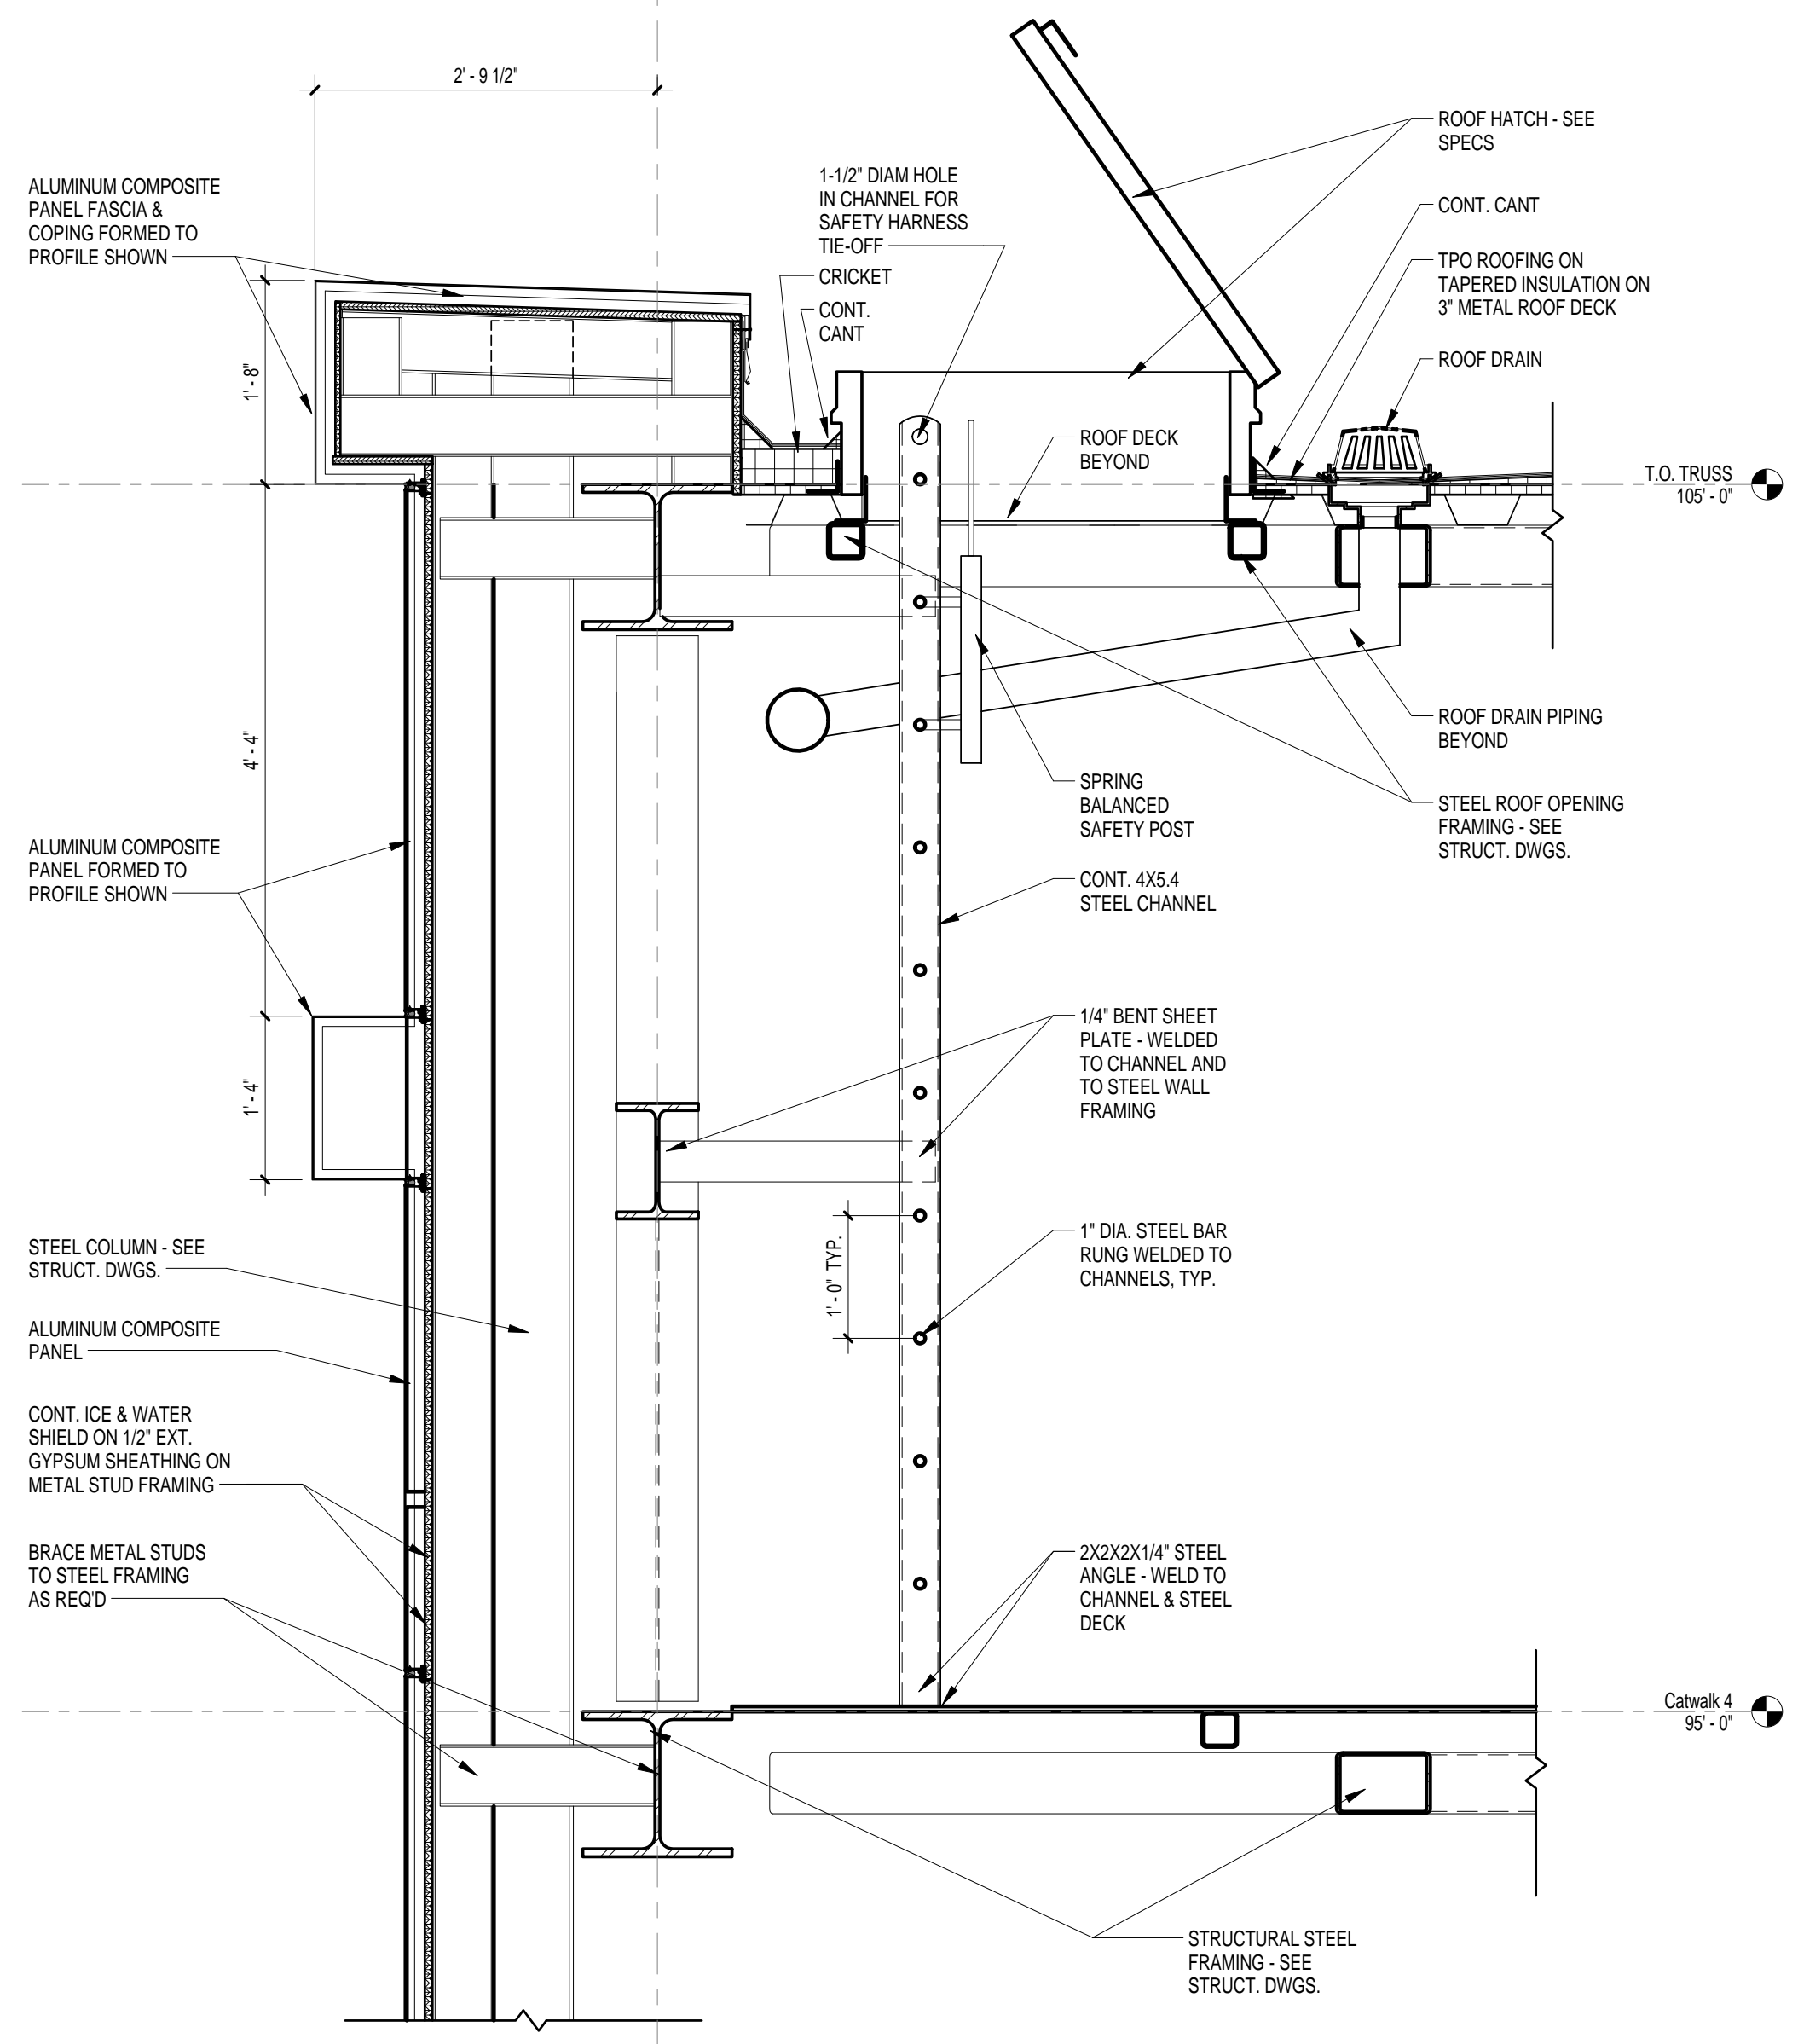


5 ROOF HATCH/ACCESS LADDER SECTION
A6.1 3/4" = 1'-0" REFERENCED ON: A1.2

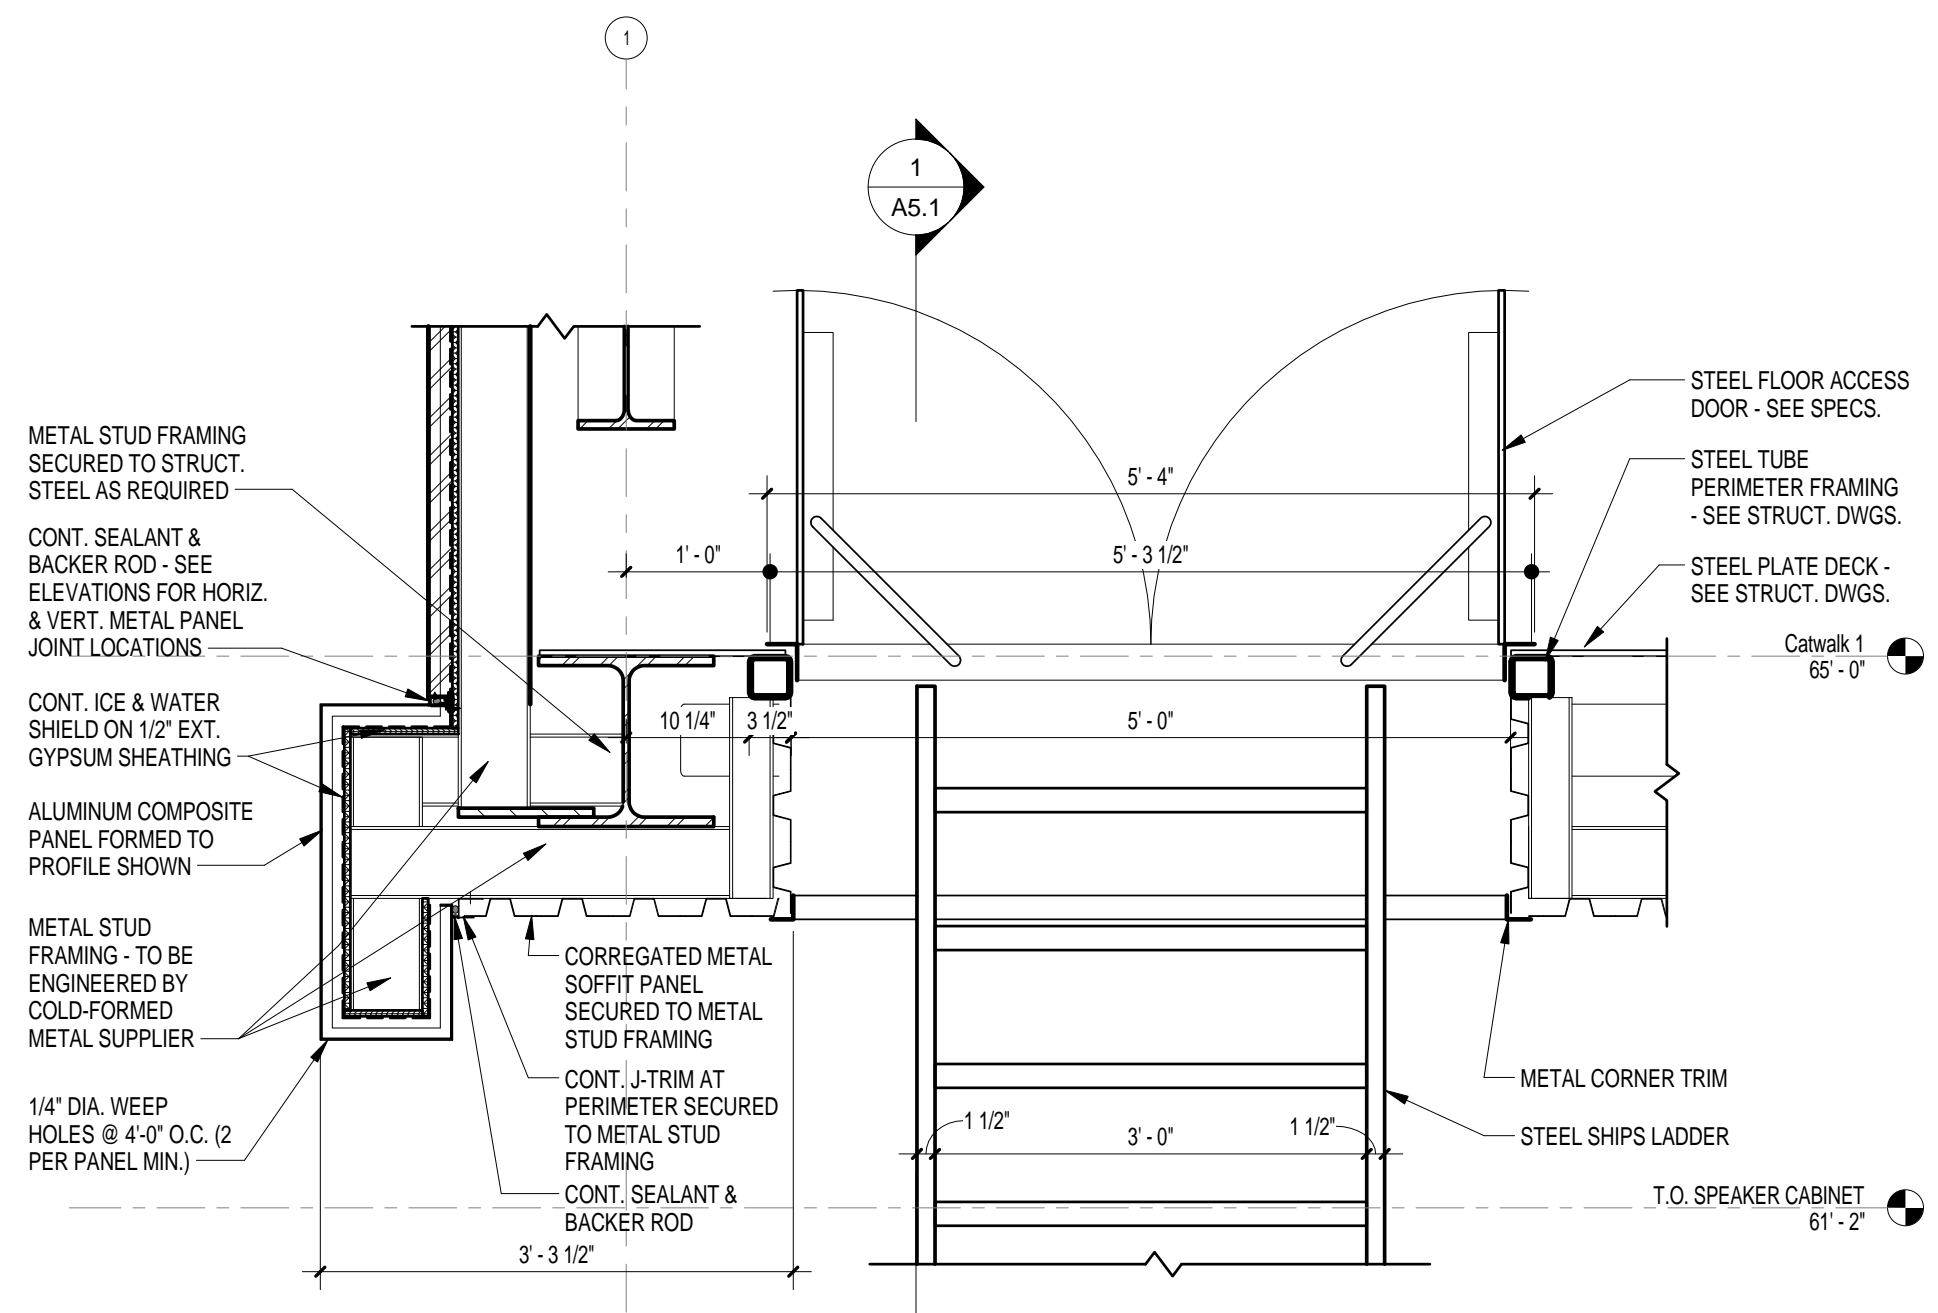

4 FLOOR ACCESS DOOR SECTION
A6.1 3/4" = 1'-0" REFERENCED ON: A1.1

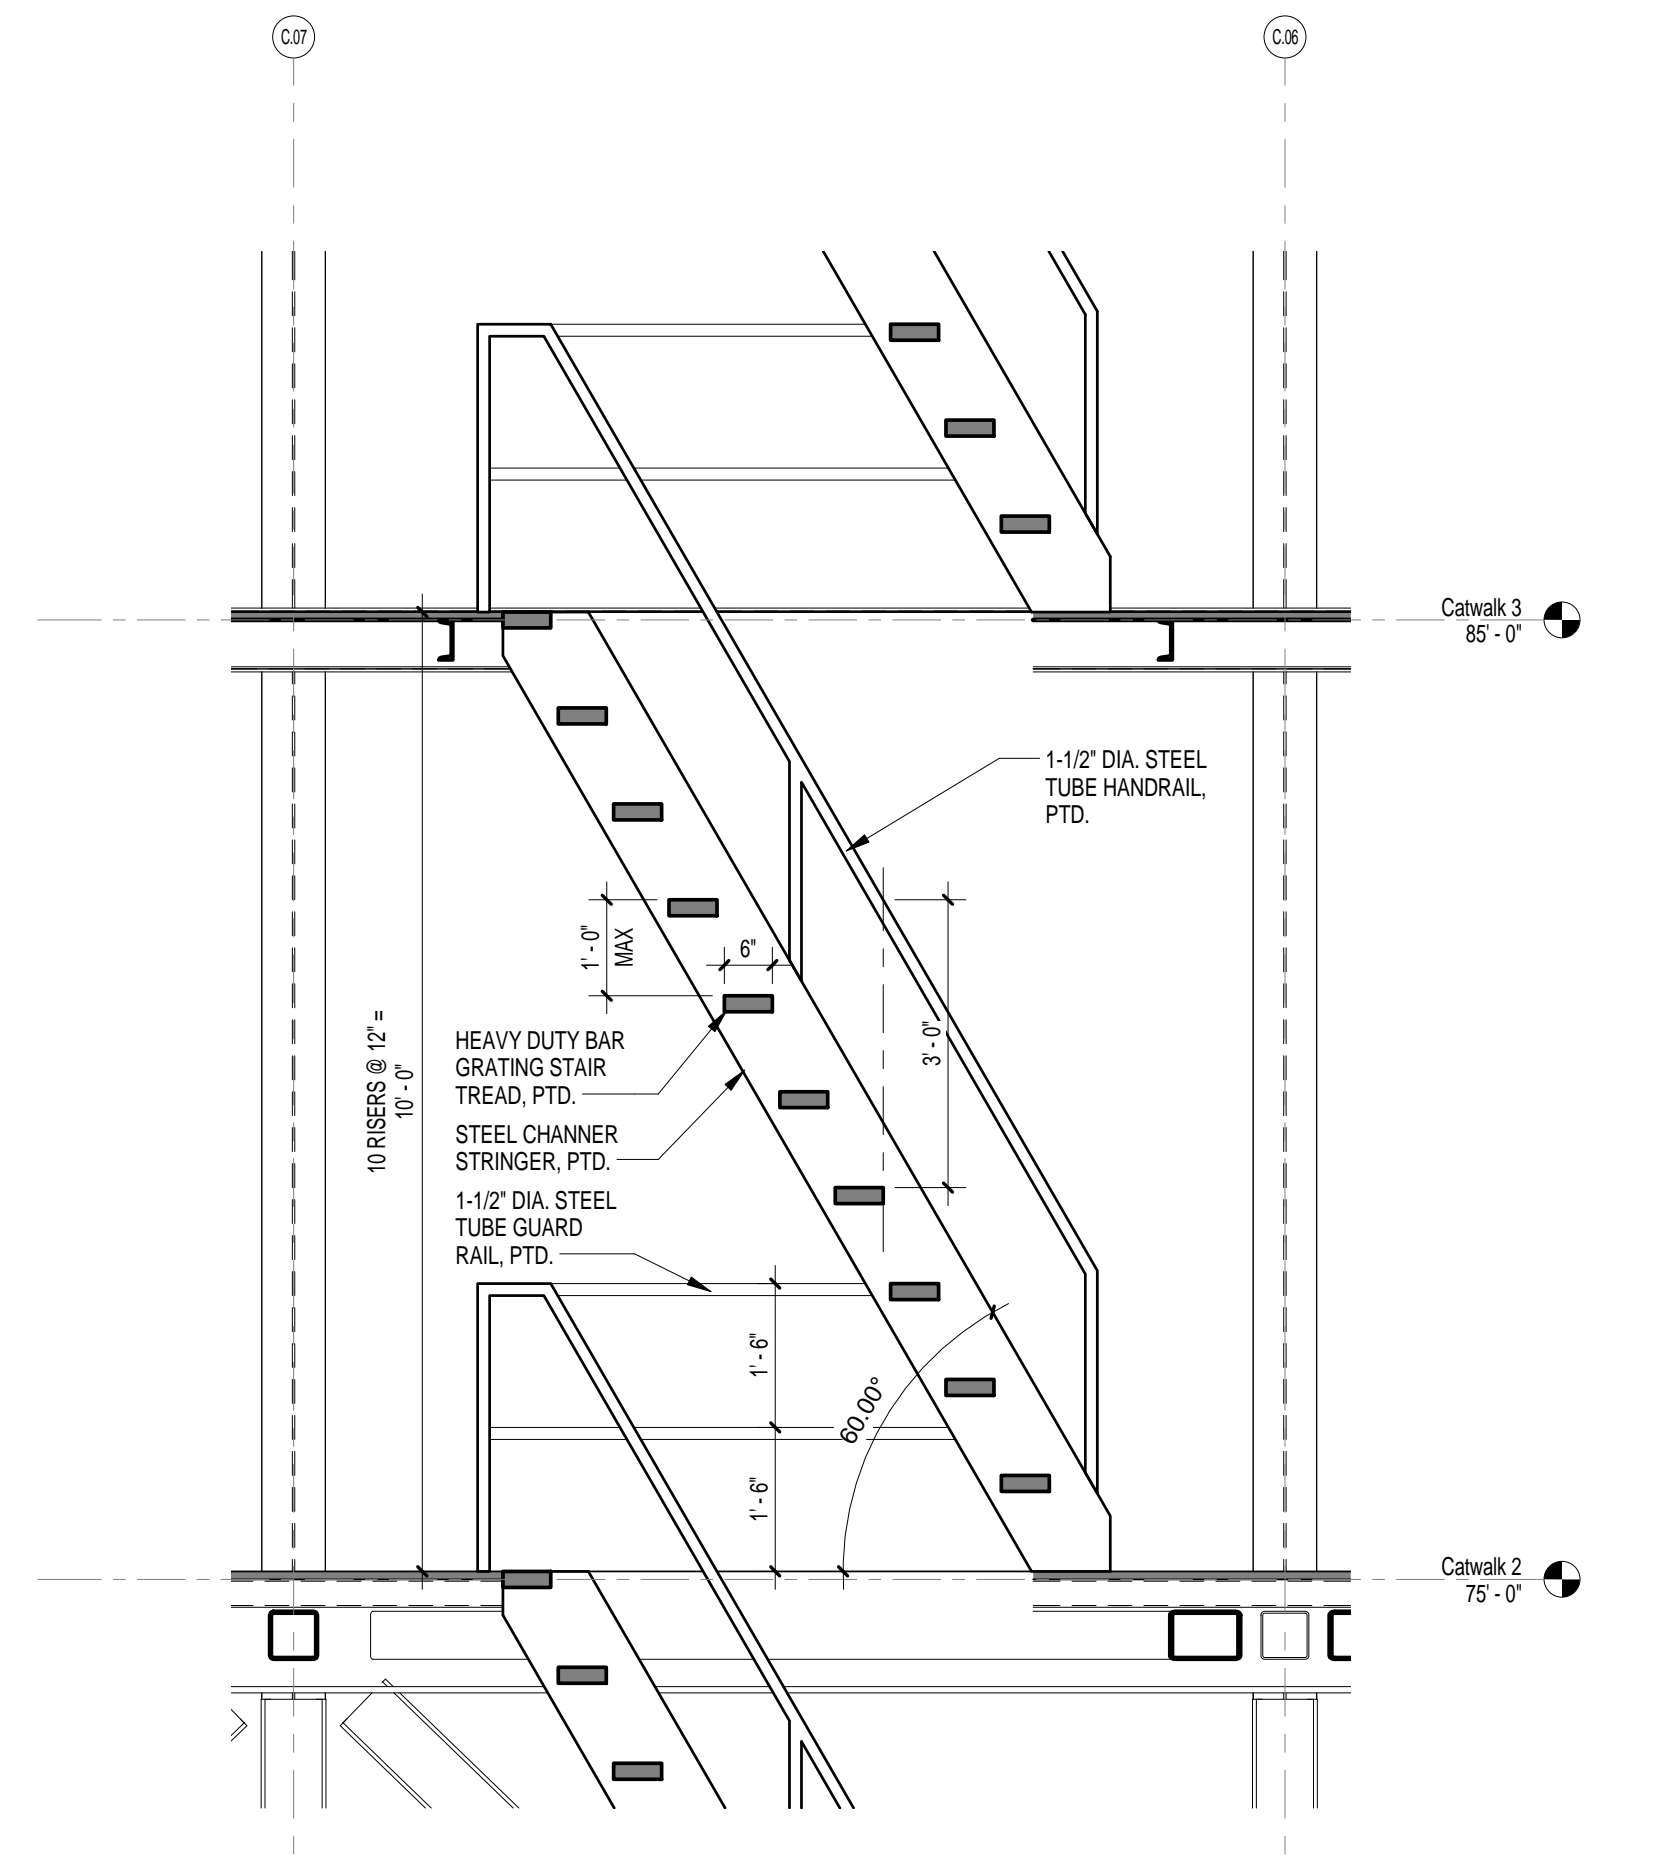


3 SHIPS LADDER SECTION
A6.1 1/2" = 1'-0" REFERENCED ON: A5.1

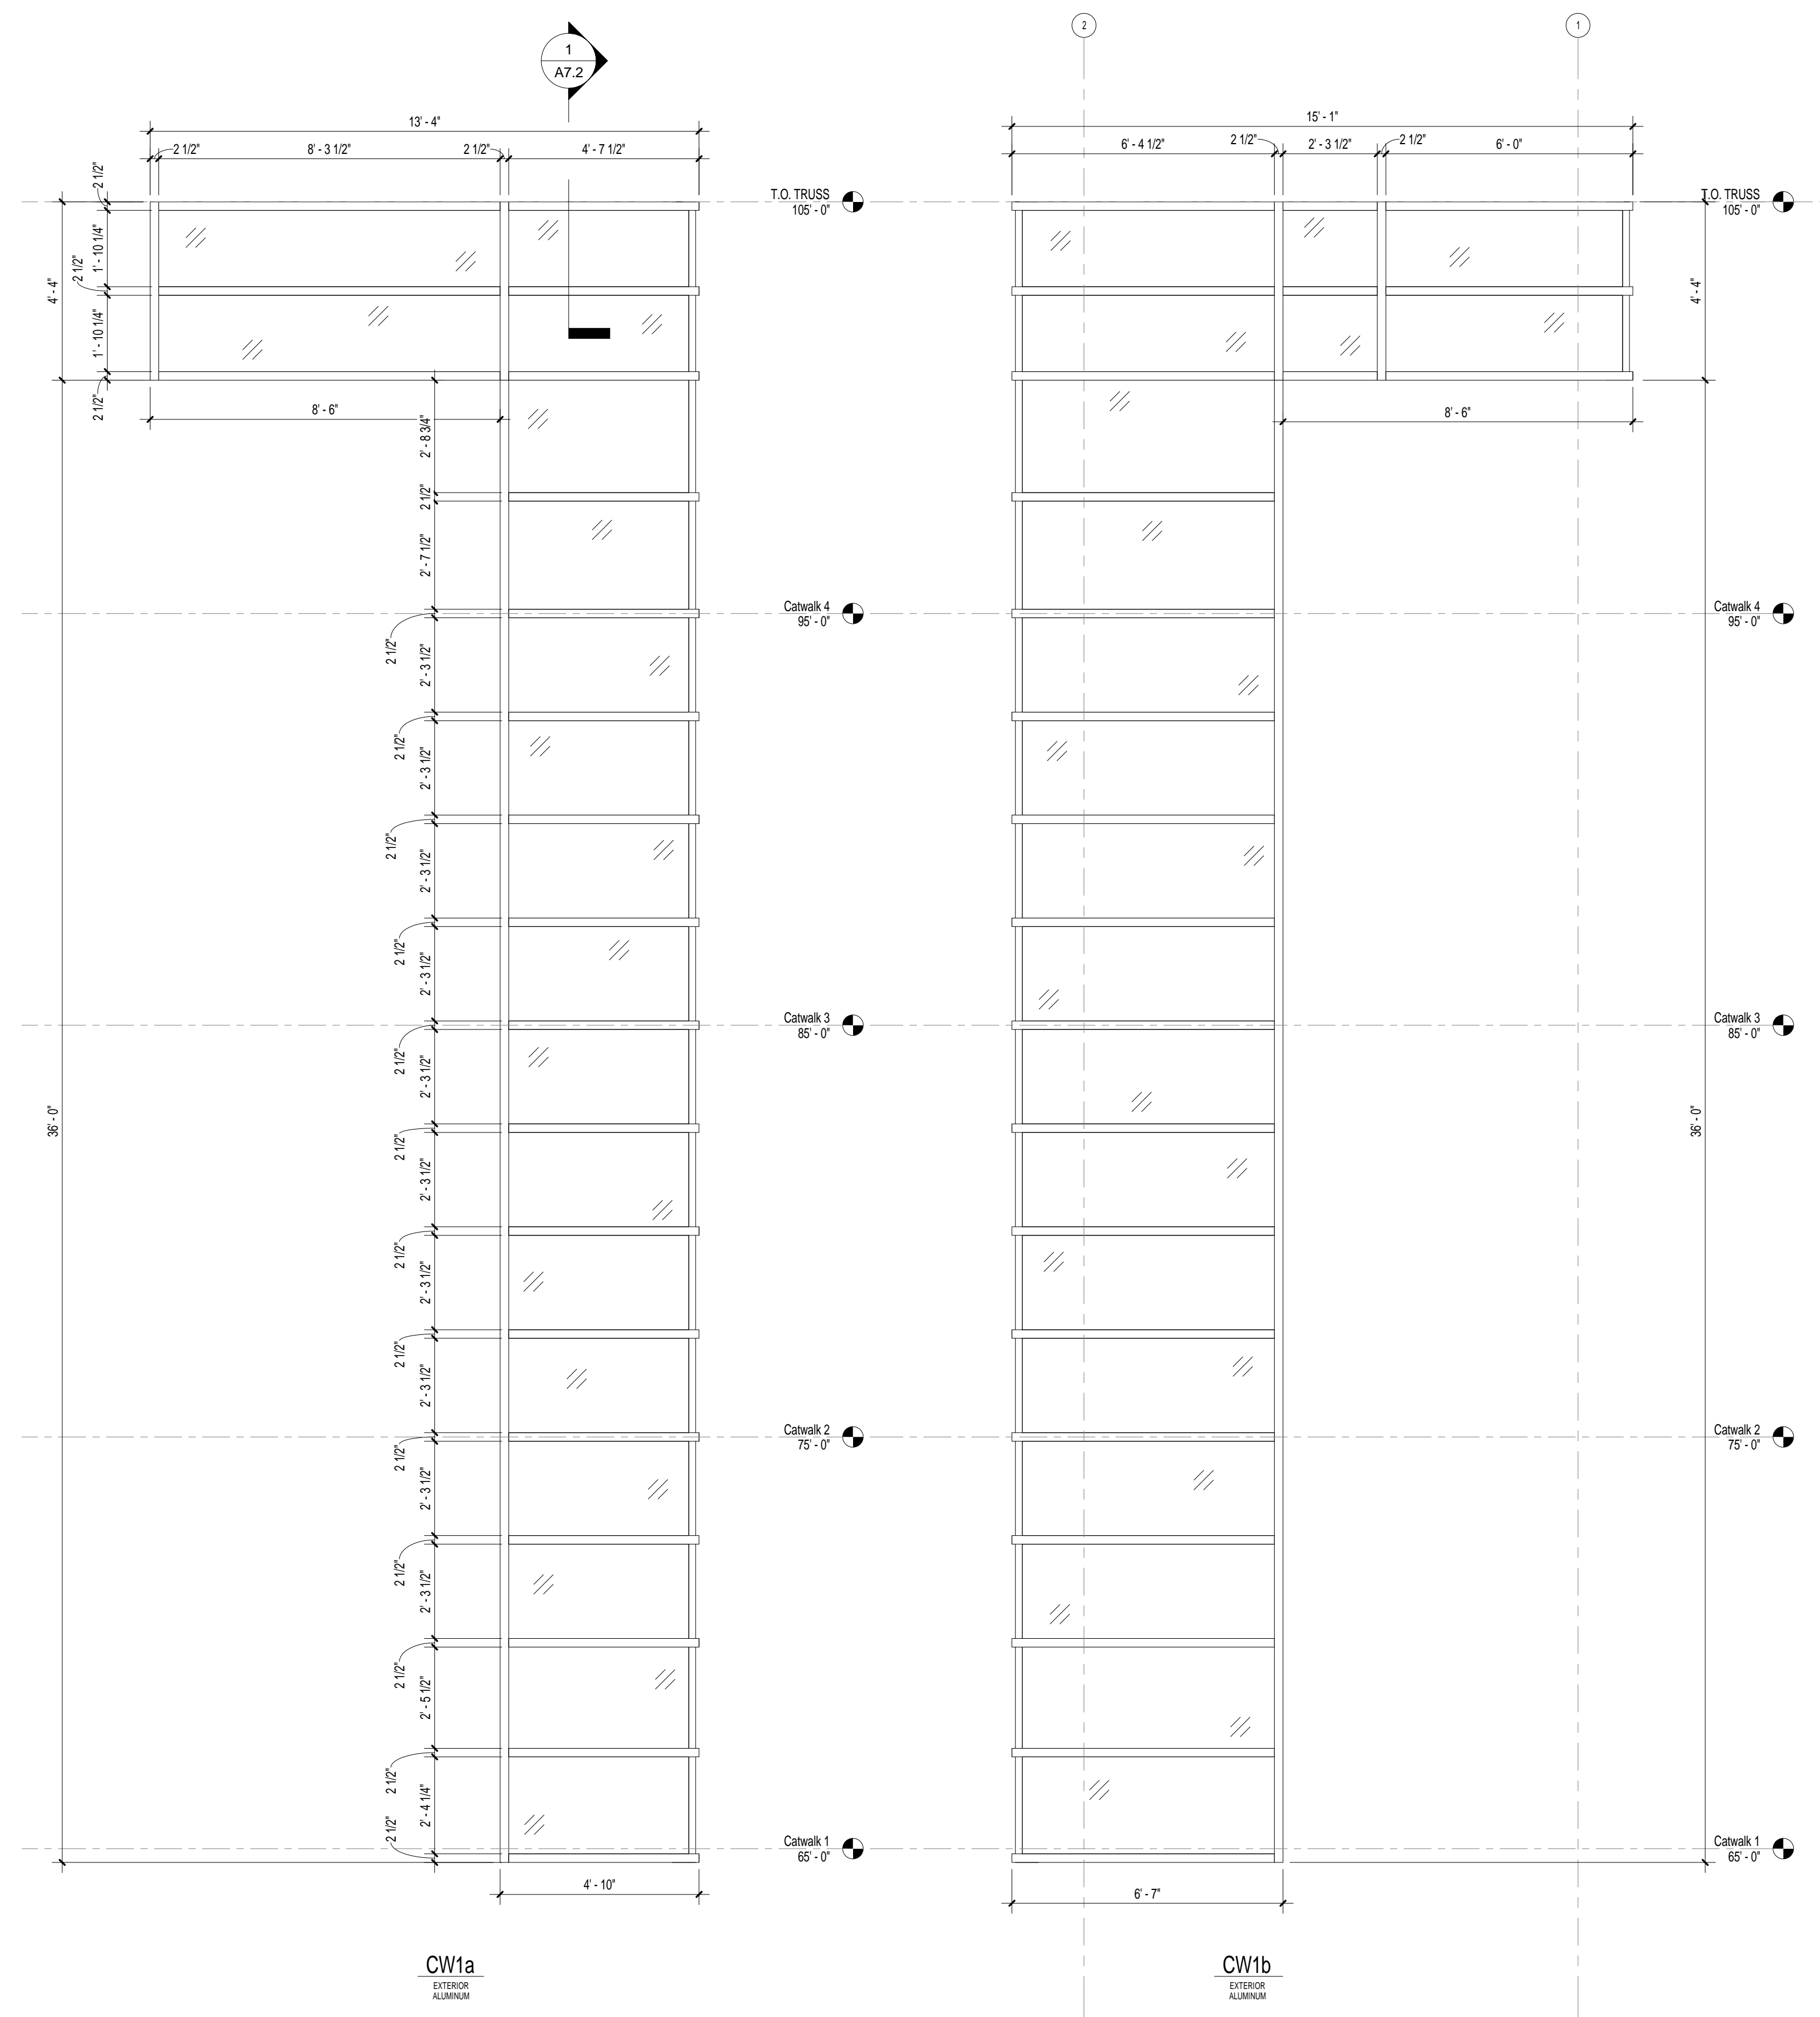


GLAZING SCHEDULE

GLASS TYPE	DESCRIPTION
G1	1/2-INCH THICK, CERAMIC COATING (FROSTED) ON SECOND SURFACE, HEAT-STRENGTHENED FLOAT GLASS, KIND FT (FULLY TEMPERED)


* NOTE: ALL GLASS LITES TO BE G1

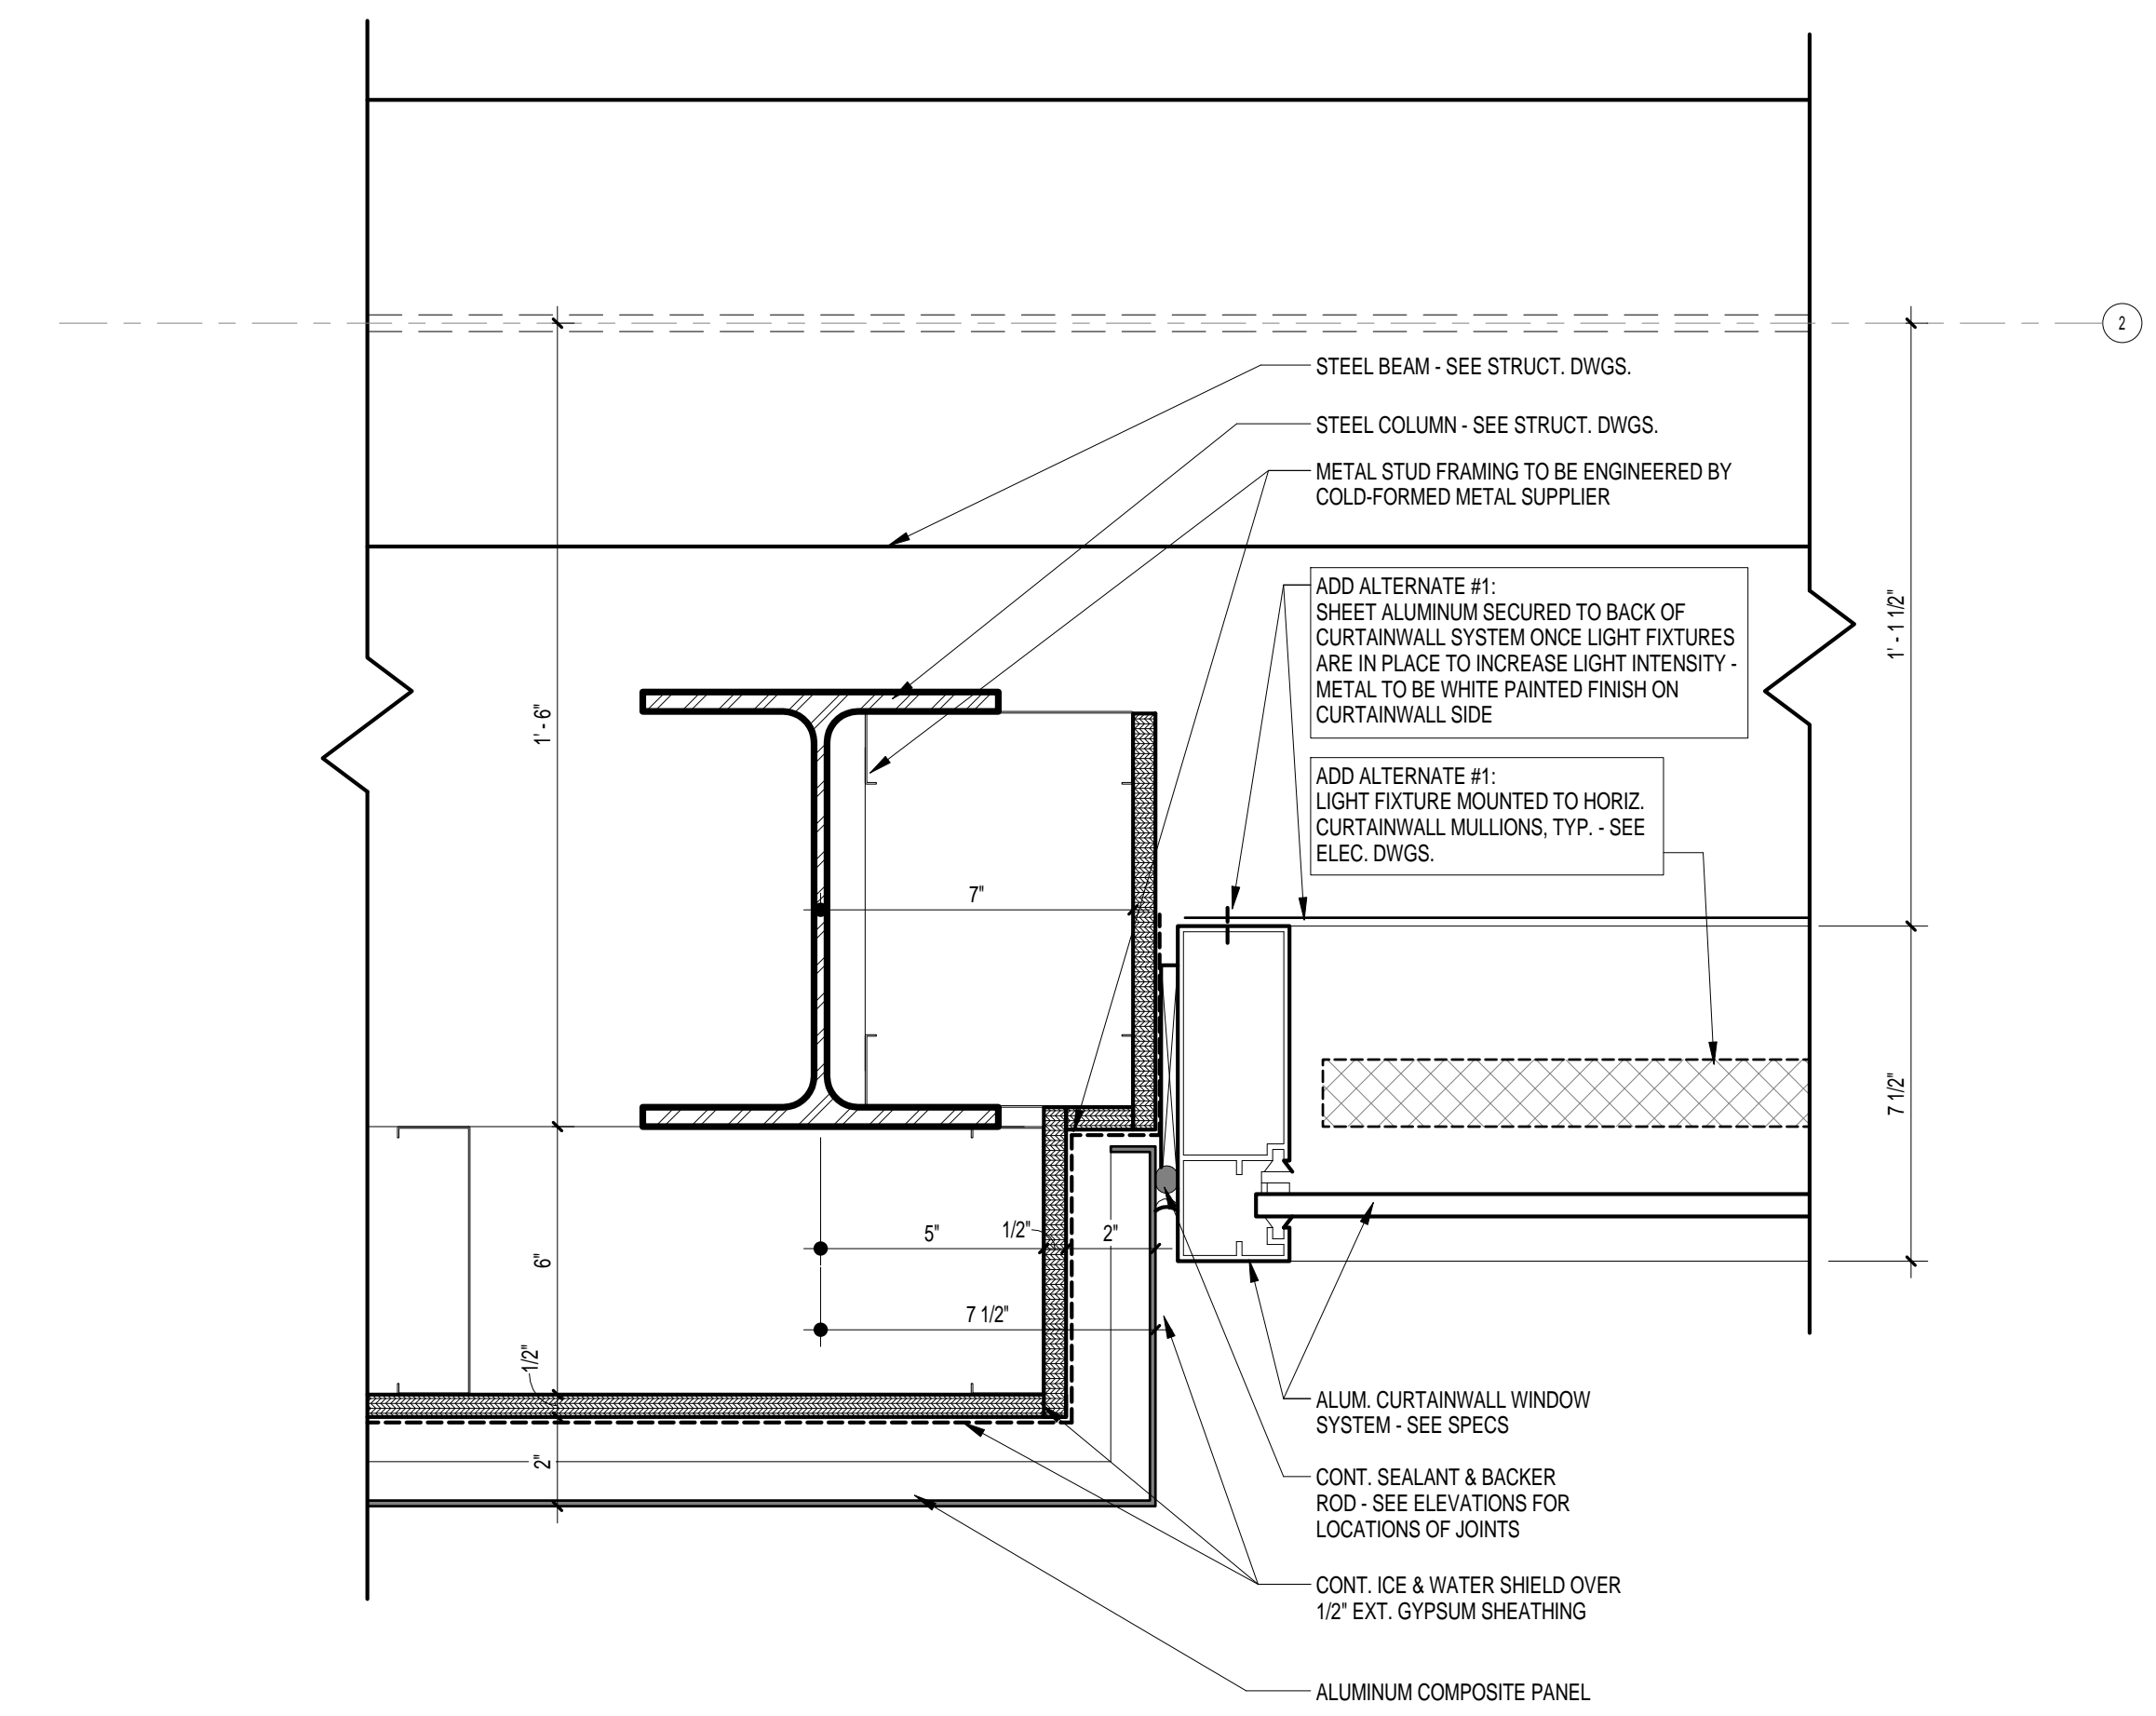


4 JAMB PLAN DETAIL
 A7.1 3" = 1'-0" REFERENCED ON: A3.1

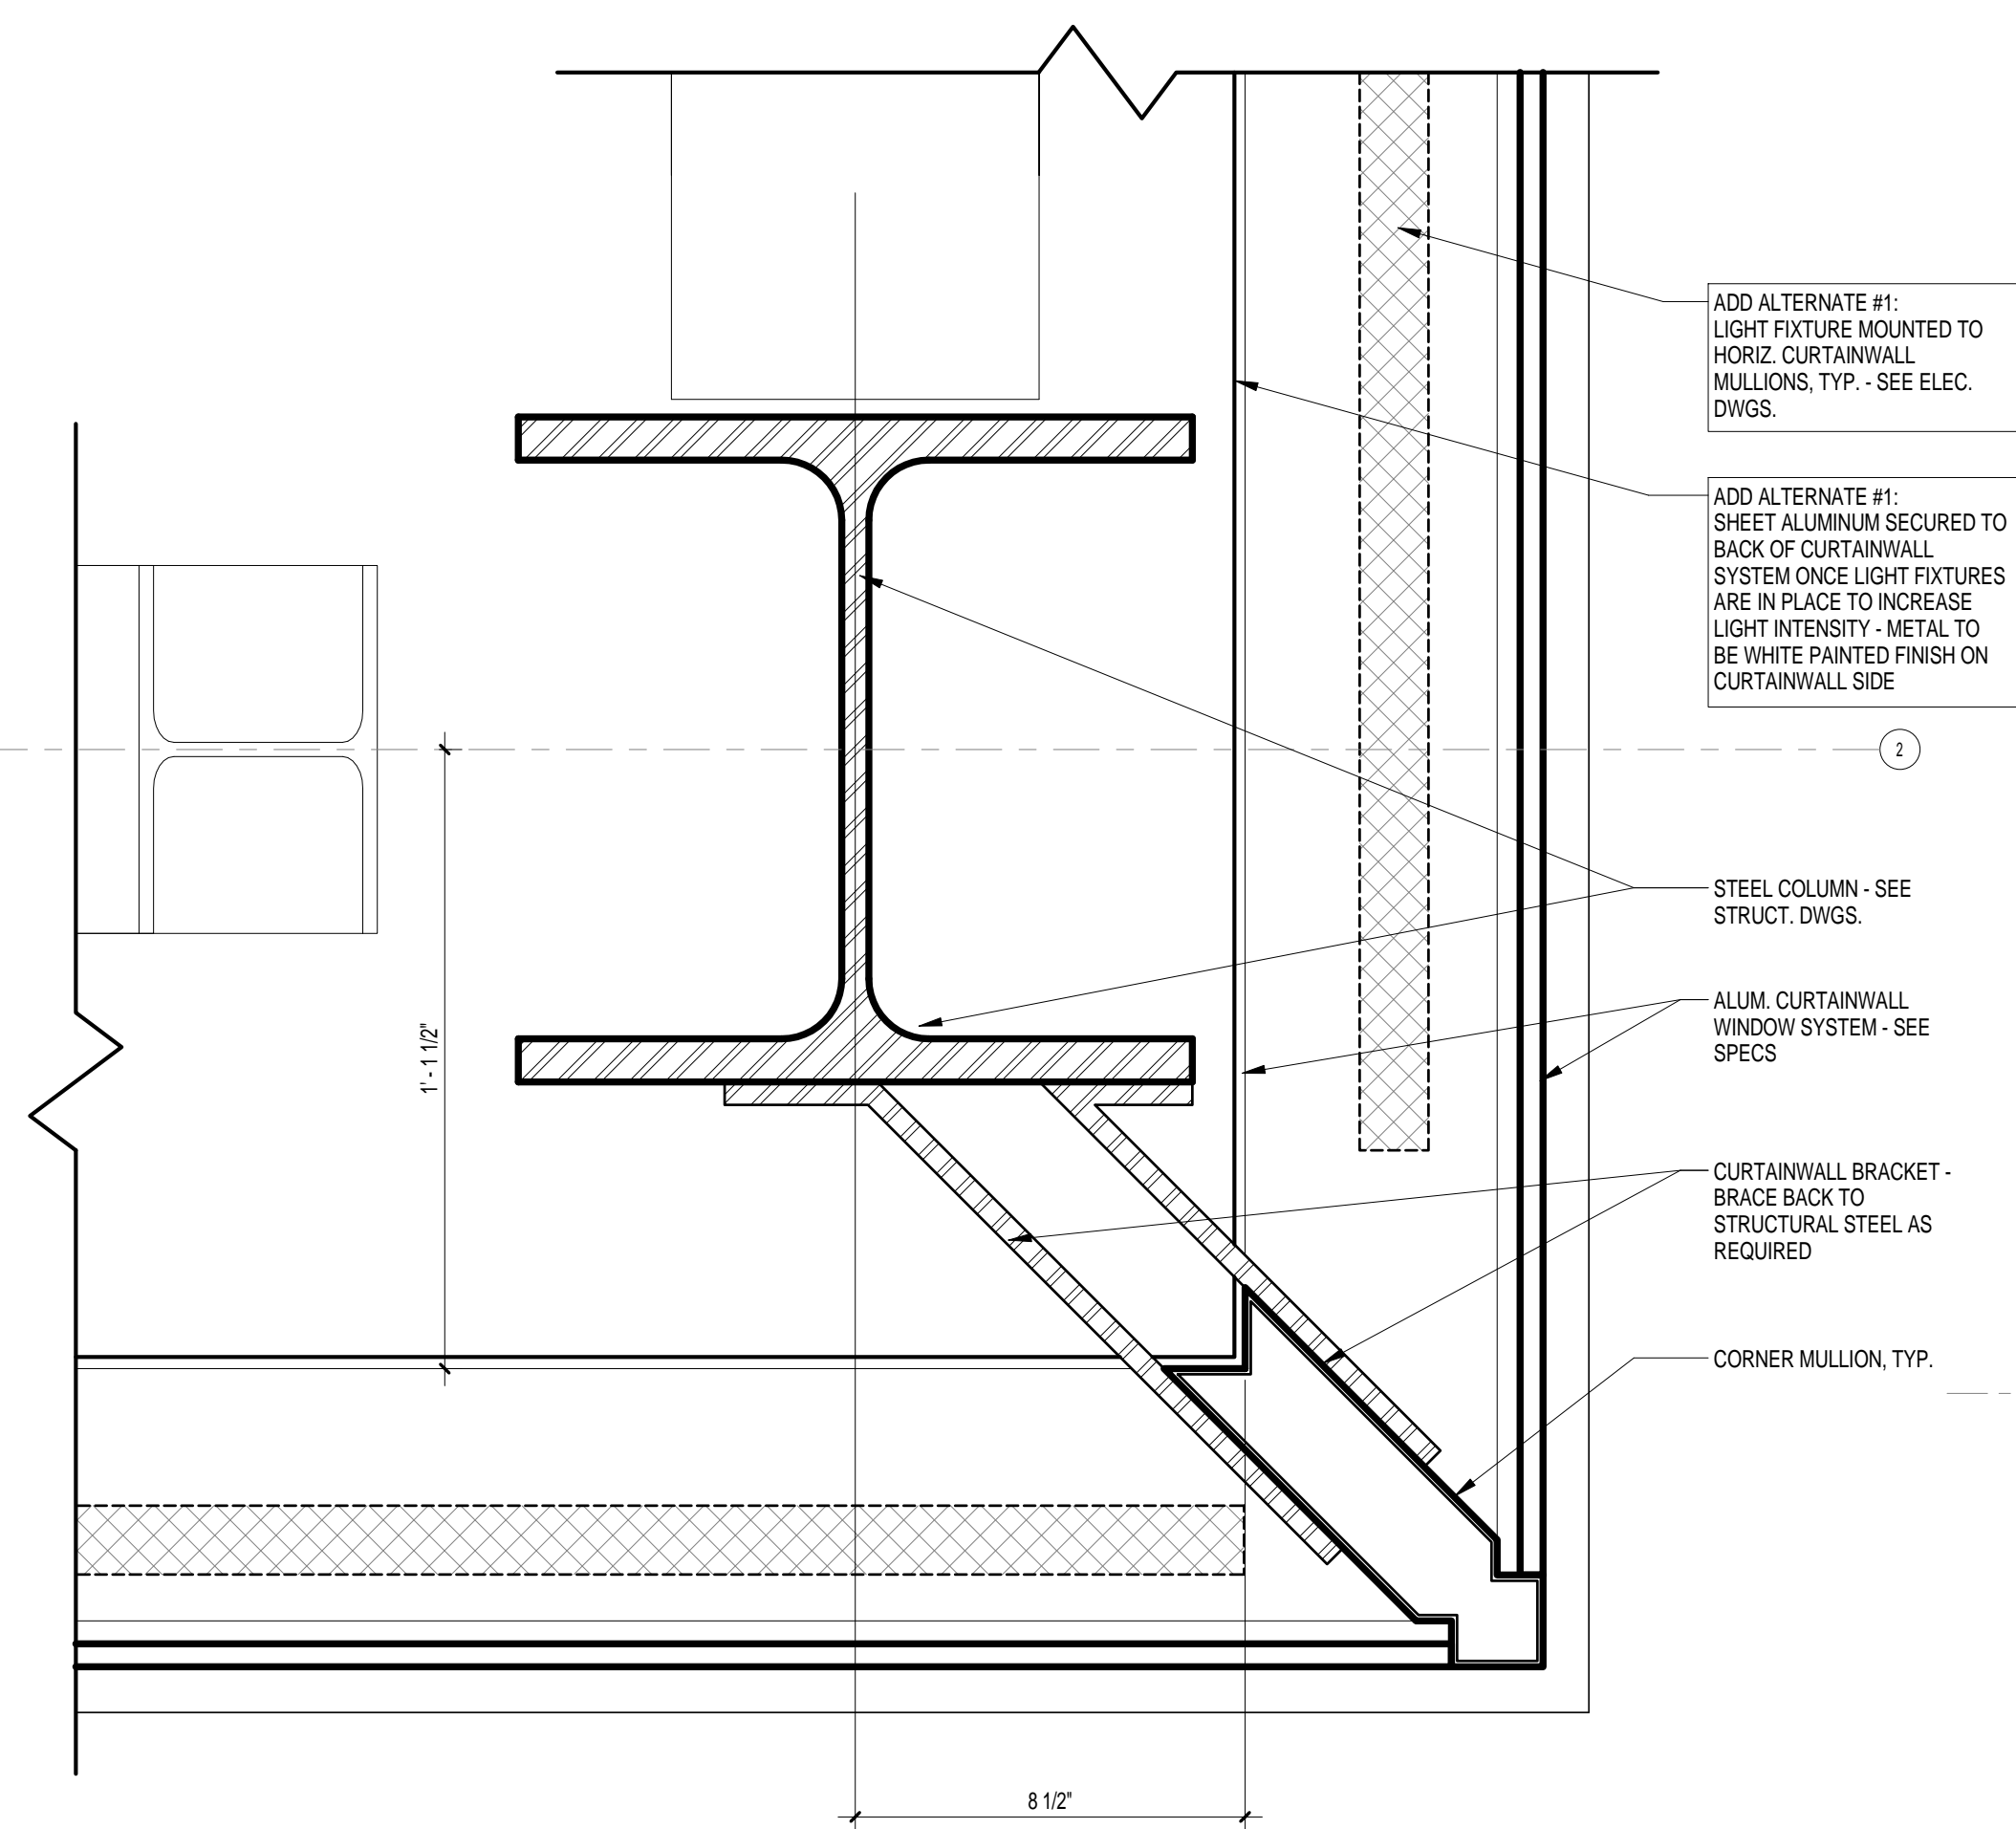


2 JAMB PLAN DETAIL
A7.2 3" = 1'-0" REFERENCED ON: A1.2

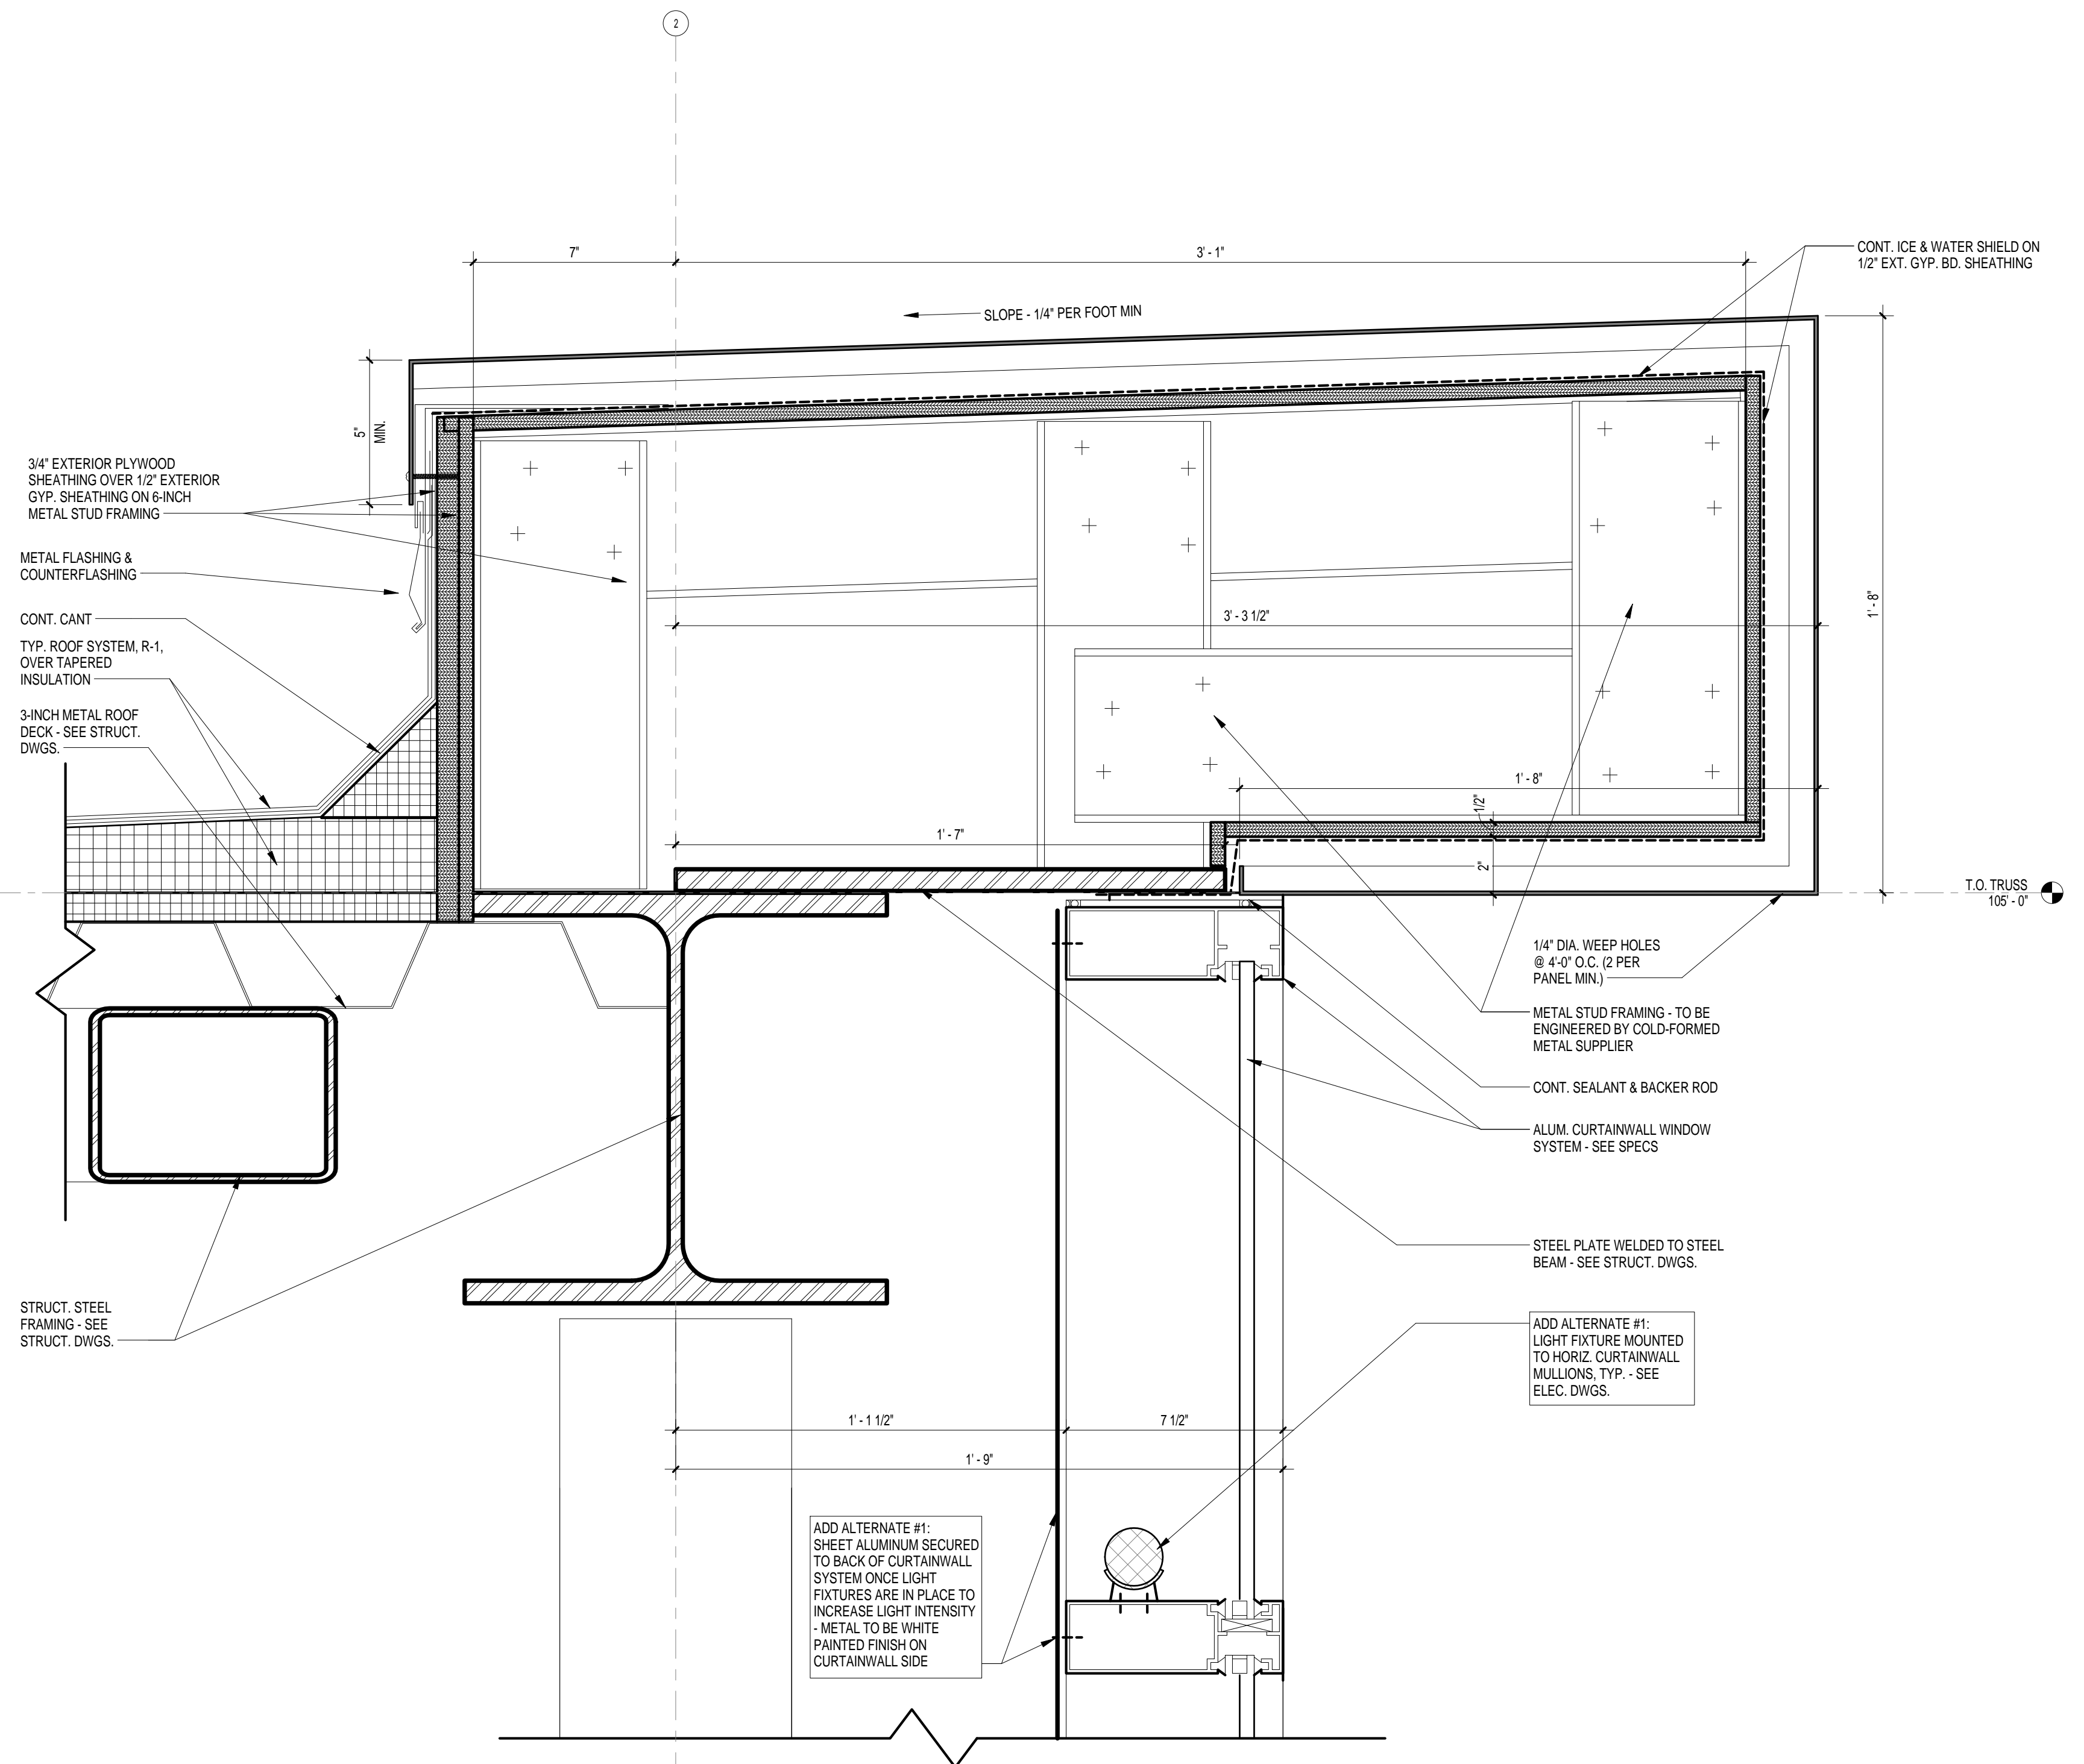


1 HEAD SECTION DETAIL
A7.2 3" = 1'-0" REFERENCED ON: A5.2

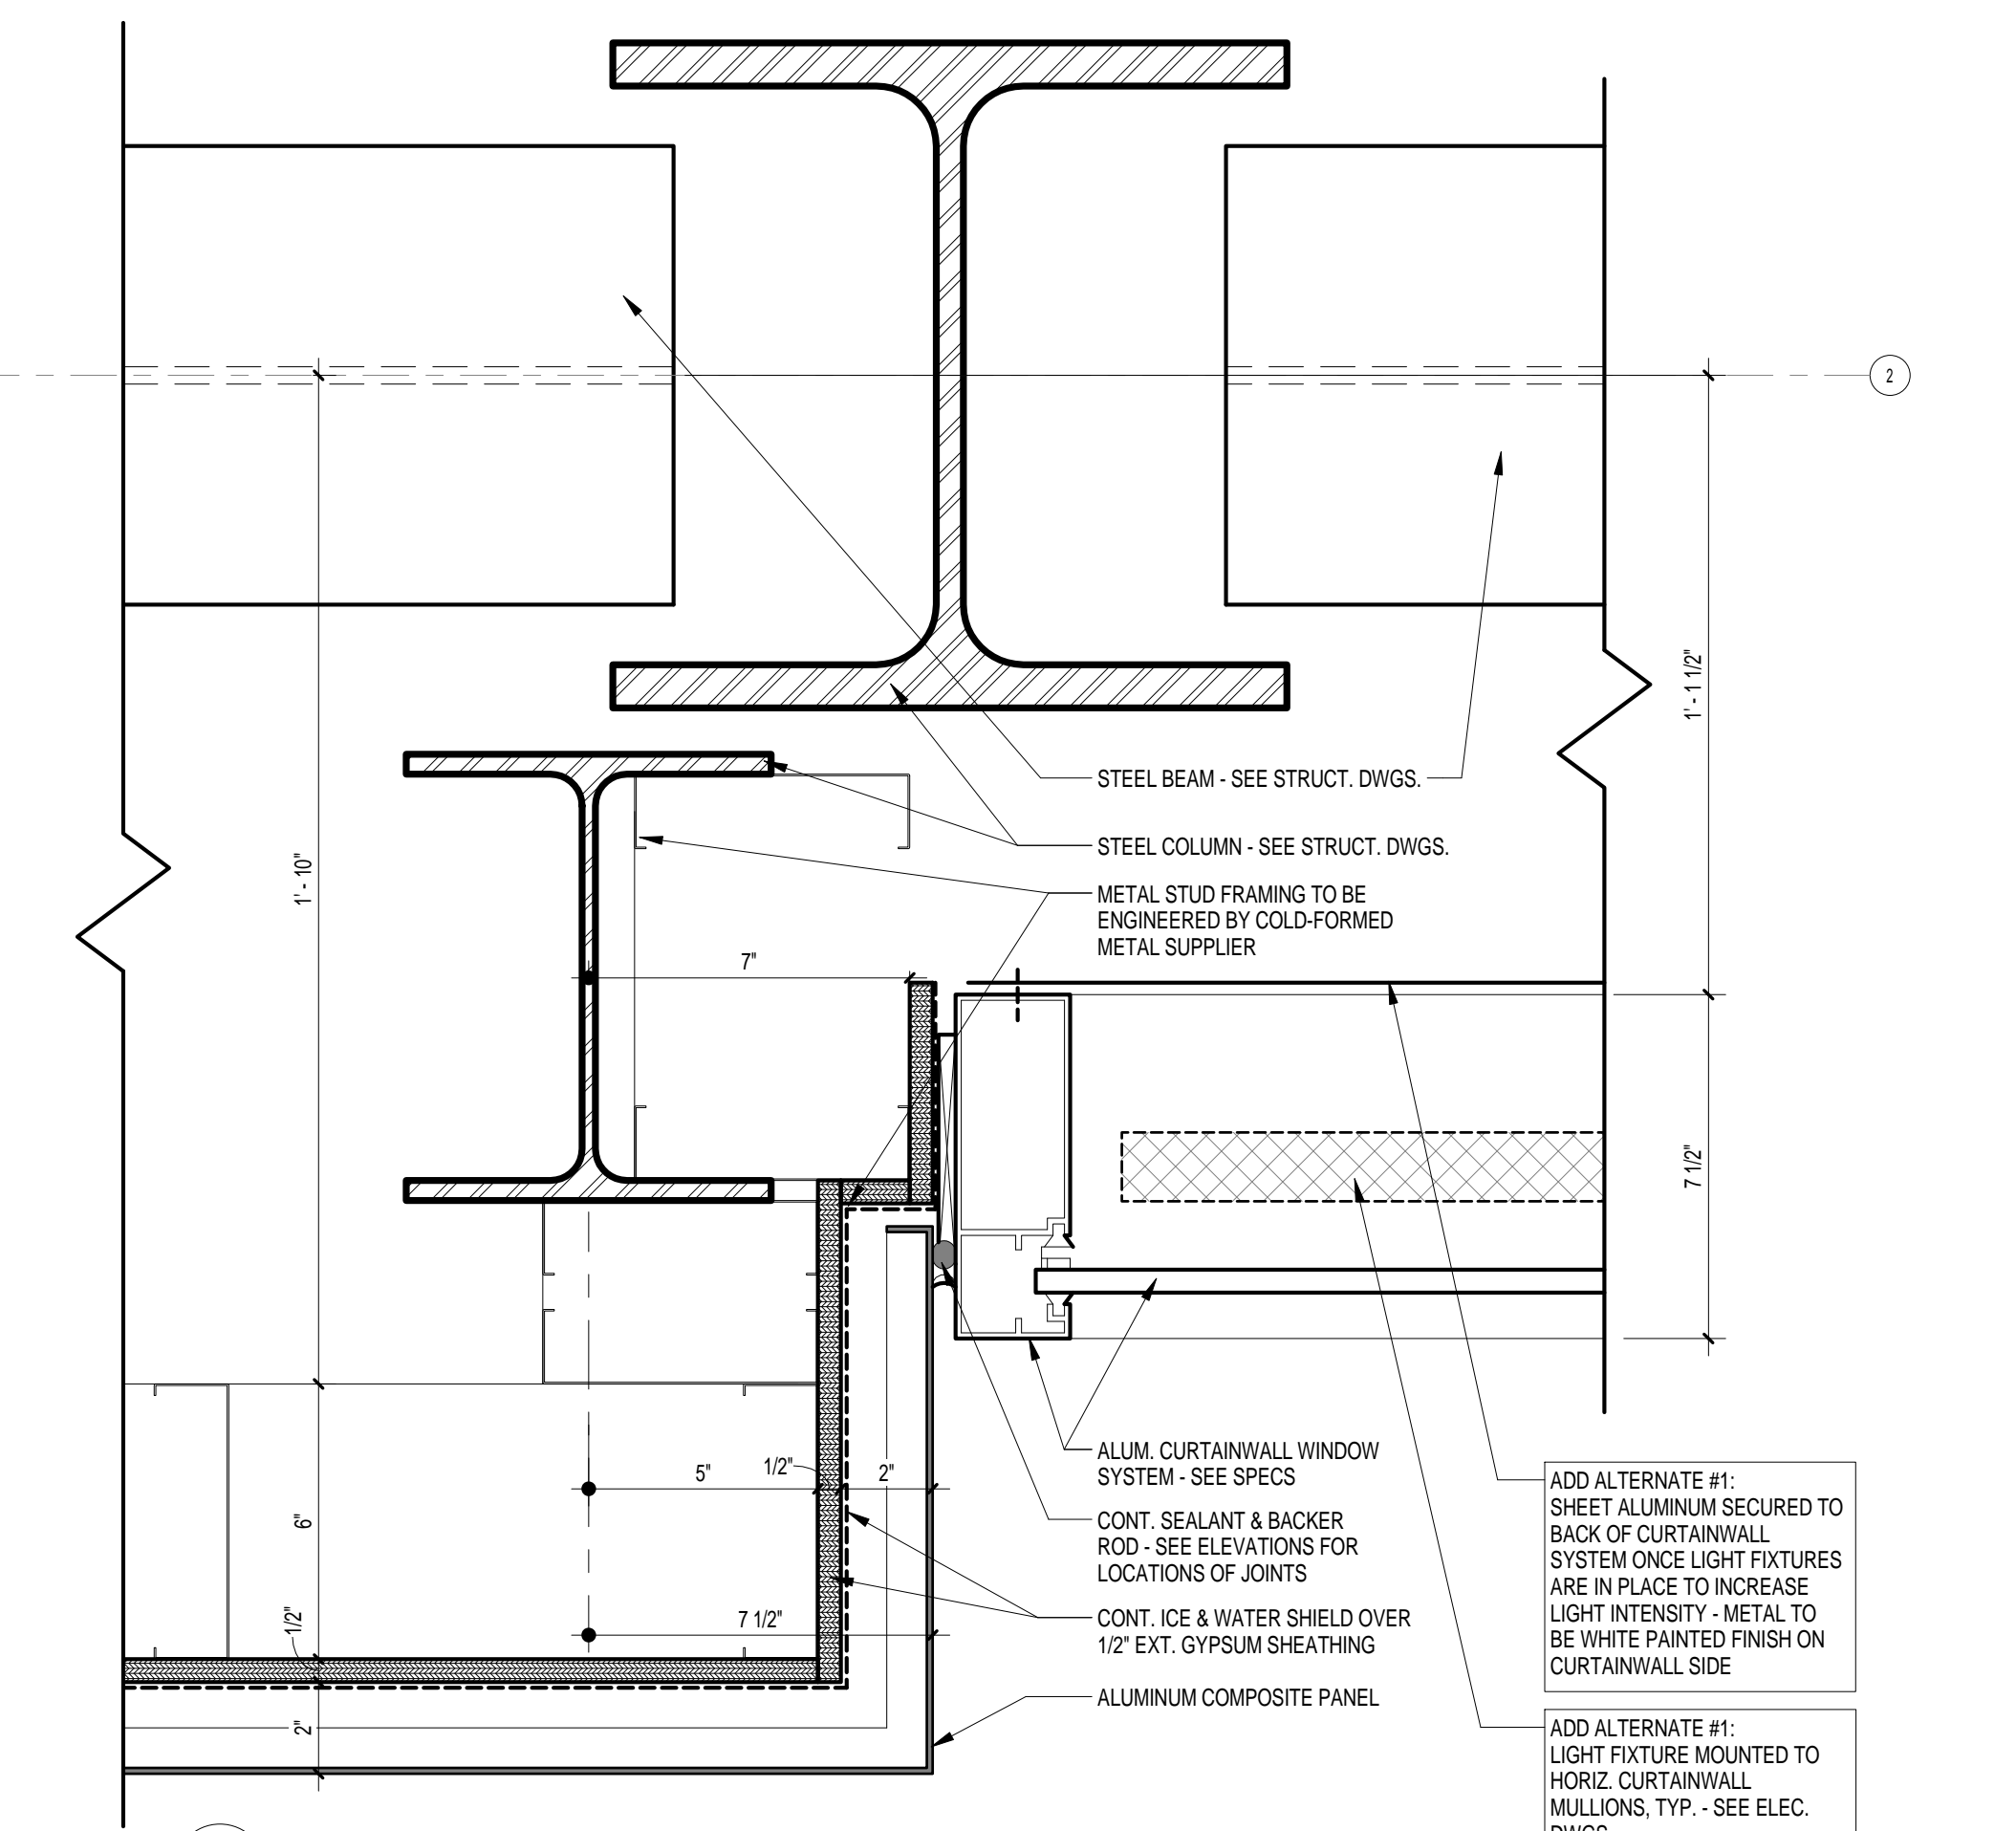


3 JAMB PLAN DETAIL
A7.2 3" = 1'-0" REFERENCED ON: A1.2

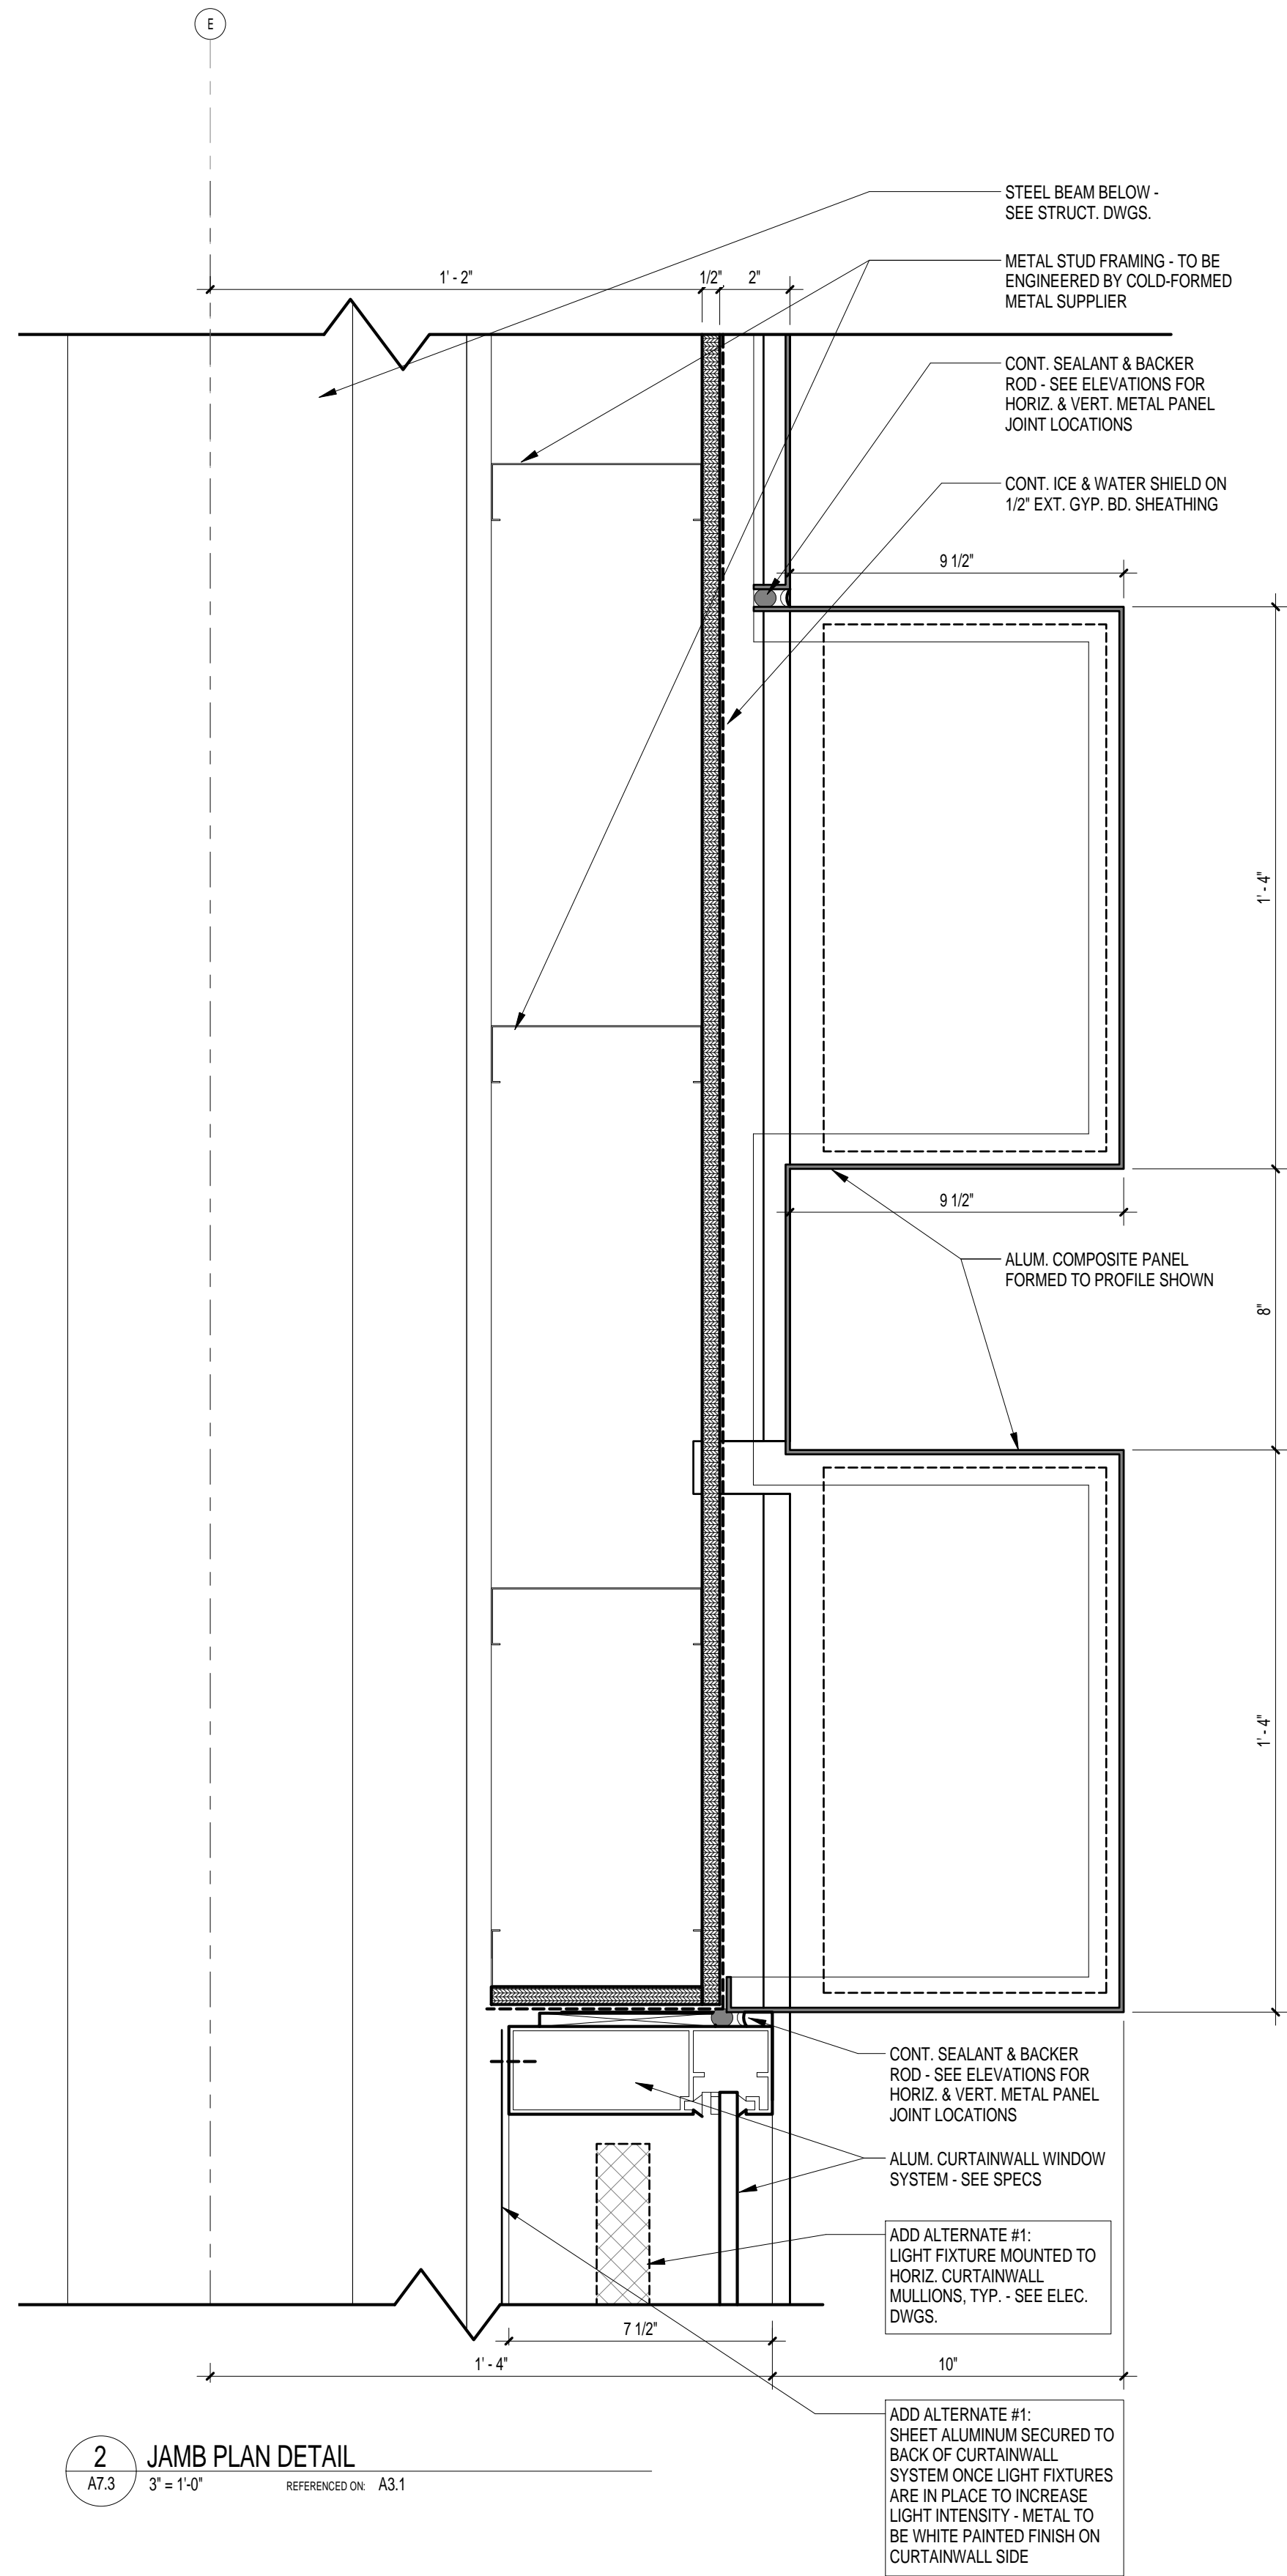

2 JAMB PLAN DETAIL
A7.3 3" = 1'-0" REFERENCED ON A3.1

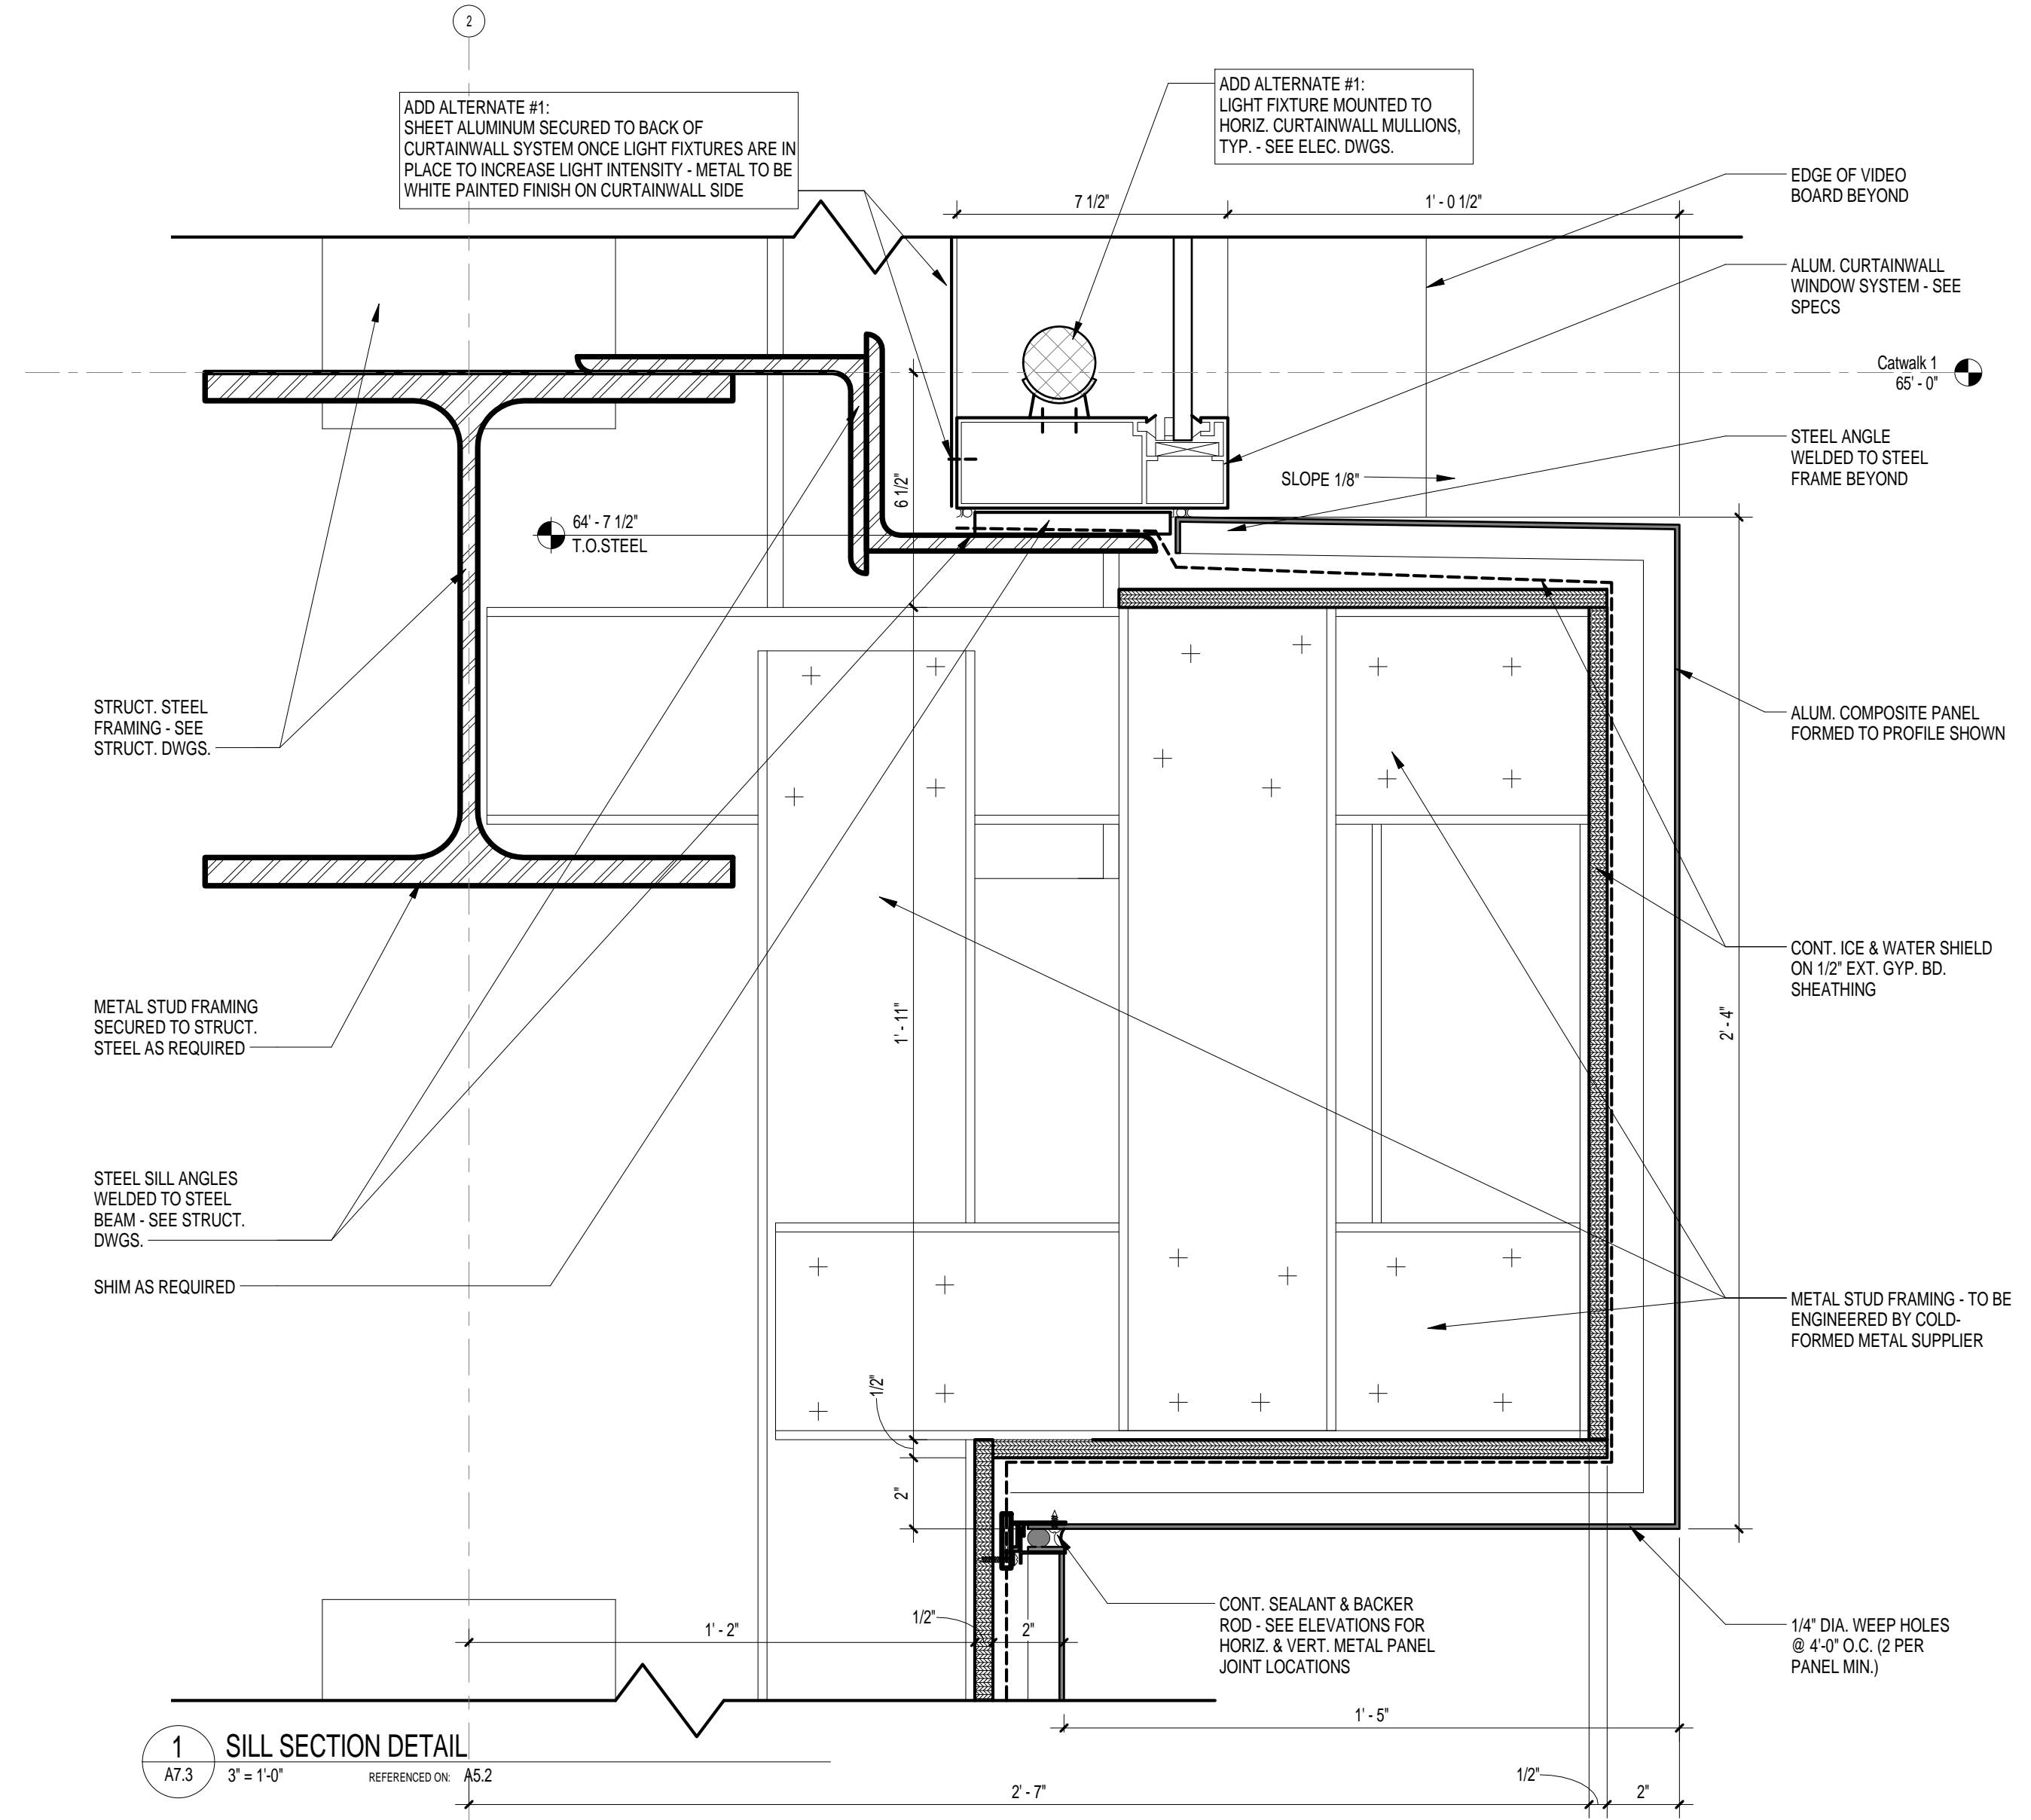

1 SILL SECTION DETAIL
A7.3 3" = 1'-0" REFERENCED ON A5.2

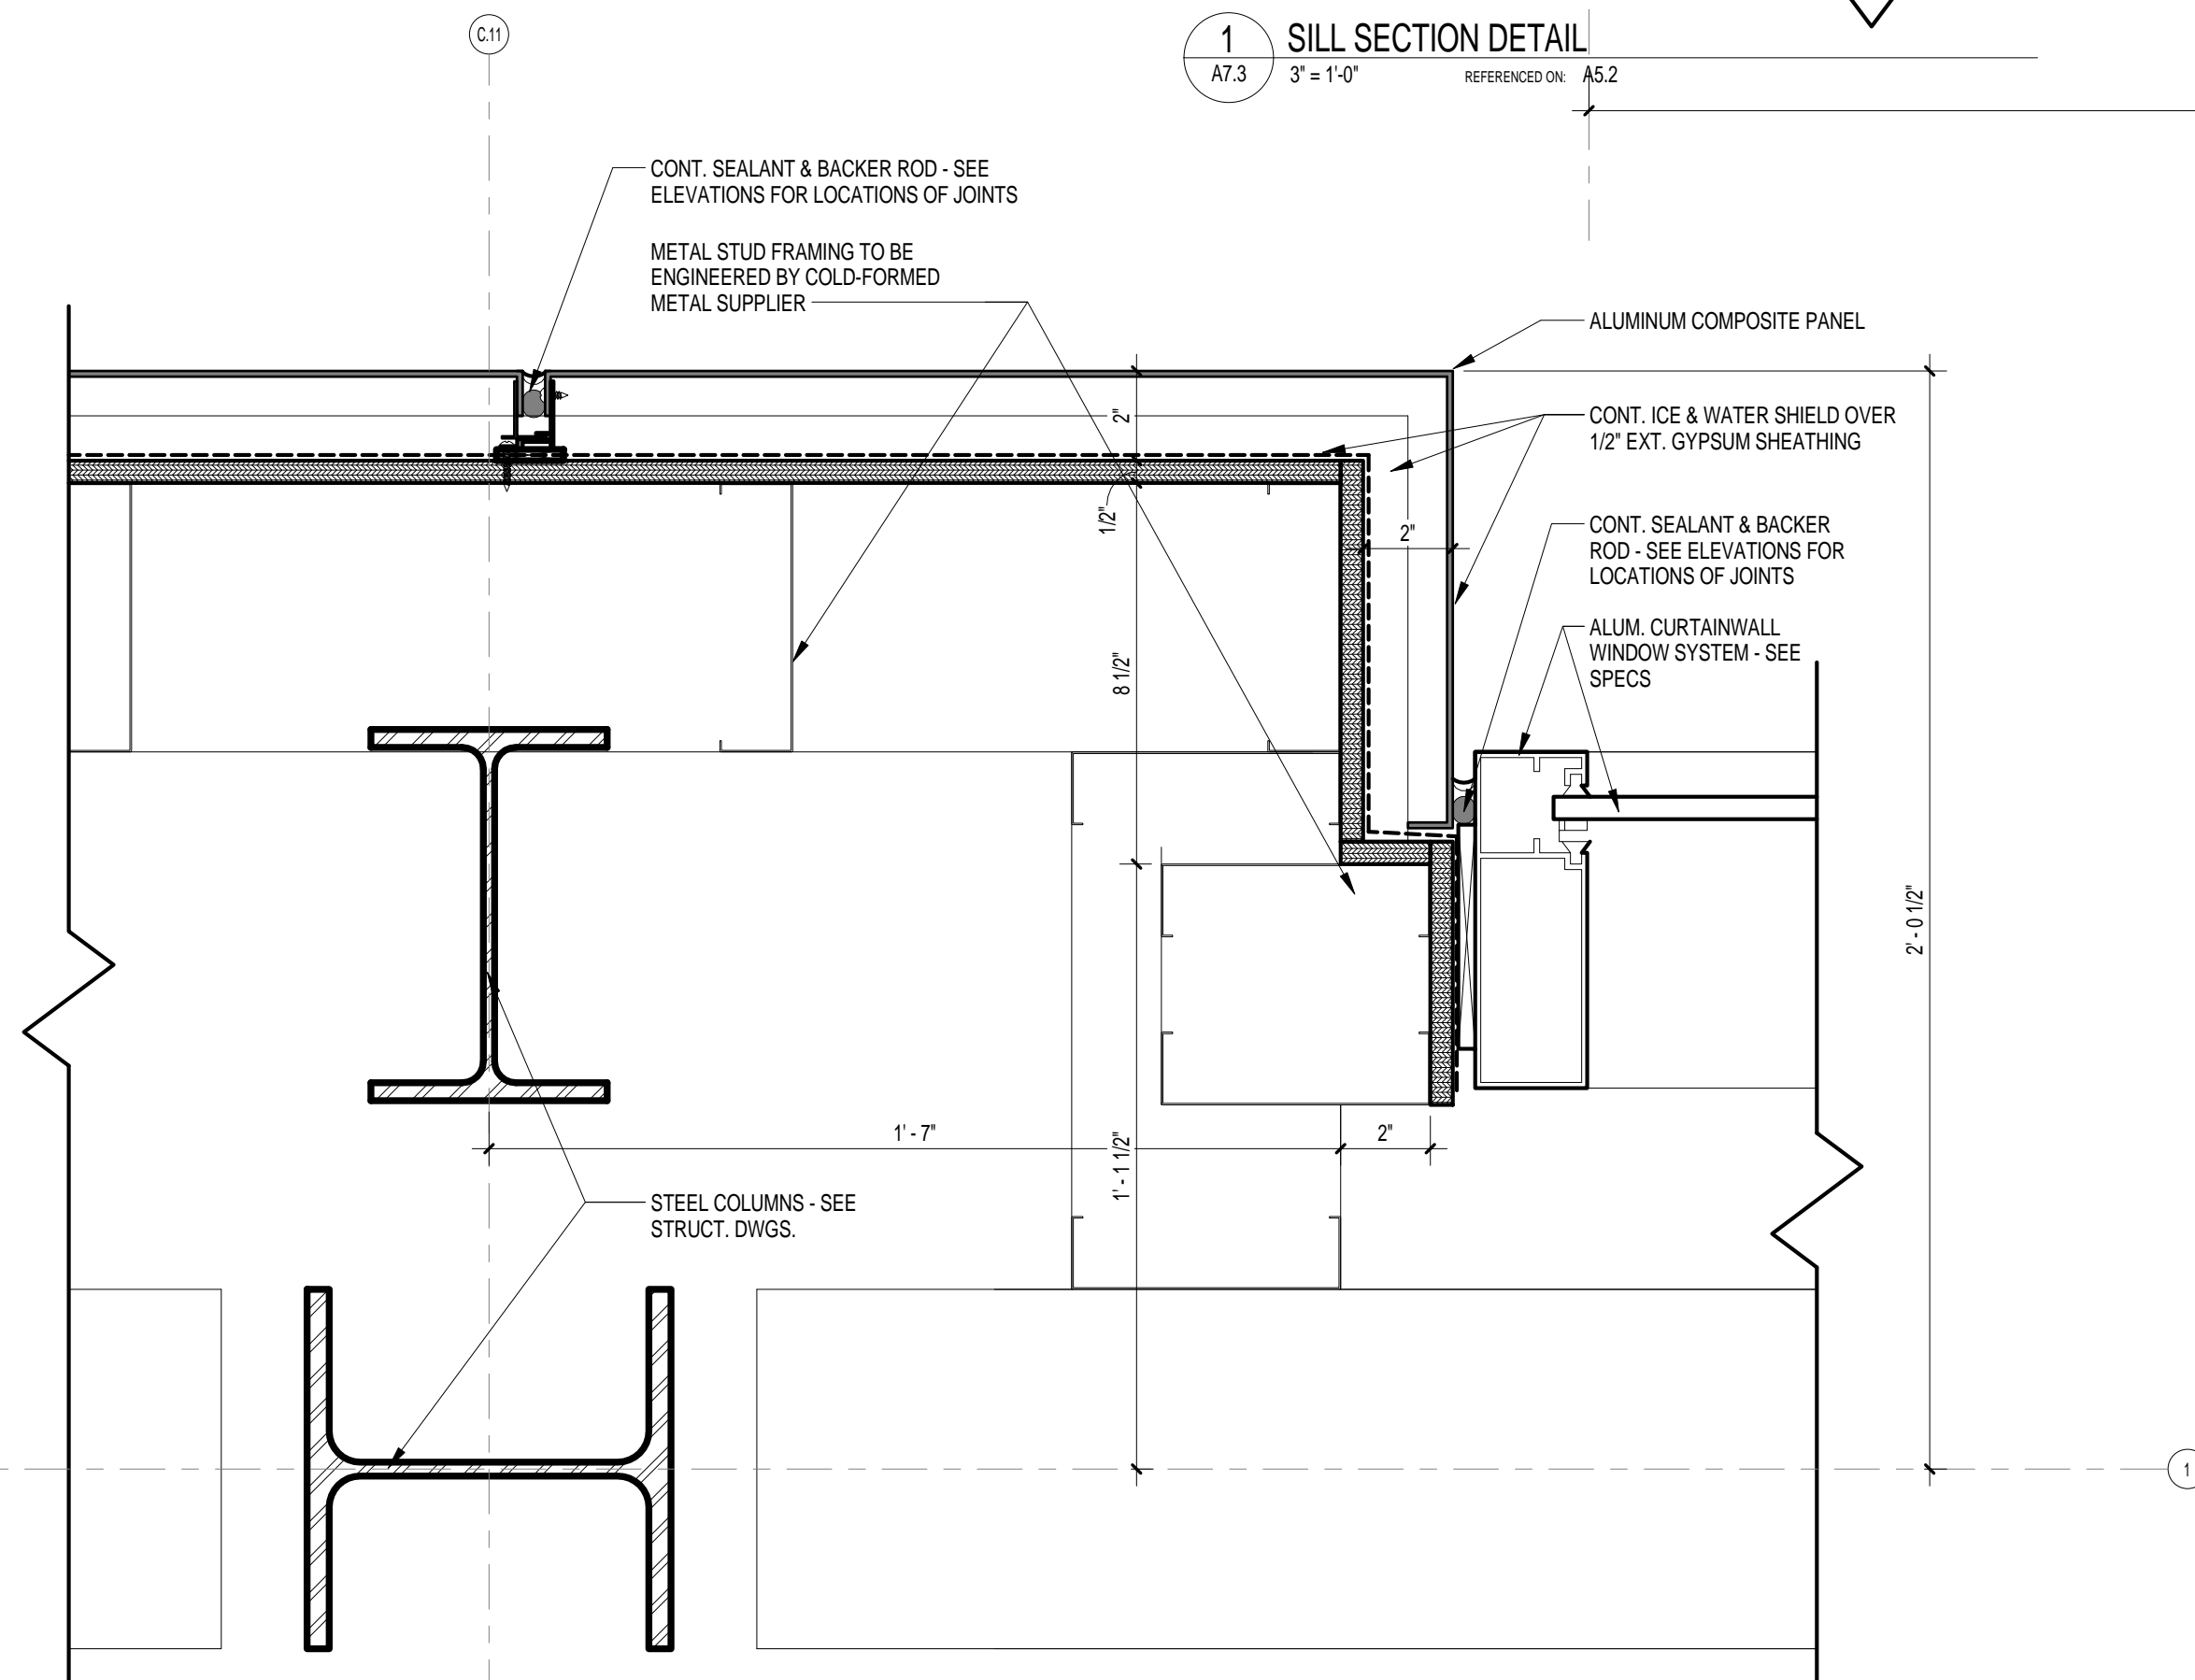

3 JAMB PLAN DETAIL
A7.3 3" = 1'-0" REFERENCED ON A1.2

AE SEAL
AE SEAL


PROJECT TITLE
WILLIAMS-BRICE STADIUM
VIDEO BOARD SUPPORT
CONSTRUCTION
UNIVERSITY OF SOUTH CAROLINA
COLUMBIA, SC
STATE PROJECT NO. H27-6089-MJ

NO.	REVISIONS	NAME	DATE


DRAWN BY: Author
CHKD BY: Checker

DRAWING TITLE
WINDOW DETAILS

PROJECT NO. U291.11
DATE 12.20.11
DRAWING NO. A7.3

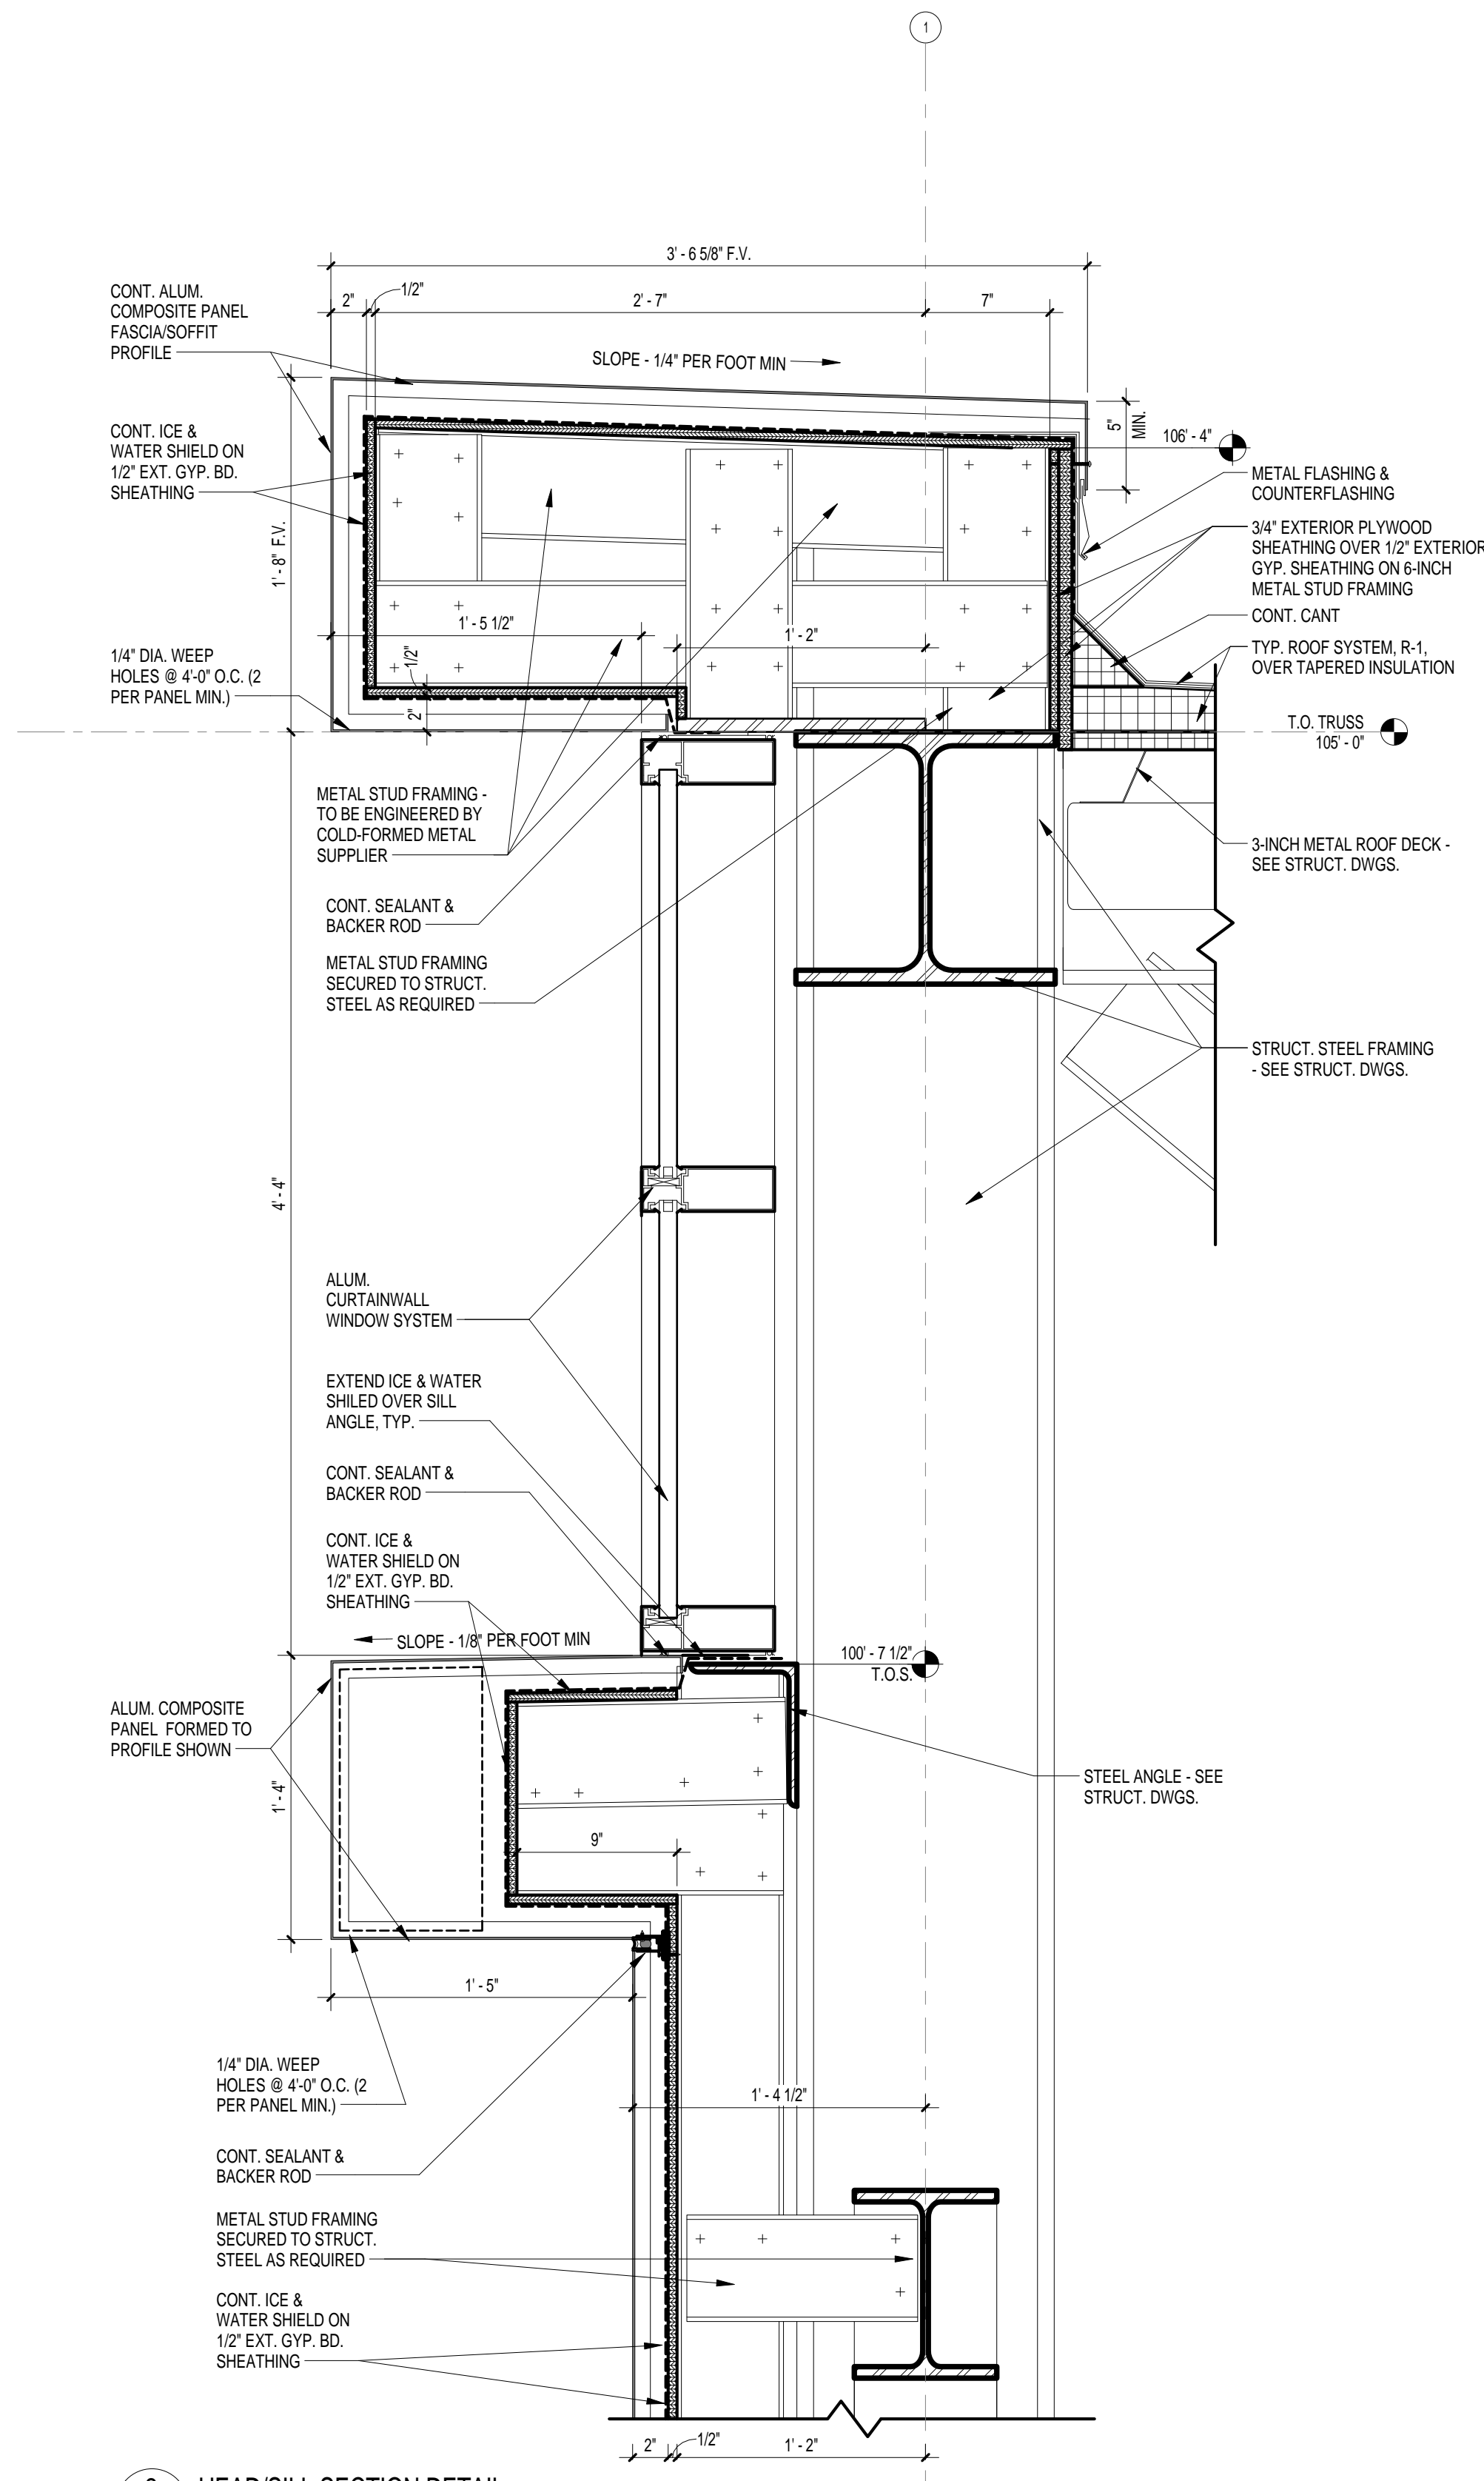

2 HEAD/SILL SECTION DETAIL
 A7.4 1 1/2" = 1'-0" REFERENCED ON: A5.2

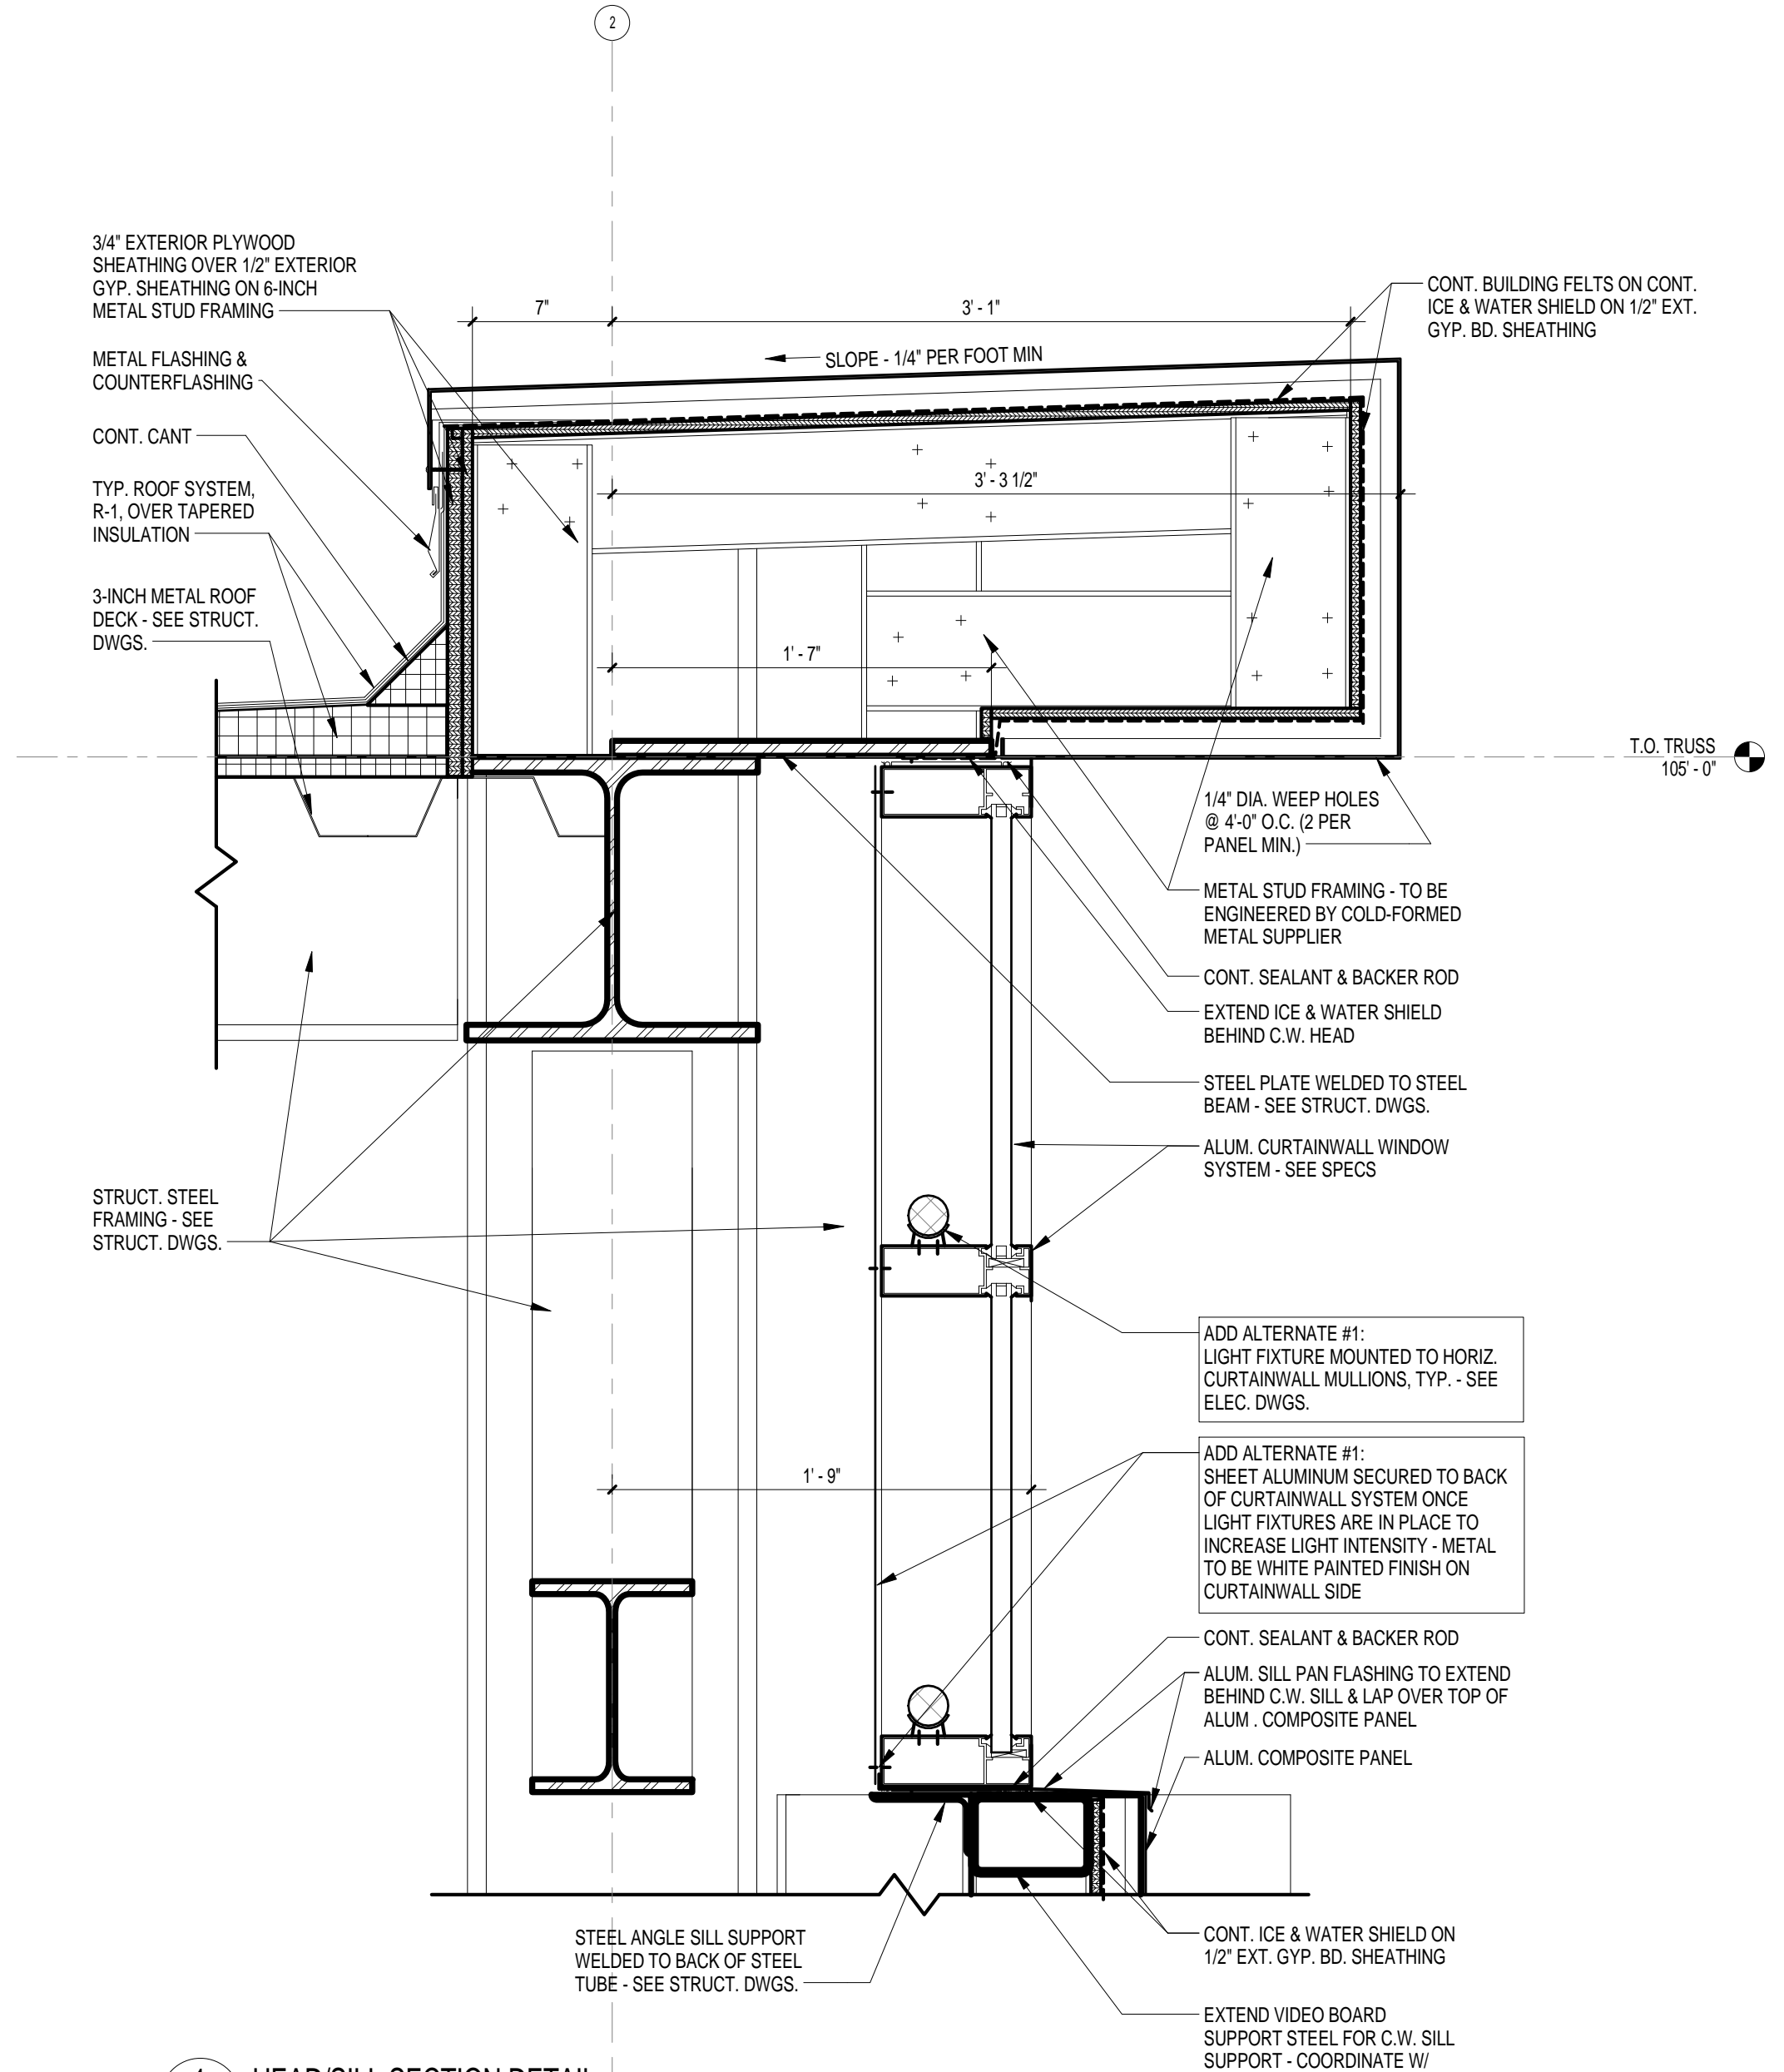

1 HEAD/SILL SECTION DETAIL
 A7.4 1 1/2" = 1'-0" REFERENCED ON: A5.2

AE SEAL
 AE SEAL

PROJECT TITLE
WILLIAMS-BRICE STADIUM
VIDEO BOARD SUPPORT
CONSTRUCTION
 UNIVERSITY OF SOUTH CAROLINA
 COLUMBIA, SC
 STATE PROJECT NO. H27-6089-MJ

NO.	REVISIONS	NAME	DATE


DRAWN BY: Author
CHKD BY: Checker

DRAWING TITLE
WINDOW DETAILS


PROJECT NO. U291.11
DATE 12.20.11
DRAWING NO. **A7.4**

THIS DRAWING AND THE DESIGN HEREON ARE THE PROPERTY OF GARVIN DESIGN GROUP, INC. THE DESIGN GROUP, INC. THE USE OF THIS DRAWING OR DESIGN HEREON FOR ANY PROJECT OTHER THAN THAT FOR WHICH IT WAS PREPARED IS PROHIBITED AND ANY REUSE OR REPRODUCTION IS SUBJECT TO LEGAL ACTION. ©2011 GARVIN DESIGN GROUP, INC.

NOTE:
SEE SHEET S1.0 FOR
INFORMATION REGARDING
THE REMOVAL OF THE
EXISTING SCOREBOARD

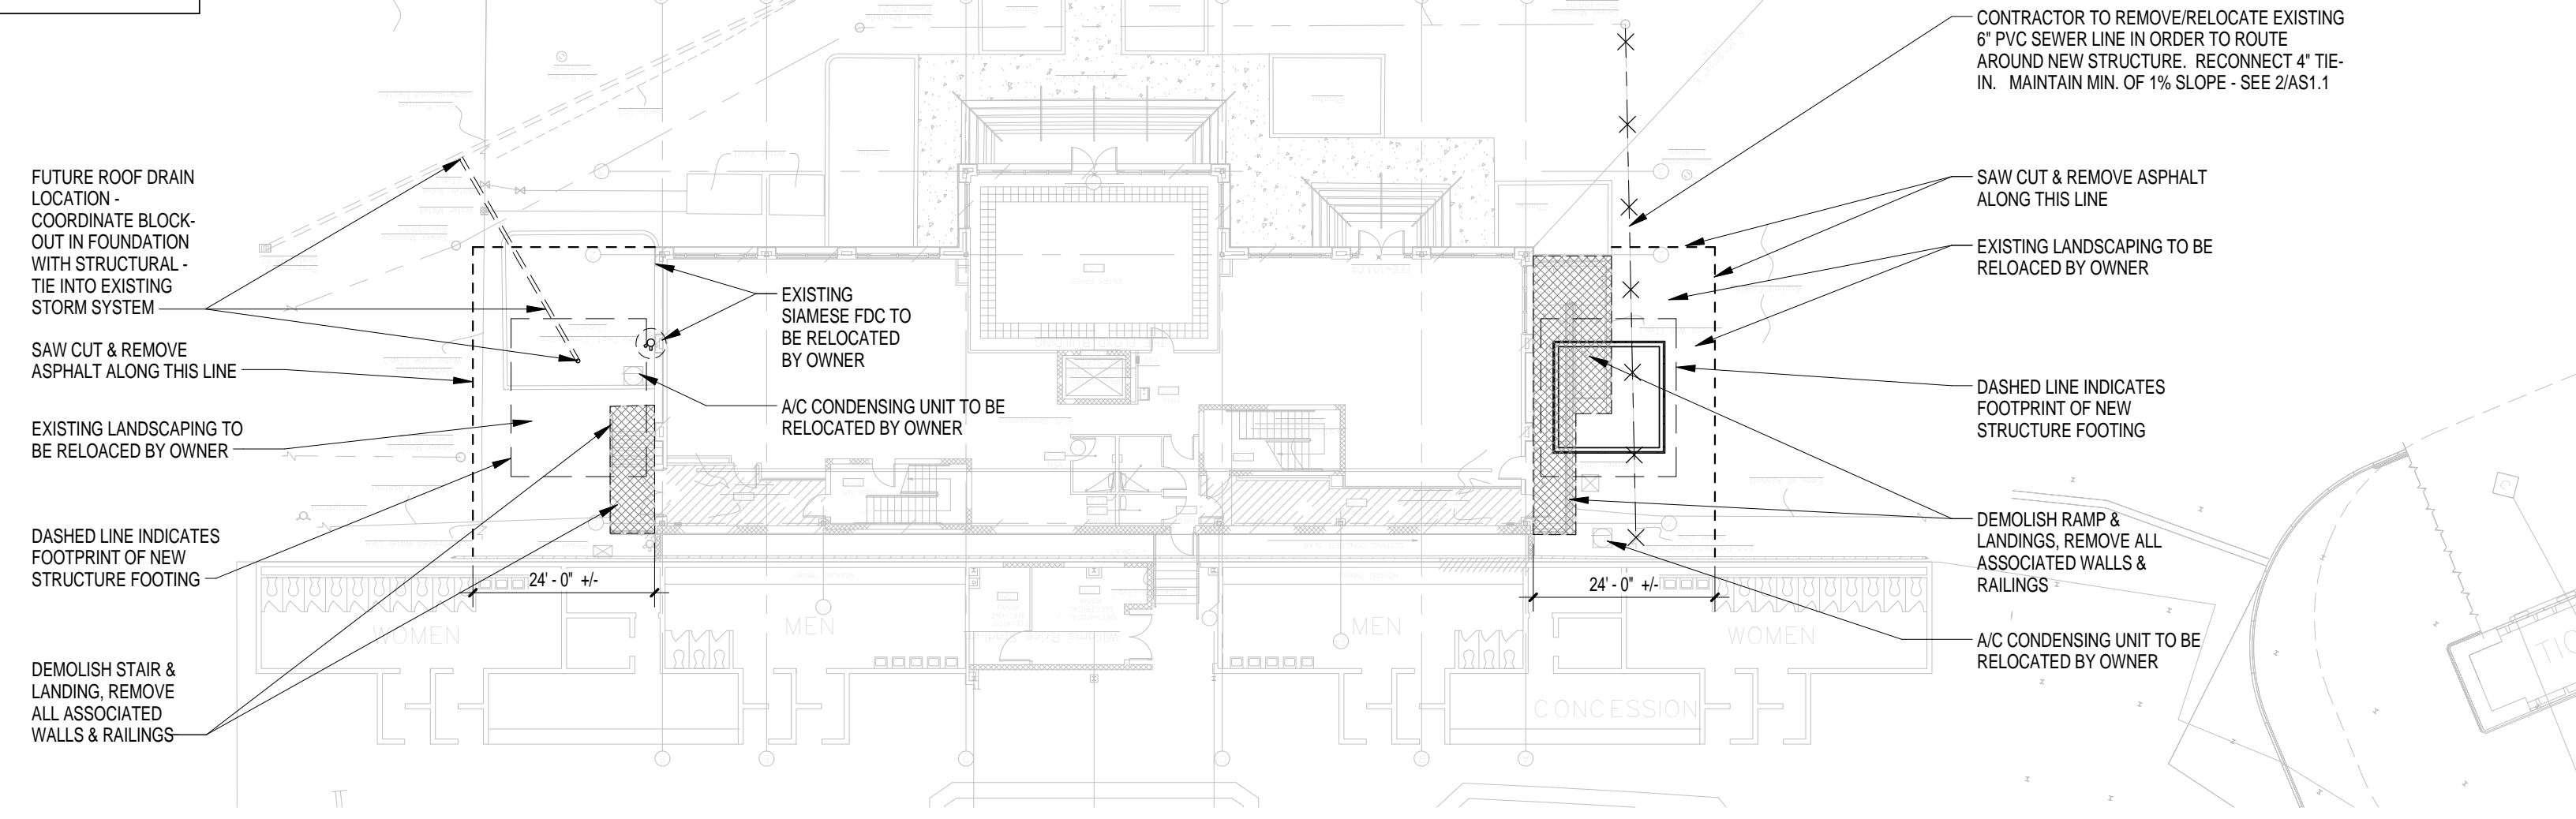

1 SITE DEMOLITION PLAN
AS1.1 1" = 20'-0" REFERENCED ON:

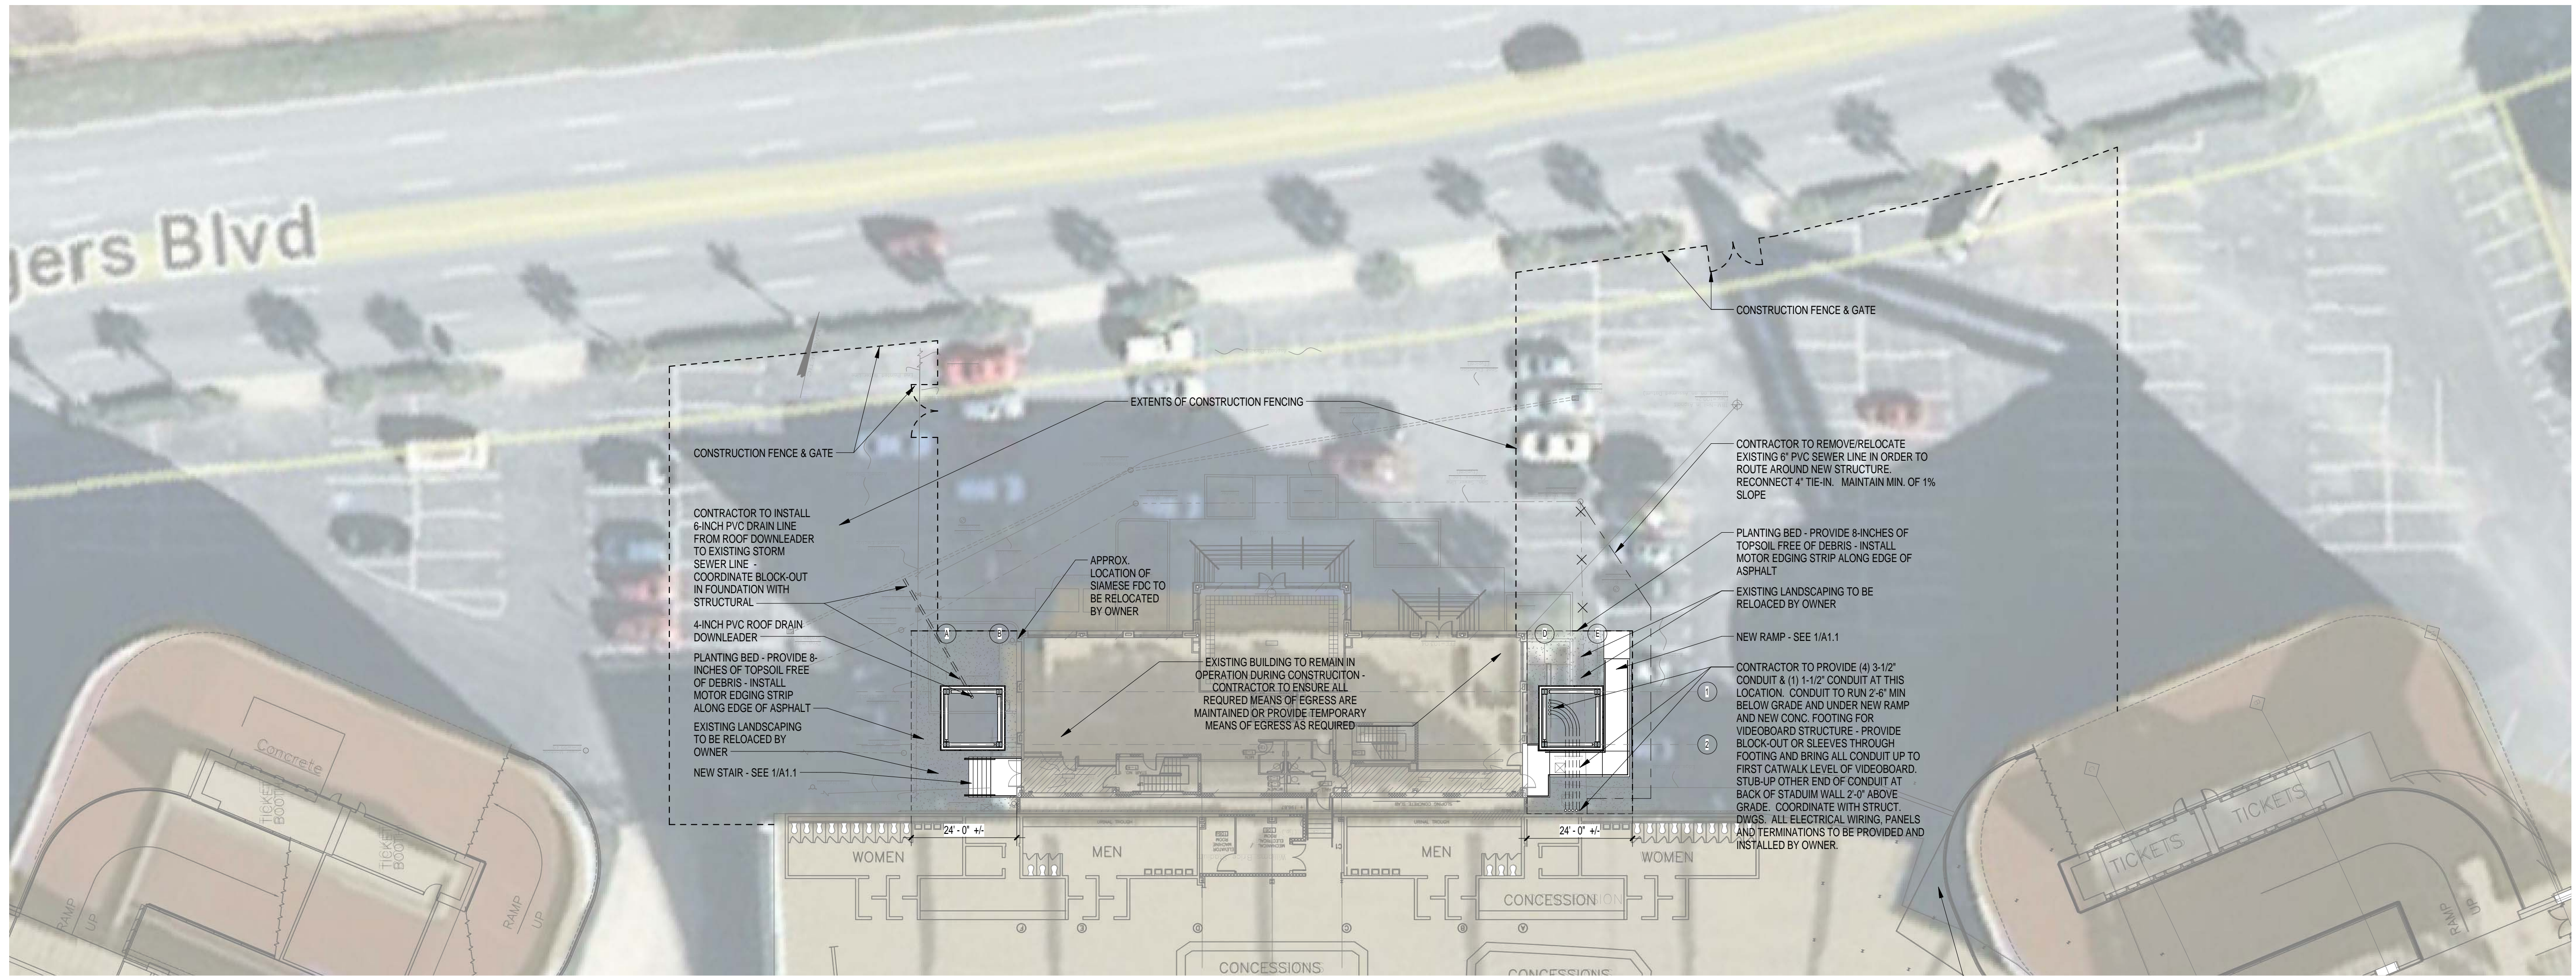

2 ARCHITECTURAL SITE PLAN
AS1.1 1" = 20'-0" REFERENCED ON:

NO.	REVISIONS	NAME	DATE

DRAWN BY: Author
CHKD BY: Checker

DRAWING TITLE
**ARCHITECTURAL
SITE PLAN**

PROJECT NO. U291.11
DATE 12-20-11
DRAWING NO. **AS1.1**

WILLIAMS-BRICE STADIUM VIDEO BOARD SUPPORT CONSTRUCTION

UNIVERSITY OF SOUTH CAROLINA
COLUMBIA, SOUTH CAROLINA
STATE PROJECT NO. H27-6089-MJ
Architect's Project Number: U291.11


12 JANUARY 2012

GARVINDESIGNGROUP
architecture interiors planning

803.212.1032 p / 803.212.1074 f
1209 Lincoln Street P. O. Box 18 Columbia, SC 29202



LOCATOR MAP

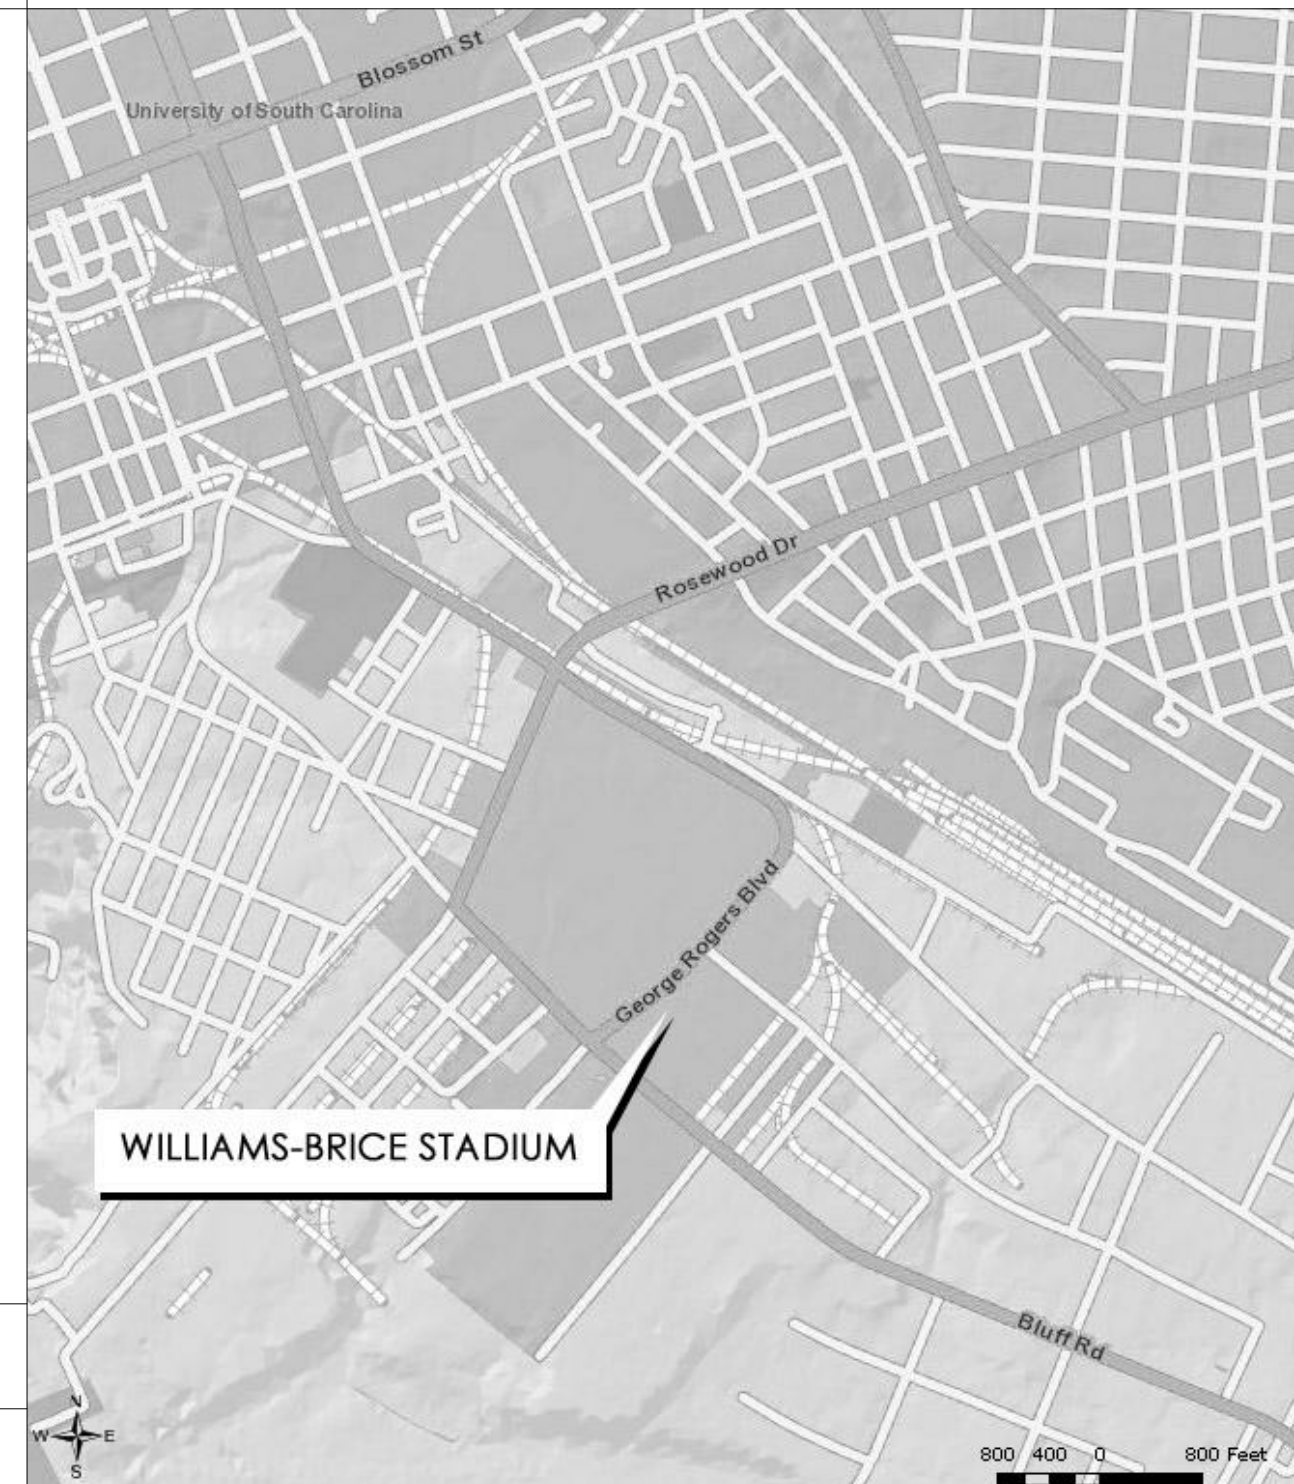

CODE INFORMATION

PROJECT DESIGNED IN ACCORDANCE WITH:

- INTERNATIONAL BUILDING CODE, 2009 EDITION.
- INTERNATIONAL EXISTING BUILDING CODE, 2009 EDITION.
- INTERNATIONAL FIRE CODE, 2009 EDITION.
- INTERNATIONAL ENERGY CONSERVATION CODE, 2009 EDITION.
- INTERNATIONAL FUEL GAS CODE, 2009 EDITION.
- INTERNATIONAL MECHANICAL CODE, 2009 EDITION.
- INTERNATIONAL PLUMBING CODE, 2009 EDITION.
- NATIONAL ELECTRICAL CODE, NFPA 70, 2008 EDITION.
- STATE FIRE MARSHALL REGULATIONS, LATEST REVISION.
- SOUTH CAROLINA ELEVATOR CODE AND REGULATIONS, LATEST EDITION.
- ICC/ANSI 117.1-2003, ACCESSIBLE AND USABLE BUILDINGS AND FACILITIES.
- NATIONAL ELECTRICAL SAFETY CODE, ANSI-C2-2008 EDITION.

BUILDING CODE REVIEW INFORMATION:

1. SITE DEVELOPMENT:

- TOTAL AREA OF PROJECT SITE (IN ACRES): 0.05 ACRES
- TOTAL AREA OF PROJECT SITE THAT WILL BE DISTURBED/DEVELOPED (IN ACRES): 0.005 ACRES
- MUNICIPALITY AND/OR COUNTY WHERE PROJECT IS LOCATED: CITY OF COLUMBIA, SC
- JURISDICTION FOR:
 - SITE WORK: CITY OF COLUMBIA, SC
 - FIRE DEPARTMENT: CITY OF COLUMBIA, SC
 - WATER: CITY OF COLUMBIA, SC
 - SEWER: CITY OF COLUMBIA, SC
 - ZONING: CITY OF COLUMBIA, SC

1.2 IS PROJECT IN FLOOD PLAIN? YES NO

A. FLOOD MAP INFORMATION: N/A COMMUNITY NO.: 450170 PANEL NO.: 0094
 B. FLOOD ZONE: X BASE FLOOD ELEVATION (BFE): N/A
 C. BUILDING LOWEST FLOOR ELEVATION: N/A

1.3 IS PROJECT IN WETLANDS AREA? YES NO

2. OCCUPANCY

2.1 VIDEOBOARD STRUCTURE
 A. OCCUPANCY CLASSIFICATION: N/A

3. TYPE OF CONSTRUCTION:

3.1 N/A

4. SPRINKLERS: X NO YES

5. STANDPIPES: X NO YES

6. HIGH RISE: X NO YES

7. GENERAL BUILDING DESIGN, ALLOWABLE AREA, HEIGHT AND OCCUPANT LOAD: N/A

INDEX TO DRAWINGS

TITLE SHEET	TITLE SHEET
T1.1	TITLE SHEET
ARCHITECTURAL SITE	ARCHITECTURAL SITE PLAN
AS1.1	ARCHITECTURAL SITE PLAN
ARCHITECTURAL	
A1.1	GROUND LEVEL & CATWALK PLANS
A1.2	CATWALK PLANS
A2.1	UNDERSIDE OF CATWALK PLANS
A3.1	ENLARGED PLANS, PLAN DETAILS
A4.1	ELEVATIONS
A4.2	ELEVATIONS, LOUVER ELEVATIONS & DETAILS
A4.3	ELEVATIONS, LOUVER ELEVATIONS & DETAILS
A5.1	SECTIONS
A5.2	SECTIONS
A5.3	SECTIONS, SECTION DETAILS
A5.4	SECTION DETAILS
A6.1	WALL SECTIONS
A7.1	WINDOW ELEVATIONS & DETAILS
A7.2	WINDOW DETAILS
A7.3	WINDOW DETAILS
A7.4	WINDOW DETAILS
STRUCTURAL	
S1.0	FOUNDATION PLAN
S1.1	FOUNDATION DETAILS
S1.2	RAMP & LOADING DOCK PLAN
S2.0	FIELD SIDE ELEVATION
S2.1	STREET SIDE ELEVATION
S2.2	EAST & WEST ELEVATIONS
S2.3	TRUSS & CATWALK FRAMING PLANS
S2.4	STEEL FRAMING SECTIONS
S3.0	LOAD TABLE & WIND DISTRIBUTION
S3.1	STRUCTURAL NOTES
S3.2	STRUCTURAL NOTES
S3.3	SPECIAL INSPECTIONS
S4.0	STRUCTURAL STEEL MEMBER FORCES
S4.1	STRUCTURAL STEEL MEMBER FORCES
S4.2	STRUCTURAL STEEL MEMBER FORCES
S4.3	STRUCTURAL STEEL MEMBER FORCES
ELECTRICAL	
E1	ELECTRICAL PLAN

ARCHITECTURAL SYMBOLS

1 TITLE
 A1.1 SCALE: 1'-0" = 1'-0" REF: 1/A1.1
 DETAIL NUMBER LOCATION OF DETAIL CUT (AS SHOWN)
 WHERE DETAIL IS SHOWN

WALL SECTION / DETAIL SECTION REFERENCE
 1 A1.1
 WALL SECTION / DETAIL NUMBER WHERE WALL SECTION / DETAIL IS SHOWN

ROOM TAG SYMBOL
 RECEPTION 100
 ROOM NAME ROOM NUMBER

DOOR SYMBOL
 001A DX FX
 DOOR NUMBER FRAME TYPE DOOR TYPE

10'-0" DIMENSION TO FACE OR EDGE
 10'-0" DIMENSION TO CENTERLINE
 EL 14'-0" FIN. FLOOR ELEVATION ABOVE SEA LEVEL ITEM IDENTIFIED

(S1) WINDOW / STOREFRONT / CURTAIN WALL / LOUVER TYPE
 (1A) PARTITION TYPE
 FEC FIRE EXTINGUISHER RECESSED IN WALL CABINET
 FE= FIRE EXTINGUISHER MOUNTED ON WALL BRACKETS
 FD-FLOOR DRAIN

BUILDING SECTION REFERENCE
 BUILDING SECTION NUMBER WHERE BUILDING SECTION IS SHOWN

PLAN DETAIL REFERENCE
 1 A1.1
 DETAIL NUMBER WHERE DETAIL IS SHOWN


FIRE RATED WALL SYMBOLS
 ONE-HOUR FIRE-RATED WALL ASSEMBLY
 TWO-HOUR FIRE-RATED WALL ASSEMBLY
 FOUR-HOUR FIRE-RATED WALL ASSEMBLY
 SEE PARTITION TYPES FOR UL DESIGN NOS.

REVISION SYMBOL
 CITY OF COLUMBIA CHANGES
 OWNER INITIATED CHANGES
 MP2MS6 EXTERIOR WALL / ROOF CONSTRUCTION TYPE

ABBREVIATIONS

@	ANGLE	ELEC	ELECTRICAL	LAV	LAVATORY	RD	ROOF DRAIN
AFF	ABOVE FINISH FLOOR	EL	ELEVATION	RO	ROUGH OPENING	RO	ROUGH OPENING
ALUM	ALUMINUM	ELEV	ELEVATOR	MECH	MECHANICAL	SF	SQUARE FEET
ARCH	ARCHITECTURAL	EQUIP	EQUIPMENT	MFR	MANUFACTURER	SIM	SIMILAR
BLKG	BLOCKING	EWC	ELECTRIC WATER COOLER	MIN	MINIMUM	SPEC	SPECIFICATIONS
BULG	BUILT-UP ROOF	FIN	FINISH	MO	MASONRY OPENING	SS	STAINLESS STEEL
CL	CENTERLINE	FD	FLOOR DRAIN	NIC	NOT IN CONTRACT	STD	STANDARD
CLJ	CENTERLINE CONTROL JOINT	FOF	FACE OF FINISH	NOM	NOMINAL	STR	STRUCTURAL
CJ	CONTROL JOINT	FOS	FACE OF STUD	NTS	NOT TO SCALE	SUSP	SUSPENDED
CMU	CONCRETE MASONRY UNIT	FR	FIRE RETARDANT	OC	ON CENTER	TOS	TOP OF STEEL
CONT	CONTINUOUS	FV	FIELD VERIFY	OD	OUTSIDE DIAMETER	TOW	TOP OF WALL
DIA	DIAMETER	GA	GAUGE	O.H.	OPPOSITE HAND DIRECTION	TYP	TYPICAL
DS	DOWN SPOUT	GYP BD	GYPSPUM BOARD	OPNG	OPENING	UNO	UNLESS NOTED OTHERWISE
DWG	DRAWING	HM	HOLLOW METAL	OPP	OPPOSITE	VERT	VERTICAL
EXT	EXTERIOR	HORIZ	HORIZONTAL	P	PAINT	VCT	VINYL COMPOSITION TILE
EXIST	EXISTING	HT	HEIGHT	PR	PAIR	W	WITH
EA	EACH	HVAC	HEATING VENTILATION AIR-CONDITIONING	PL	PLATE, PROPERTY LINE	WC	WATER CLOSET
EJ	EXPANSION JOINT	ID	INSIDE DIAMETER	PT	PRESSURE TREATED	WR	WATER RESISTANT
		INSUL	INSULATION	R, RAD	RADIUS	WWF	WELDED WIRE FABRIC
		JT	JOINT	REQD	REQUIRED	WD	WOOD

ANSI 117.1 - MANEUVERING CLEARANCES

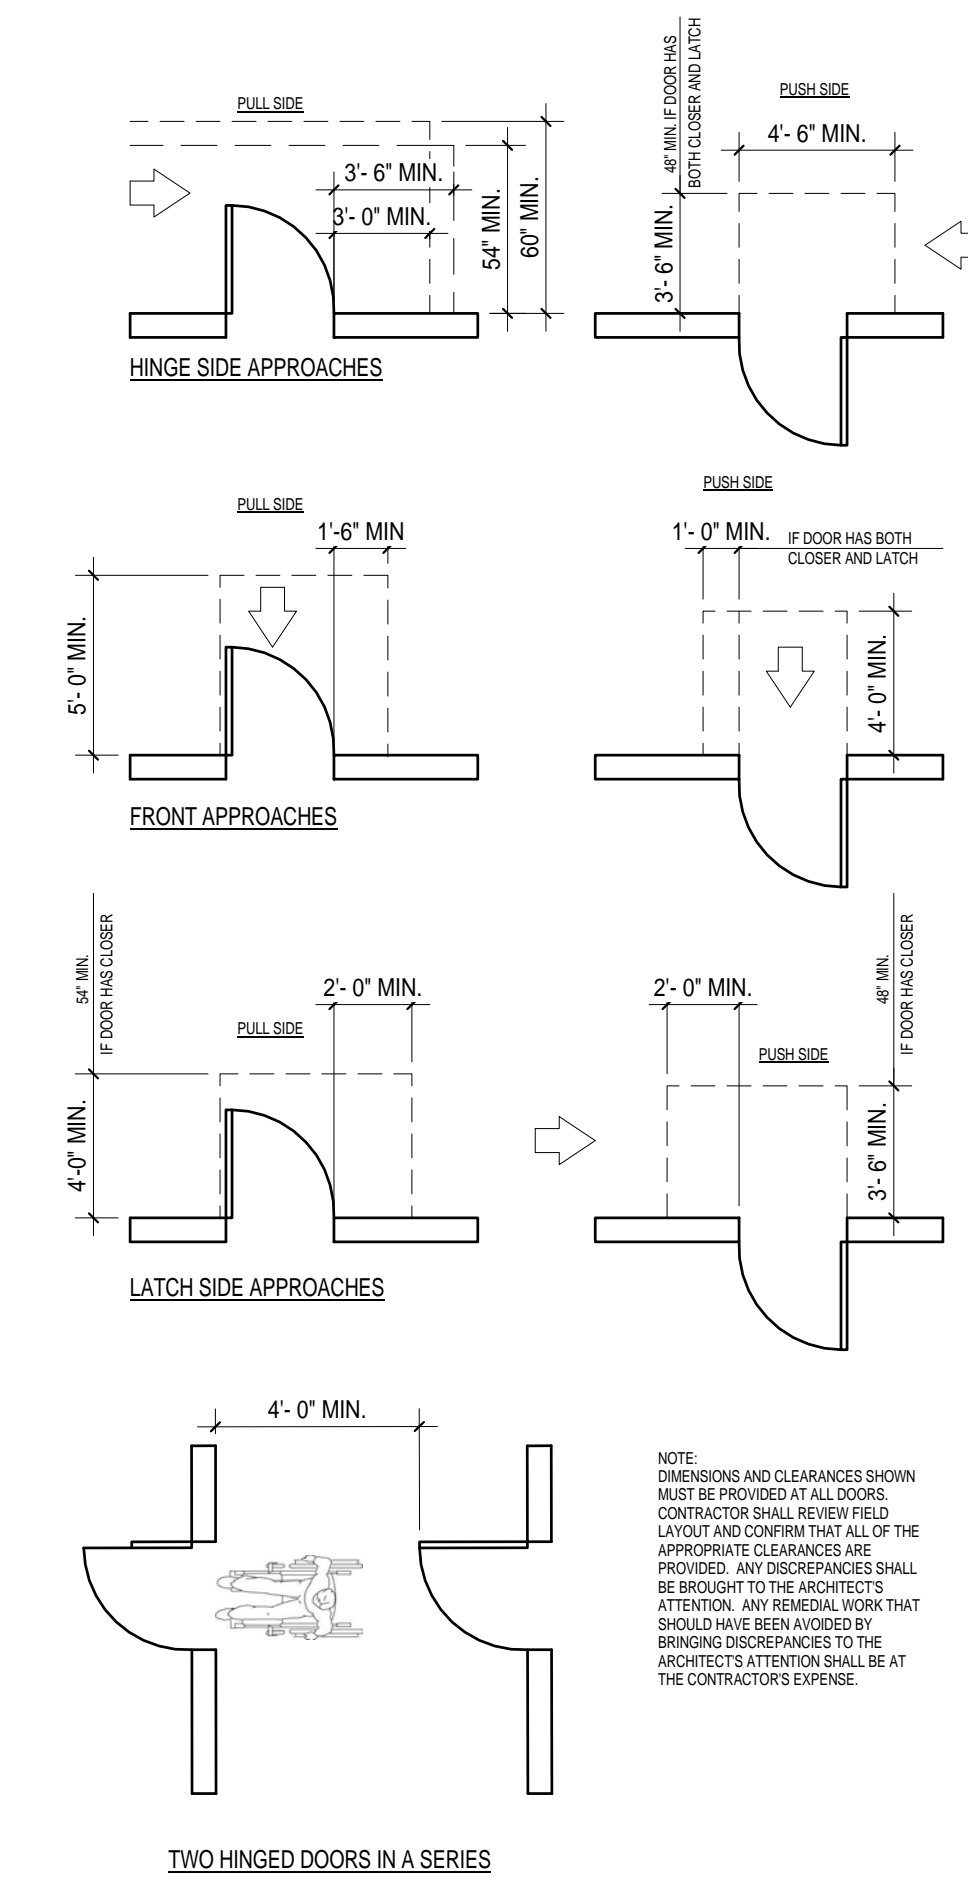

**WILLIAMS-BRICE STADIUM
VIDEO BOARD SUPPORT
CONSTRUCTION**

UNIVERSITY OF SOUTH CAROLINA
COLUMBIA, SC
STATE PROJECT NO. H27-6089-MJ

REVISIONS

NO.	NAME	DATE

TITLE SHEET

DRWING TITLE

PROJECT NO. U291.11
 DATE 12-30-11
 DRAWING NO. T1.1