


CRF DM LAW CENTER ROOF REPLACEMENT UNIVERSITY OF SOUTH CAROLINA

701 MAIN STREET
COLUMBIA, SOUTH CAROLINA
STATE PROJECT NO. H27-6094-F

DRAWING INDEX

SHEET NO.	DRAWING TITLE
R1	EXISTING ROOF PLAN
R2	NEW ROOF PLAN—AREA "A"
R3	DETAILS—AREA "A"
R4	NEW ROOF PLAN—AREA "B"
R5	NEW ROOF PLAN—AREA "D"
R6	SECTIONS—AREA "D"

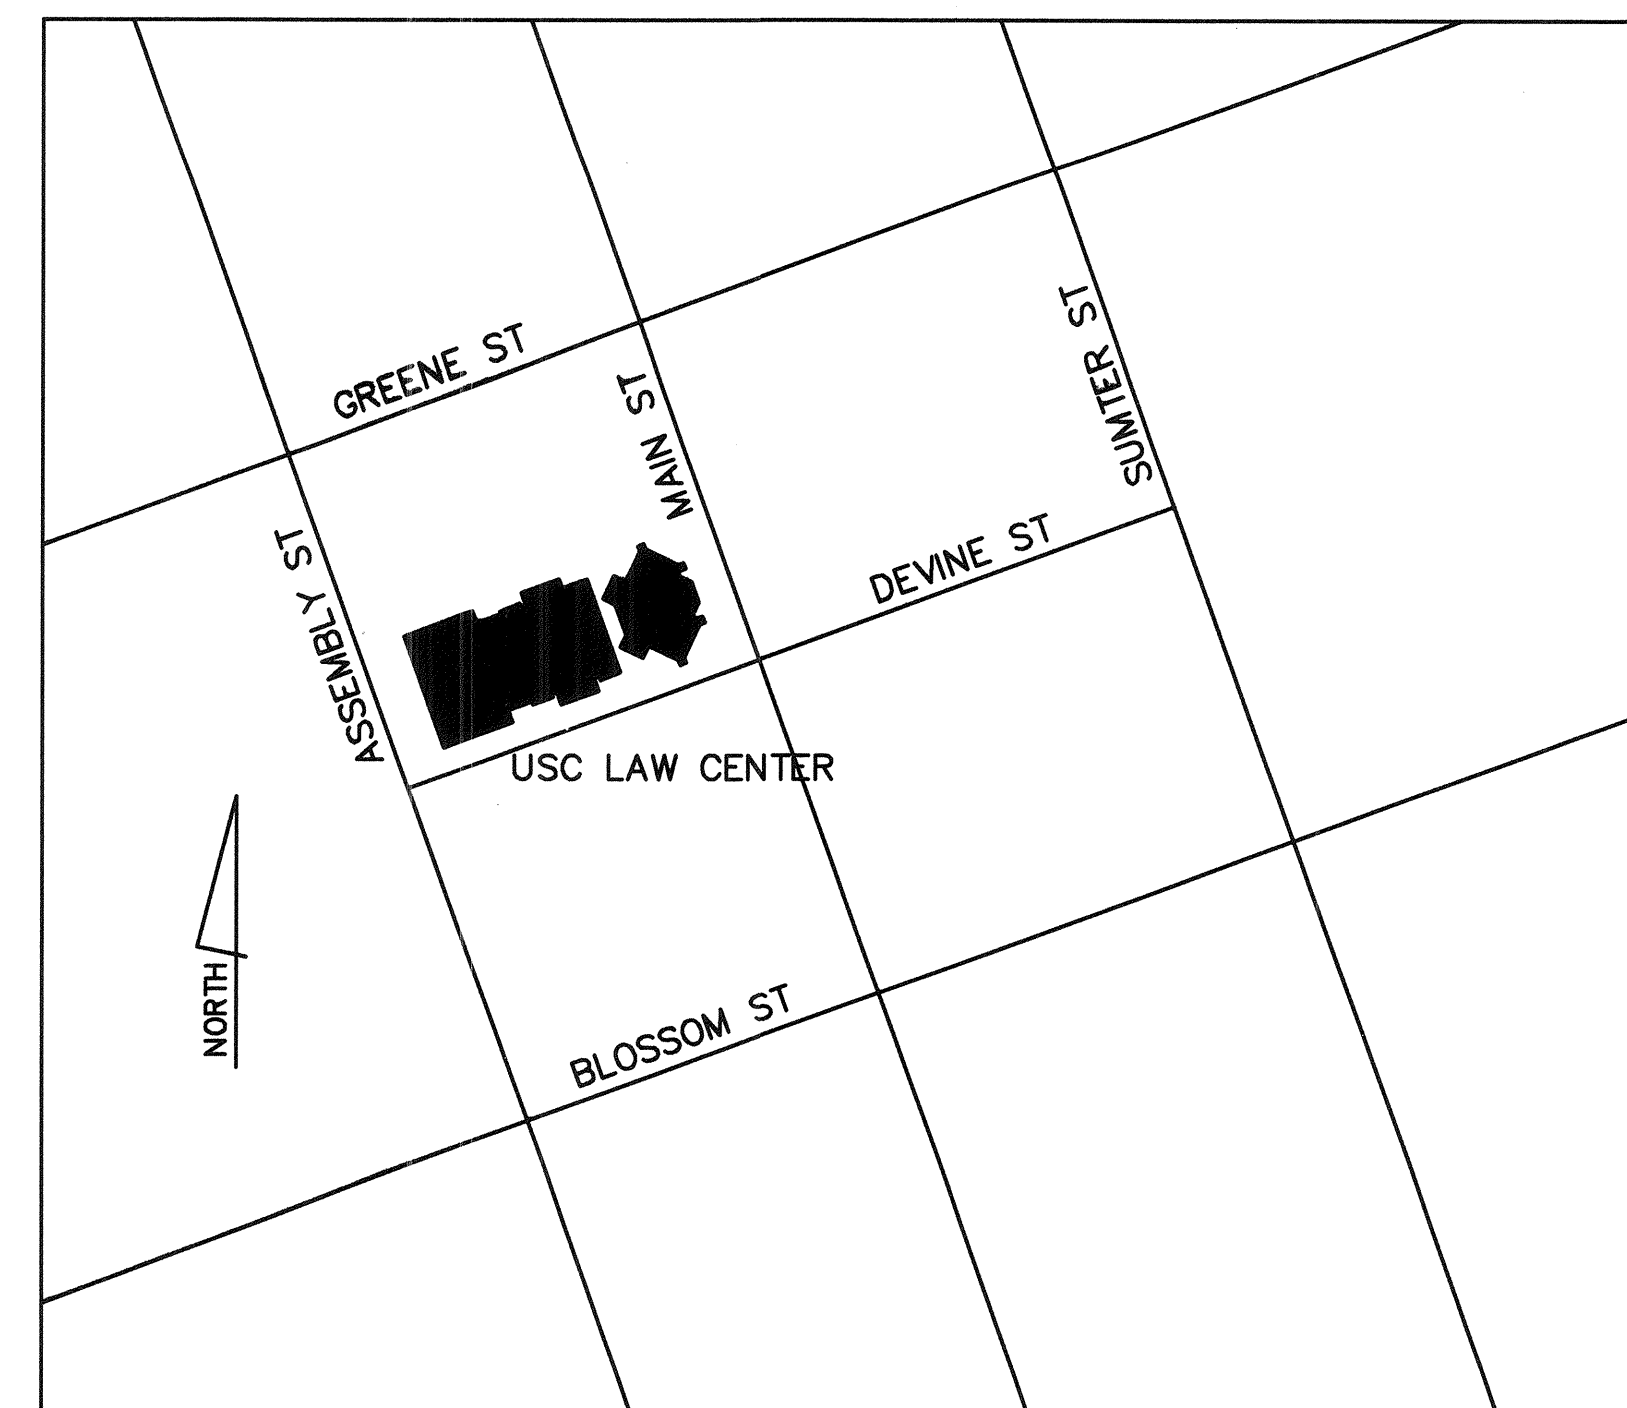


LOCATION MAP

FLOYD ABRAMS CO.
P.O. BOX 6136
COLUMBIA, SOUTH CAROLINA 29260-6136
(803) 343-1272


LEGEND

- ⊗ ROOF DRAIN
- EF □ EXHAUST FAN
- VP ● VENT PIPE
- LADDER
- S SCUPPER
- PP PITCH PAN

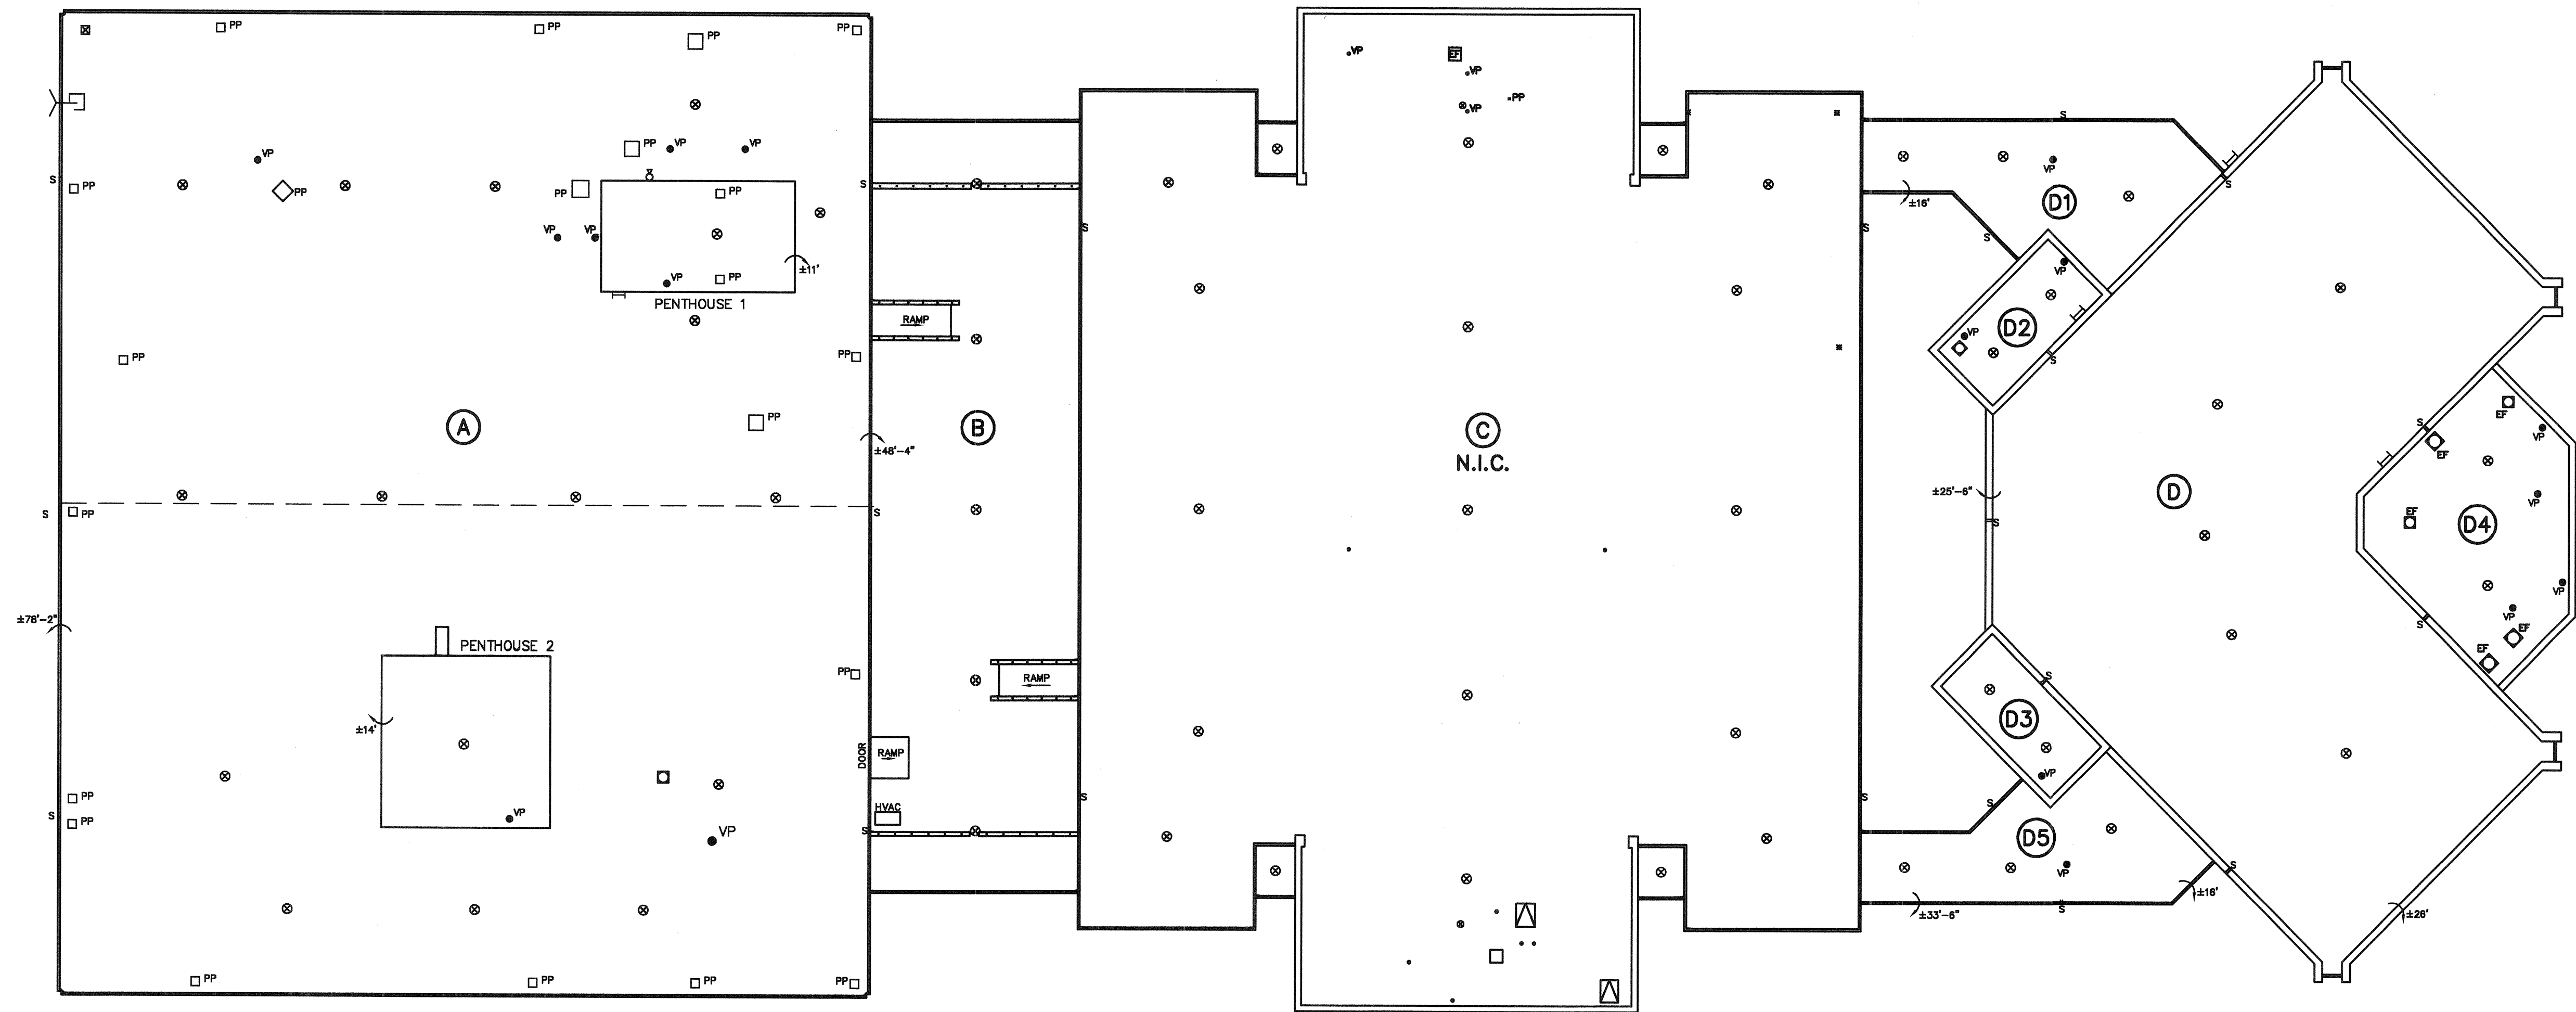

EXISTING ROOF PLAN
SCALE: 1/16"=1'-0"



NORTH








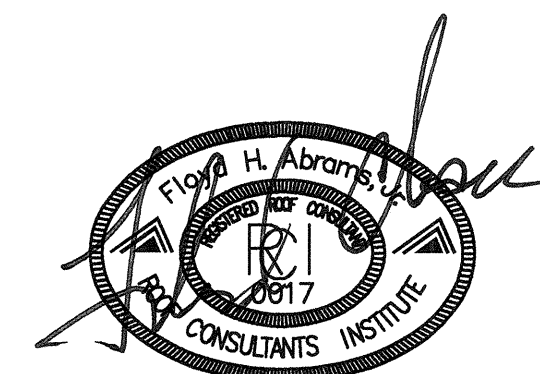


REV. NO.	DESCRIPTION	DATE
CRF DM LAW CENTER ROOF REPLACEMENT UNIVERSITY OF SOUTH CAROLINA EXISTING ROOF PLAN STATE PROJECT NO. H27-6094-F USC PROJECT NO. CP00336850 COLUMBIA, SOUTH CAROLINA		
FLOYD ABRAMS COMPANY COLUMBIA, SOUTH CAROLINA		Roof Consulting Services
SCALE: 1/16"=1'-0"	DRAWN BY: JDL	CHECKED BY: FA
PROJECT NO: 12.0100	DATE: 3/27/2012	SHEET R1 OF 6





REV. NO.	DESCRIPTION	DATE
	CRF DM LAW CENTER ROOF REPLACEMENT UNIVERSITY OF SOUTH CAROLINA NEW ROOF PLAN-AREA "A" STATE PROJECT NO. H27-6094-F USC PROJECT NO. CP00336850 COLUMBIA, SOUTH CAROLINA	
FLOYD ABRAMS COMPANY COLUMBIA, SOUTH CAROLINA		Roof Consulting Services
SCALE: 1/8"=1'-0"	DRAWN BY: JDL	CHECKED BY: FA
PROJECT NO: 12.0100	DATE: 3/27/2012	SHEET R2 OF 6

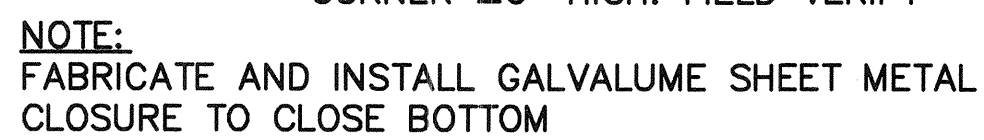 


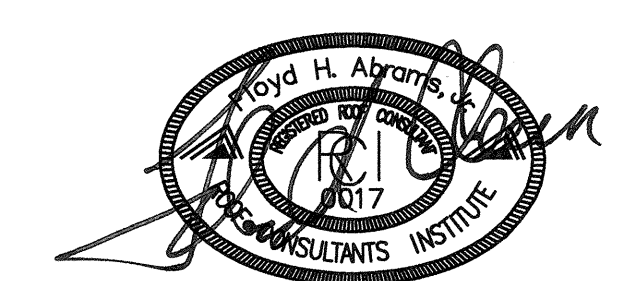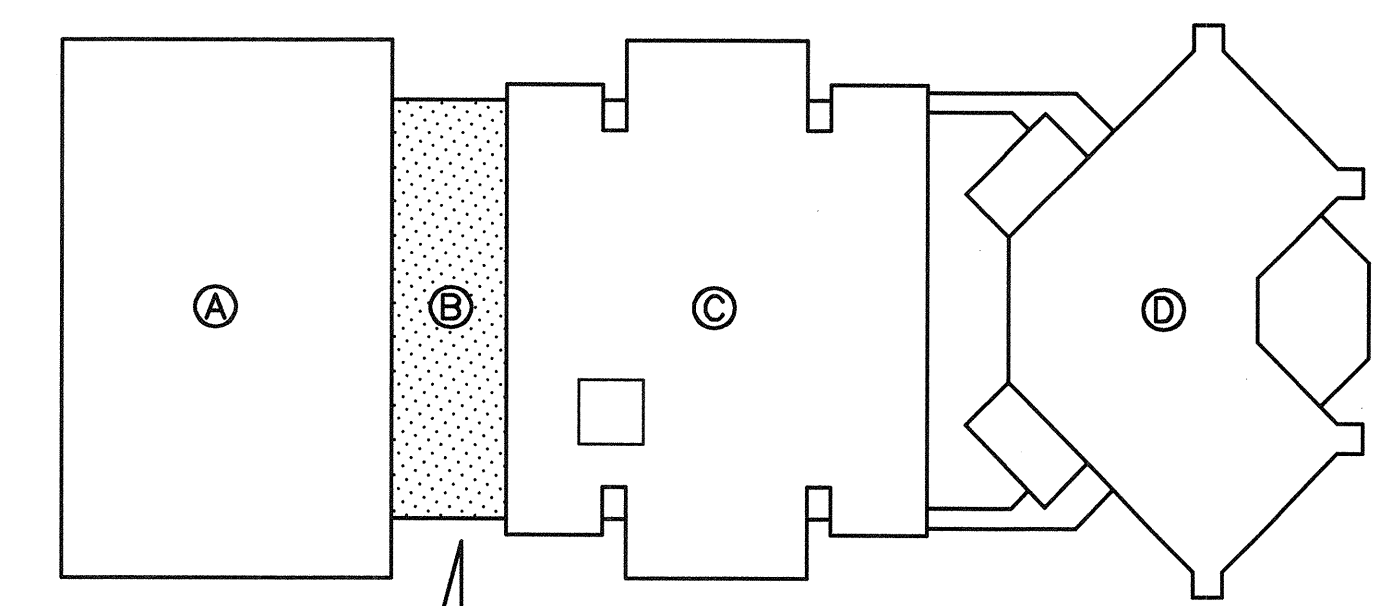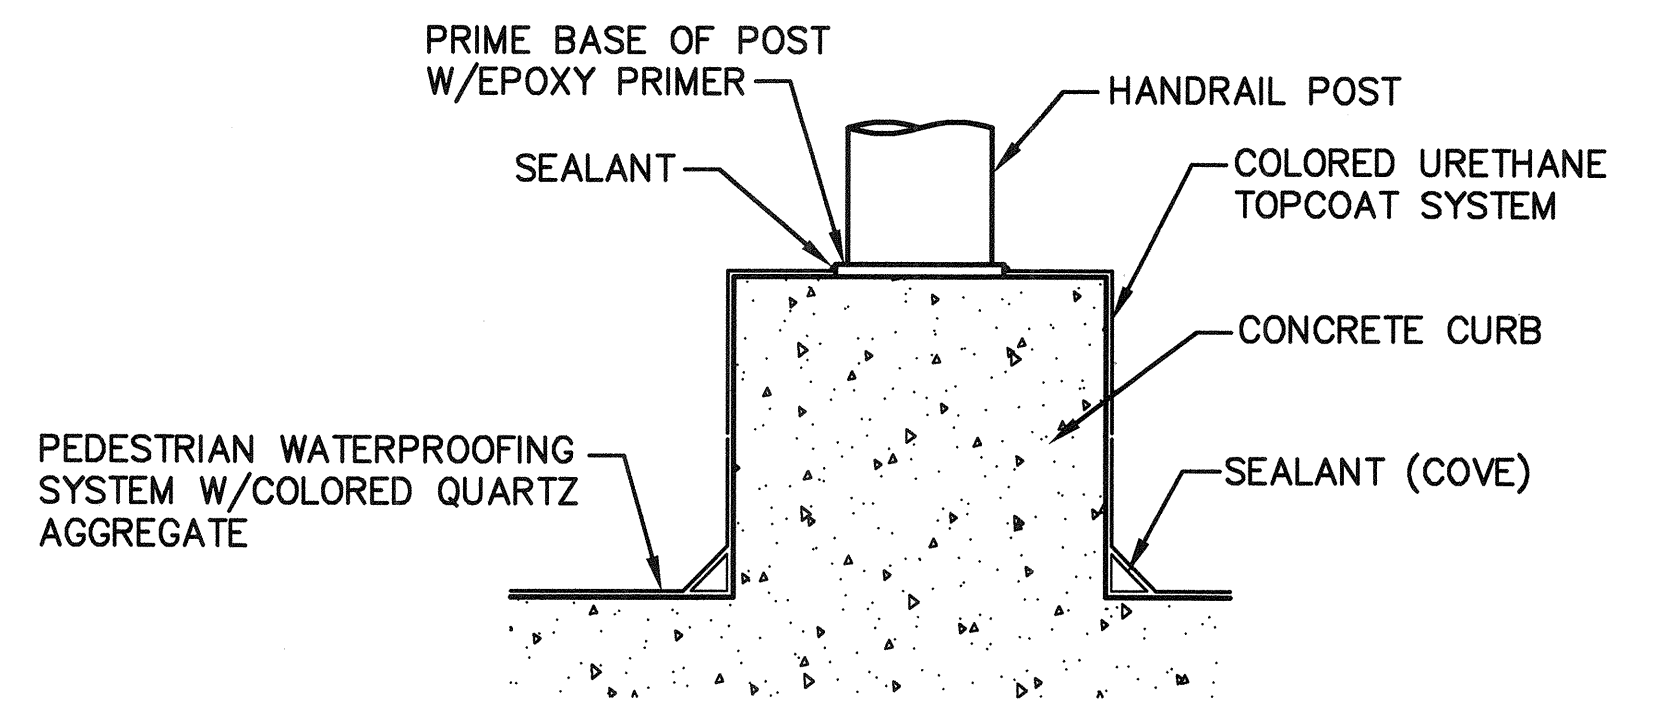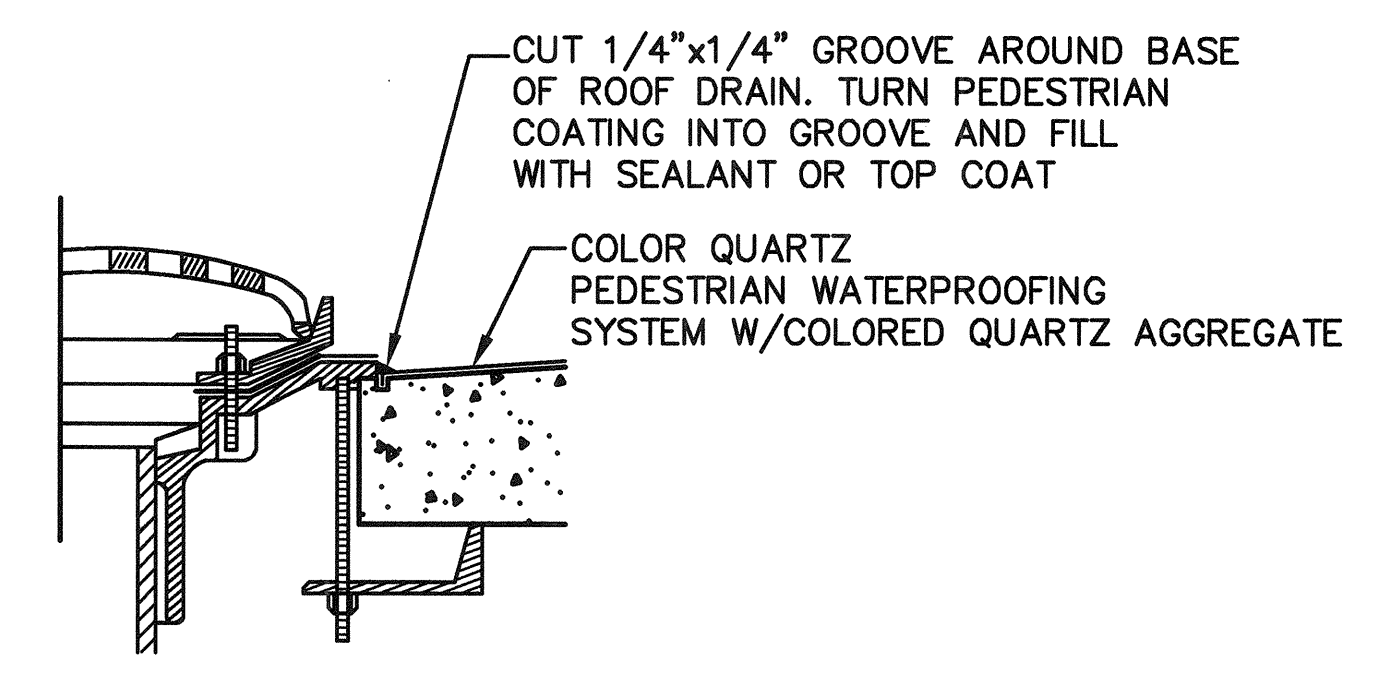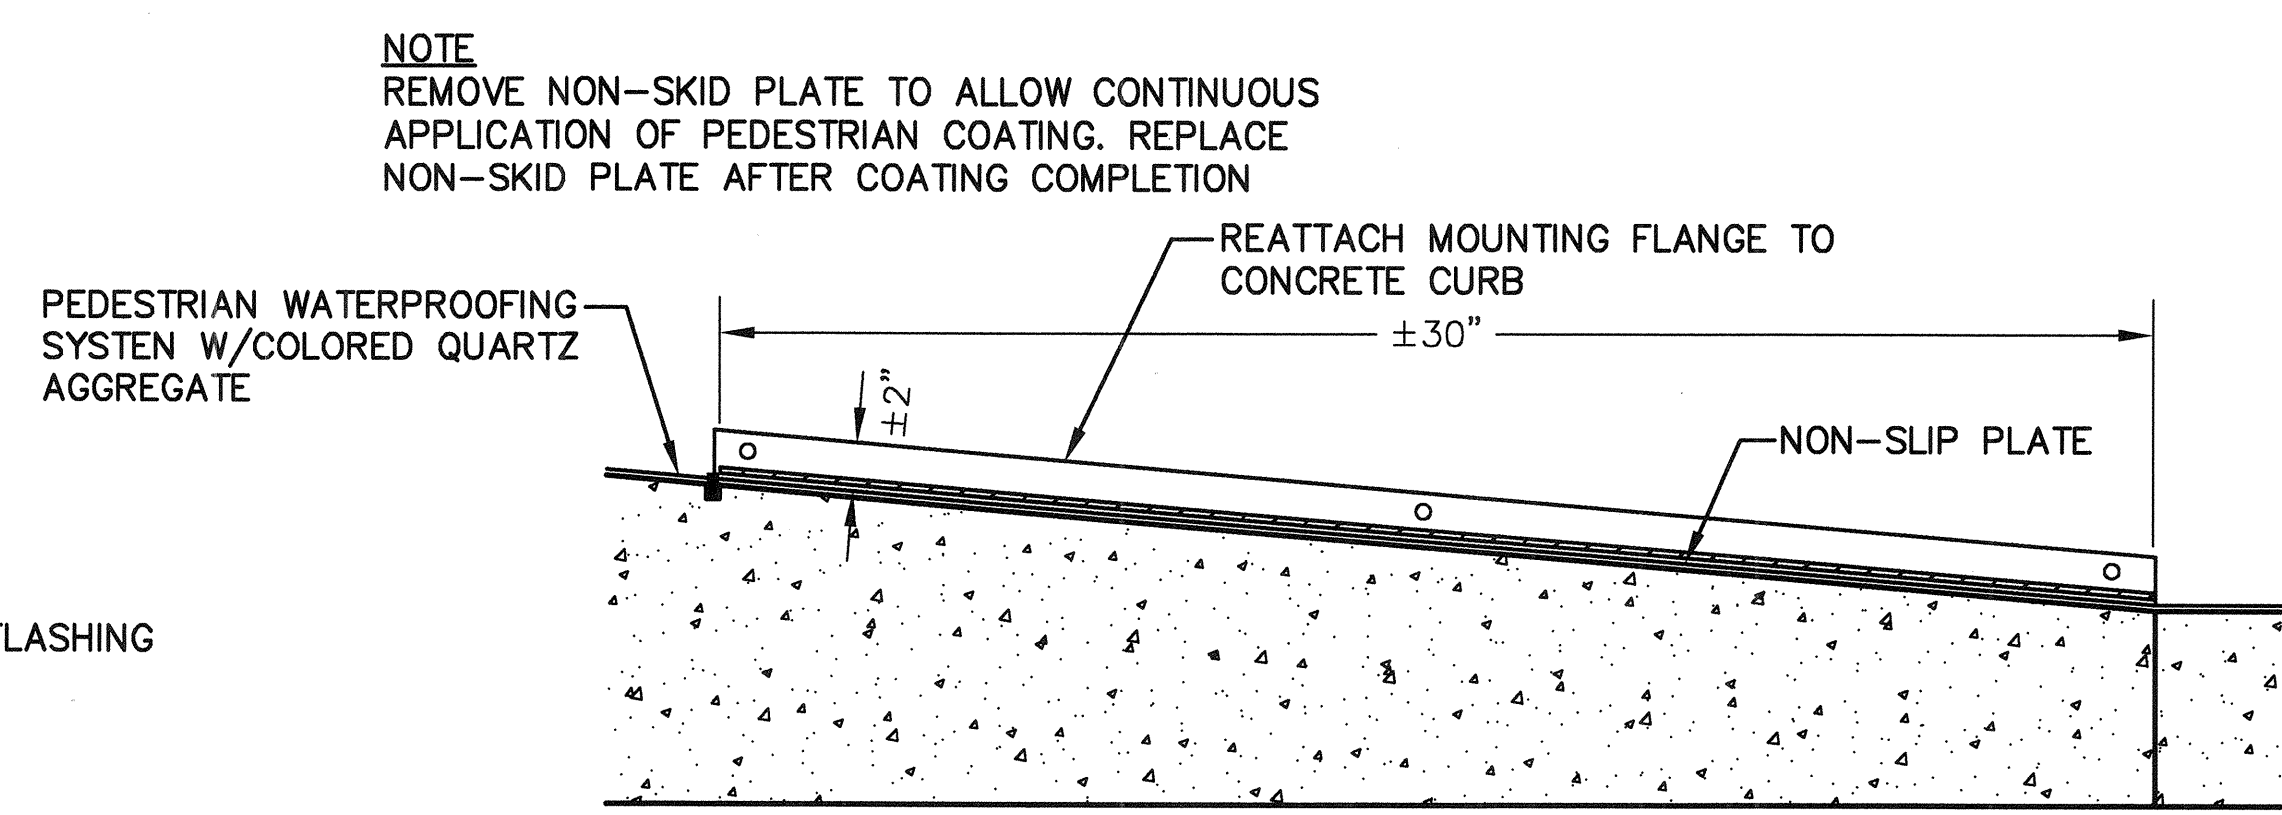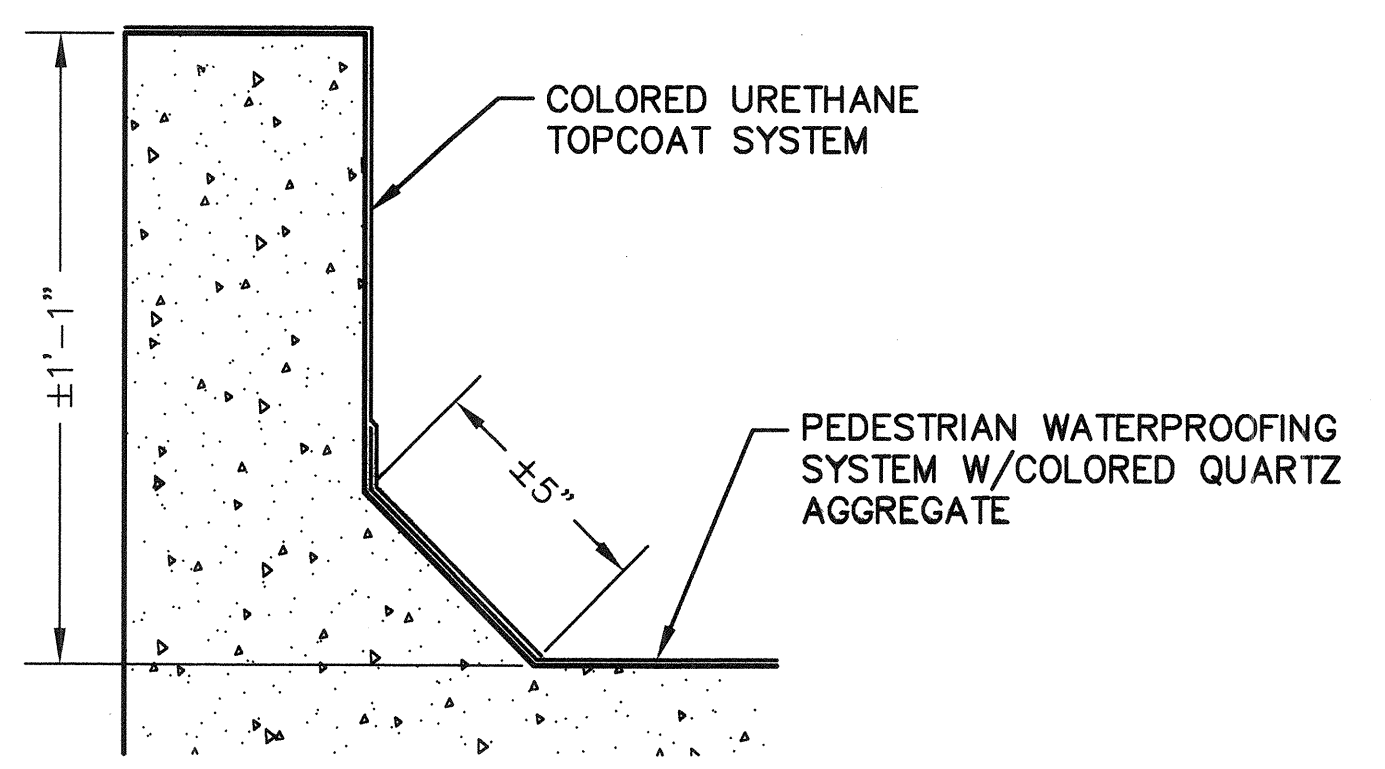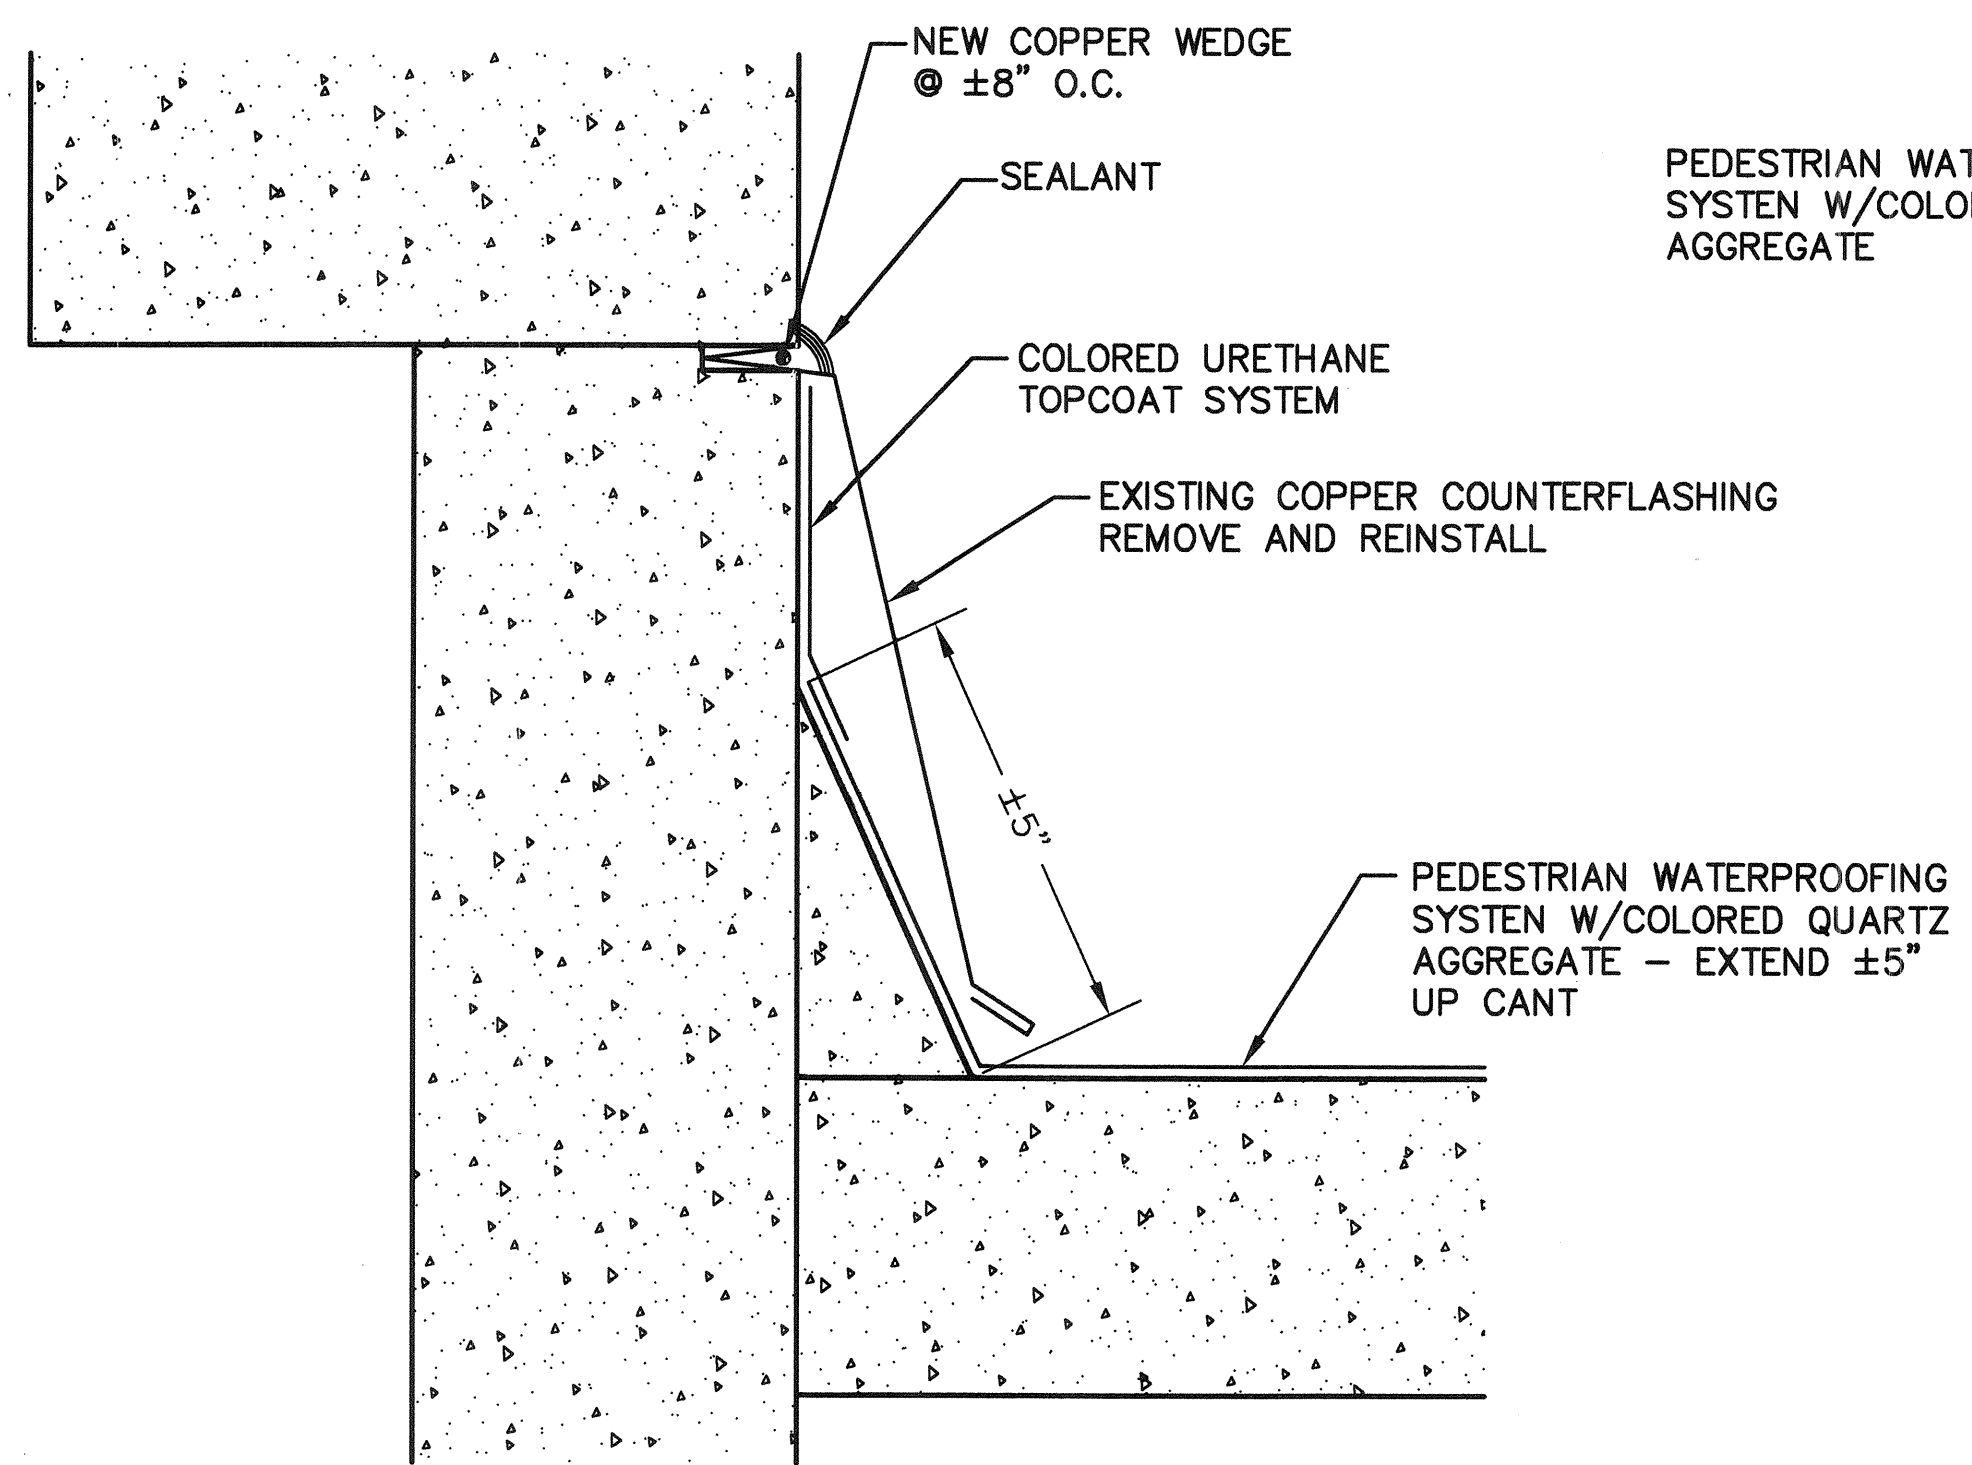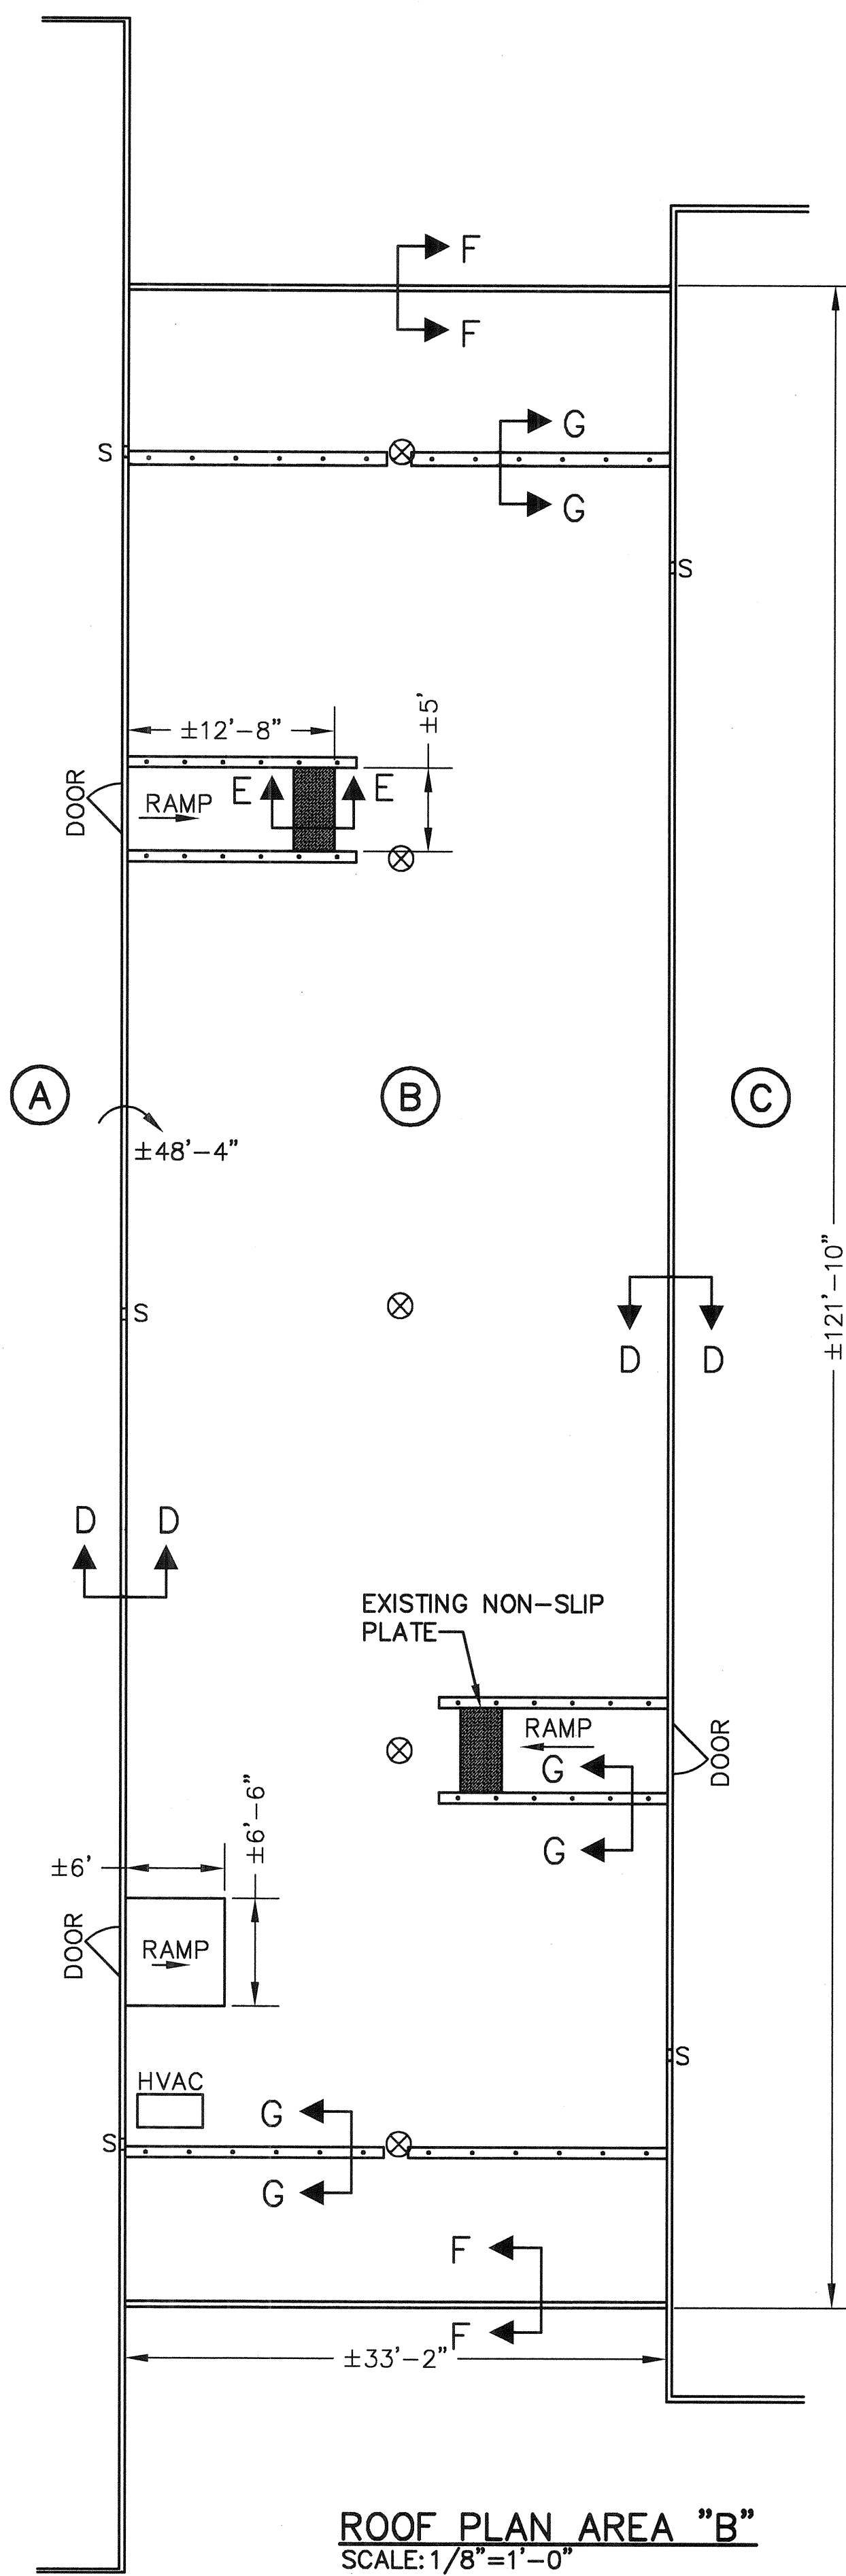


REV. NO.	DESCRIPTION	DATE
	CRF DM LAW CENTER ROOF REPLACEMENT UNIVERSITY OF SOUTH CAROLINA NEW ROOF PLAN-AREA "B" STATE PROJECT NO. H27-6094-F USC PROJECT NO. CP00336850 COLUMBIA, SOUTH CAROLINA	
	FLOYD ABRAMS COMPANY COLUMBIA, SOUTH CAROLINA	Roof Consulting Services
SCALE: 1/8"=1'-0"	DRAWN BY: JDL	CHECKED BY: FA
PROJECT NO: 12.0100	DATE: 3/27/2012	SHEET R4 OF 6

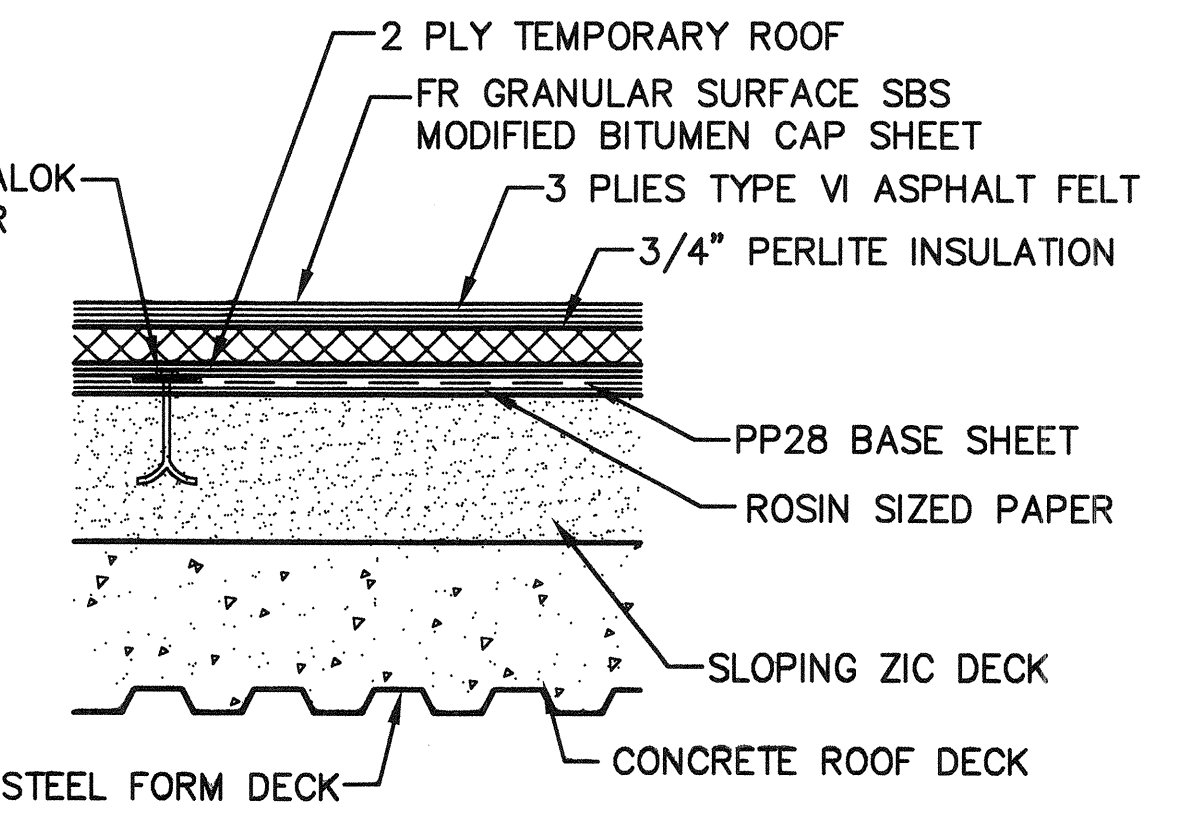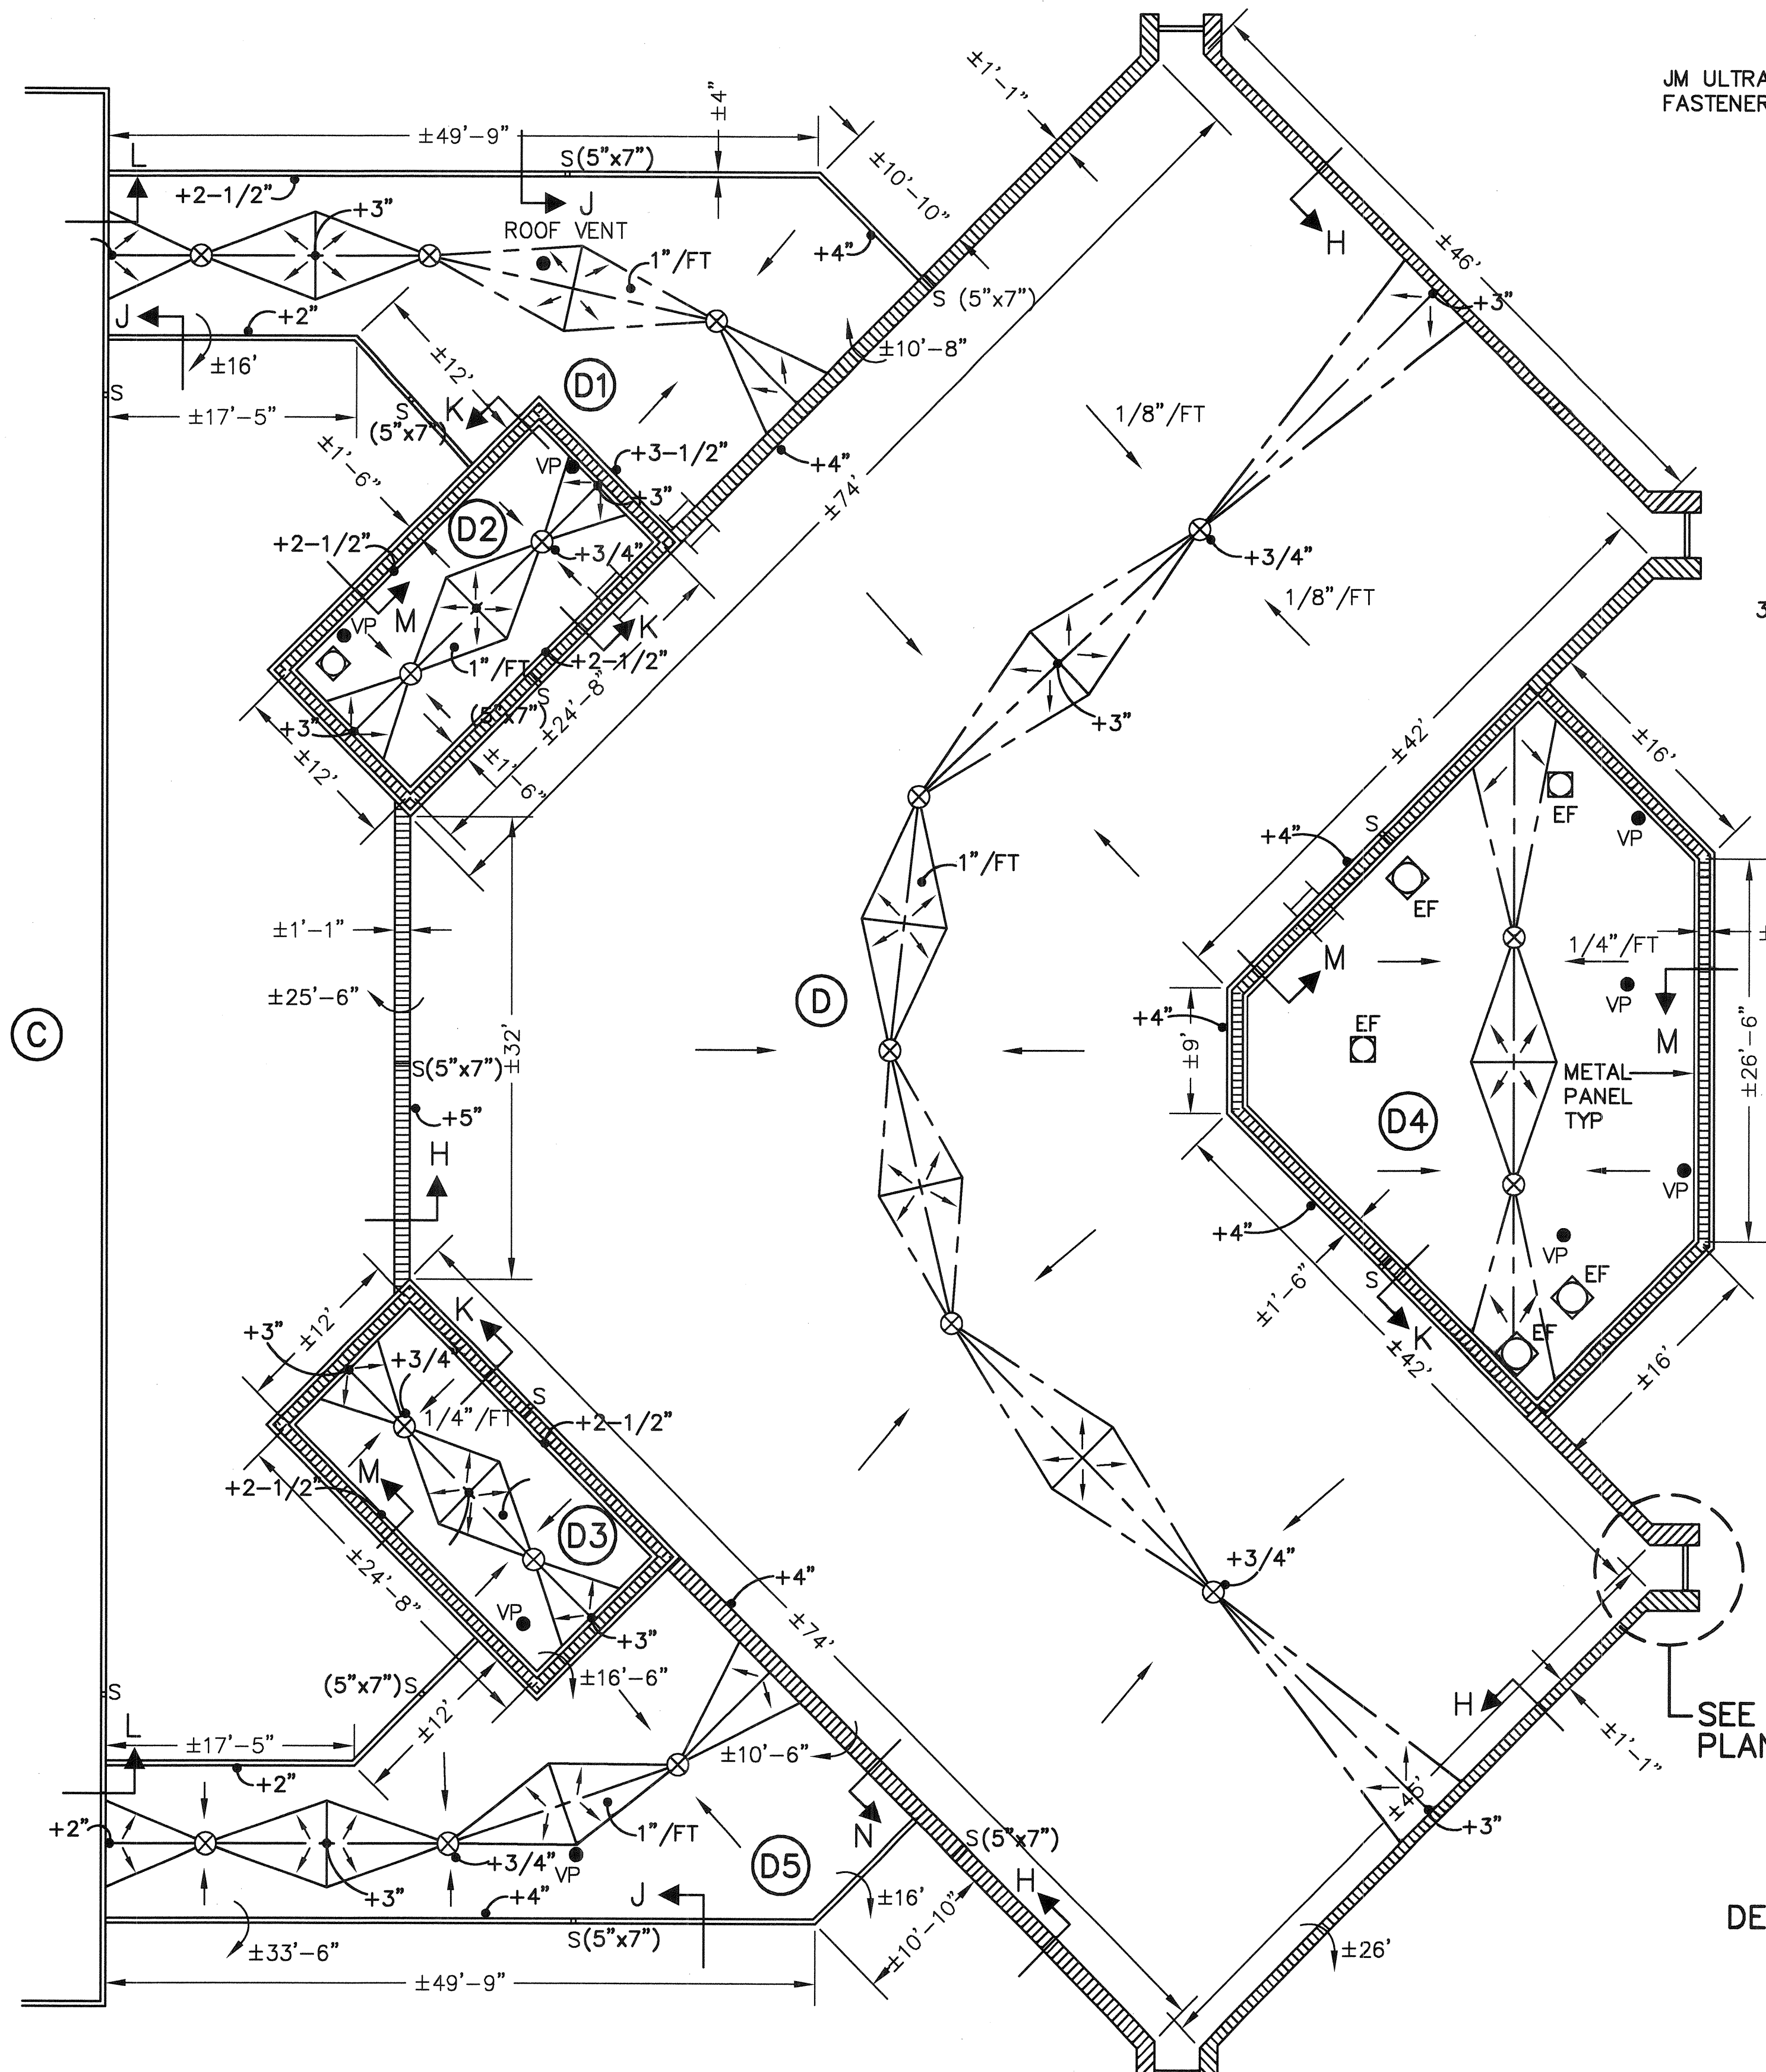


TYPICAL ROOF "D" ASSEMBLY
NTS

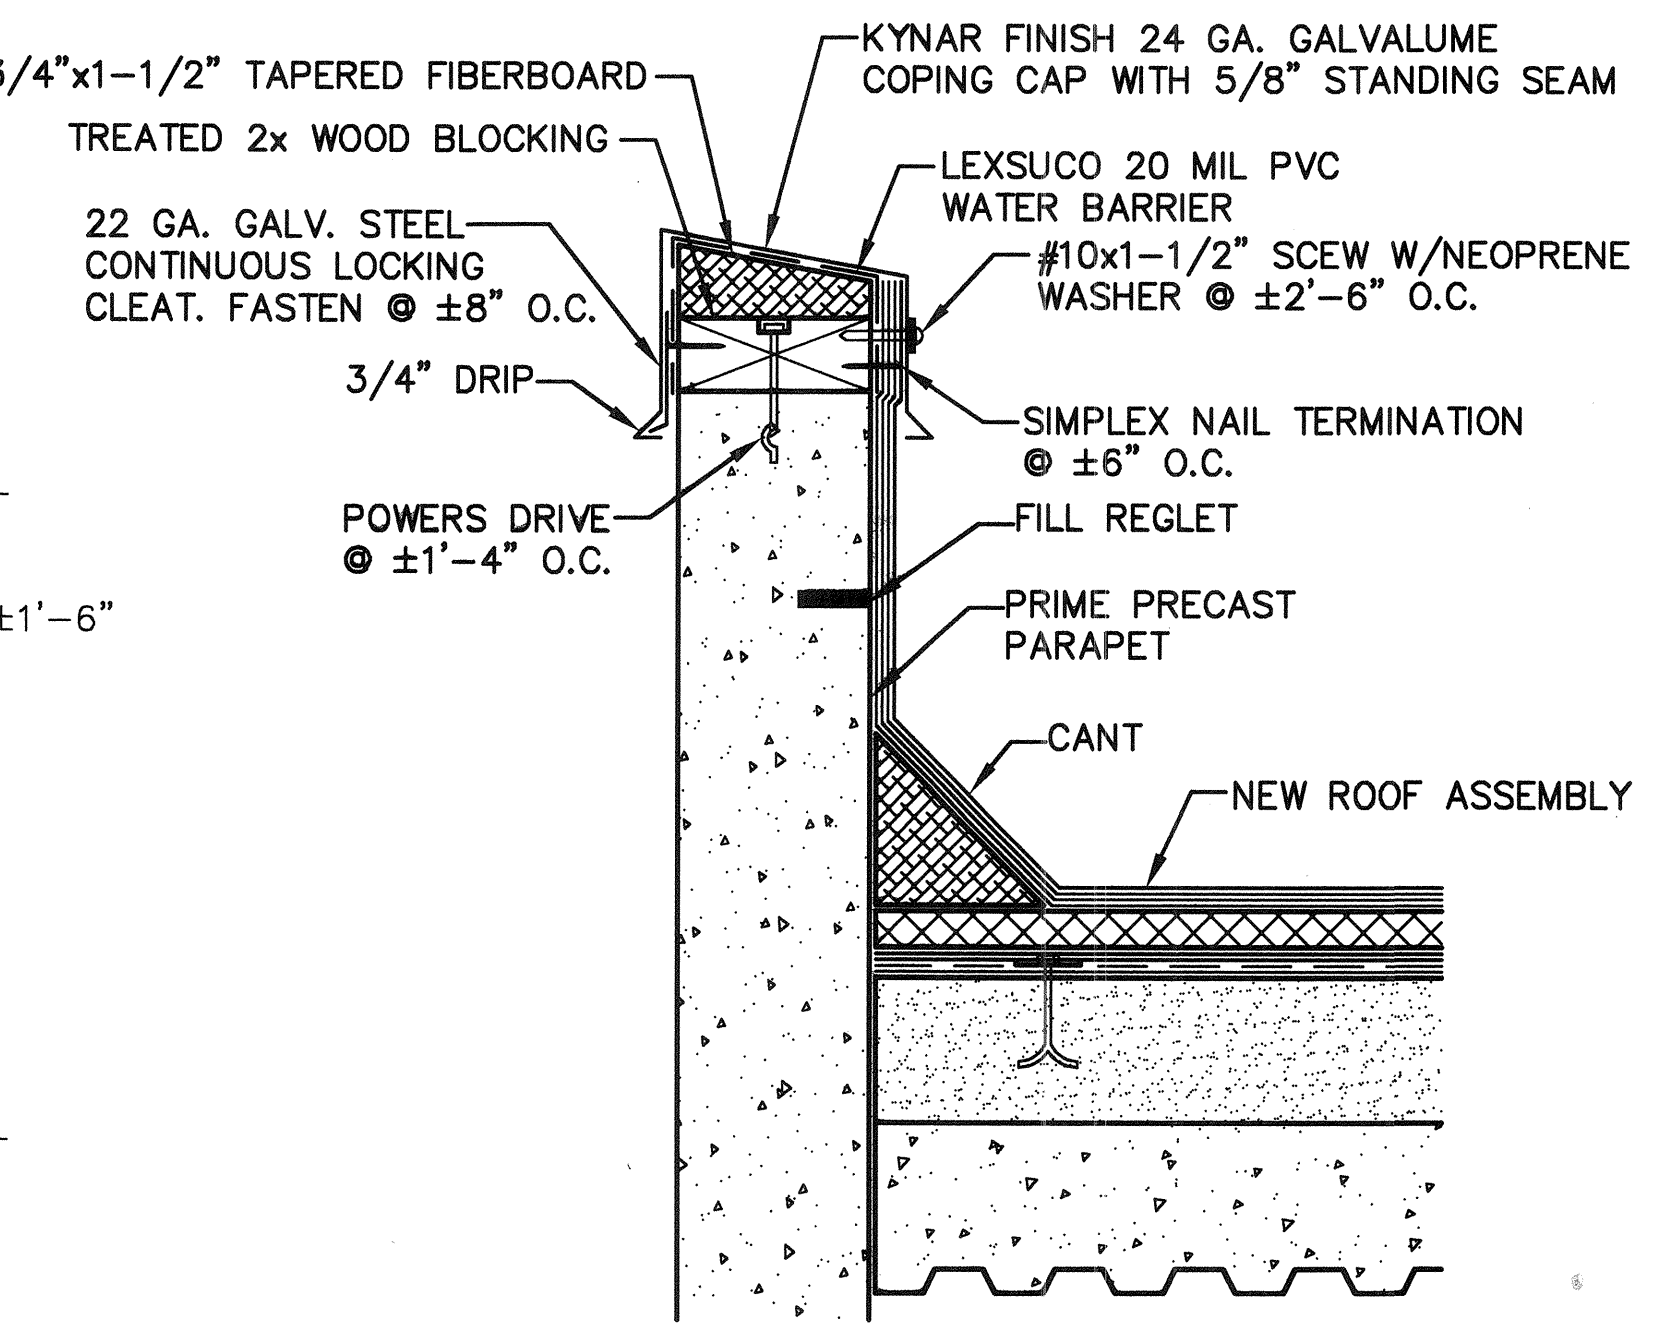


SECTION J-J
NTS

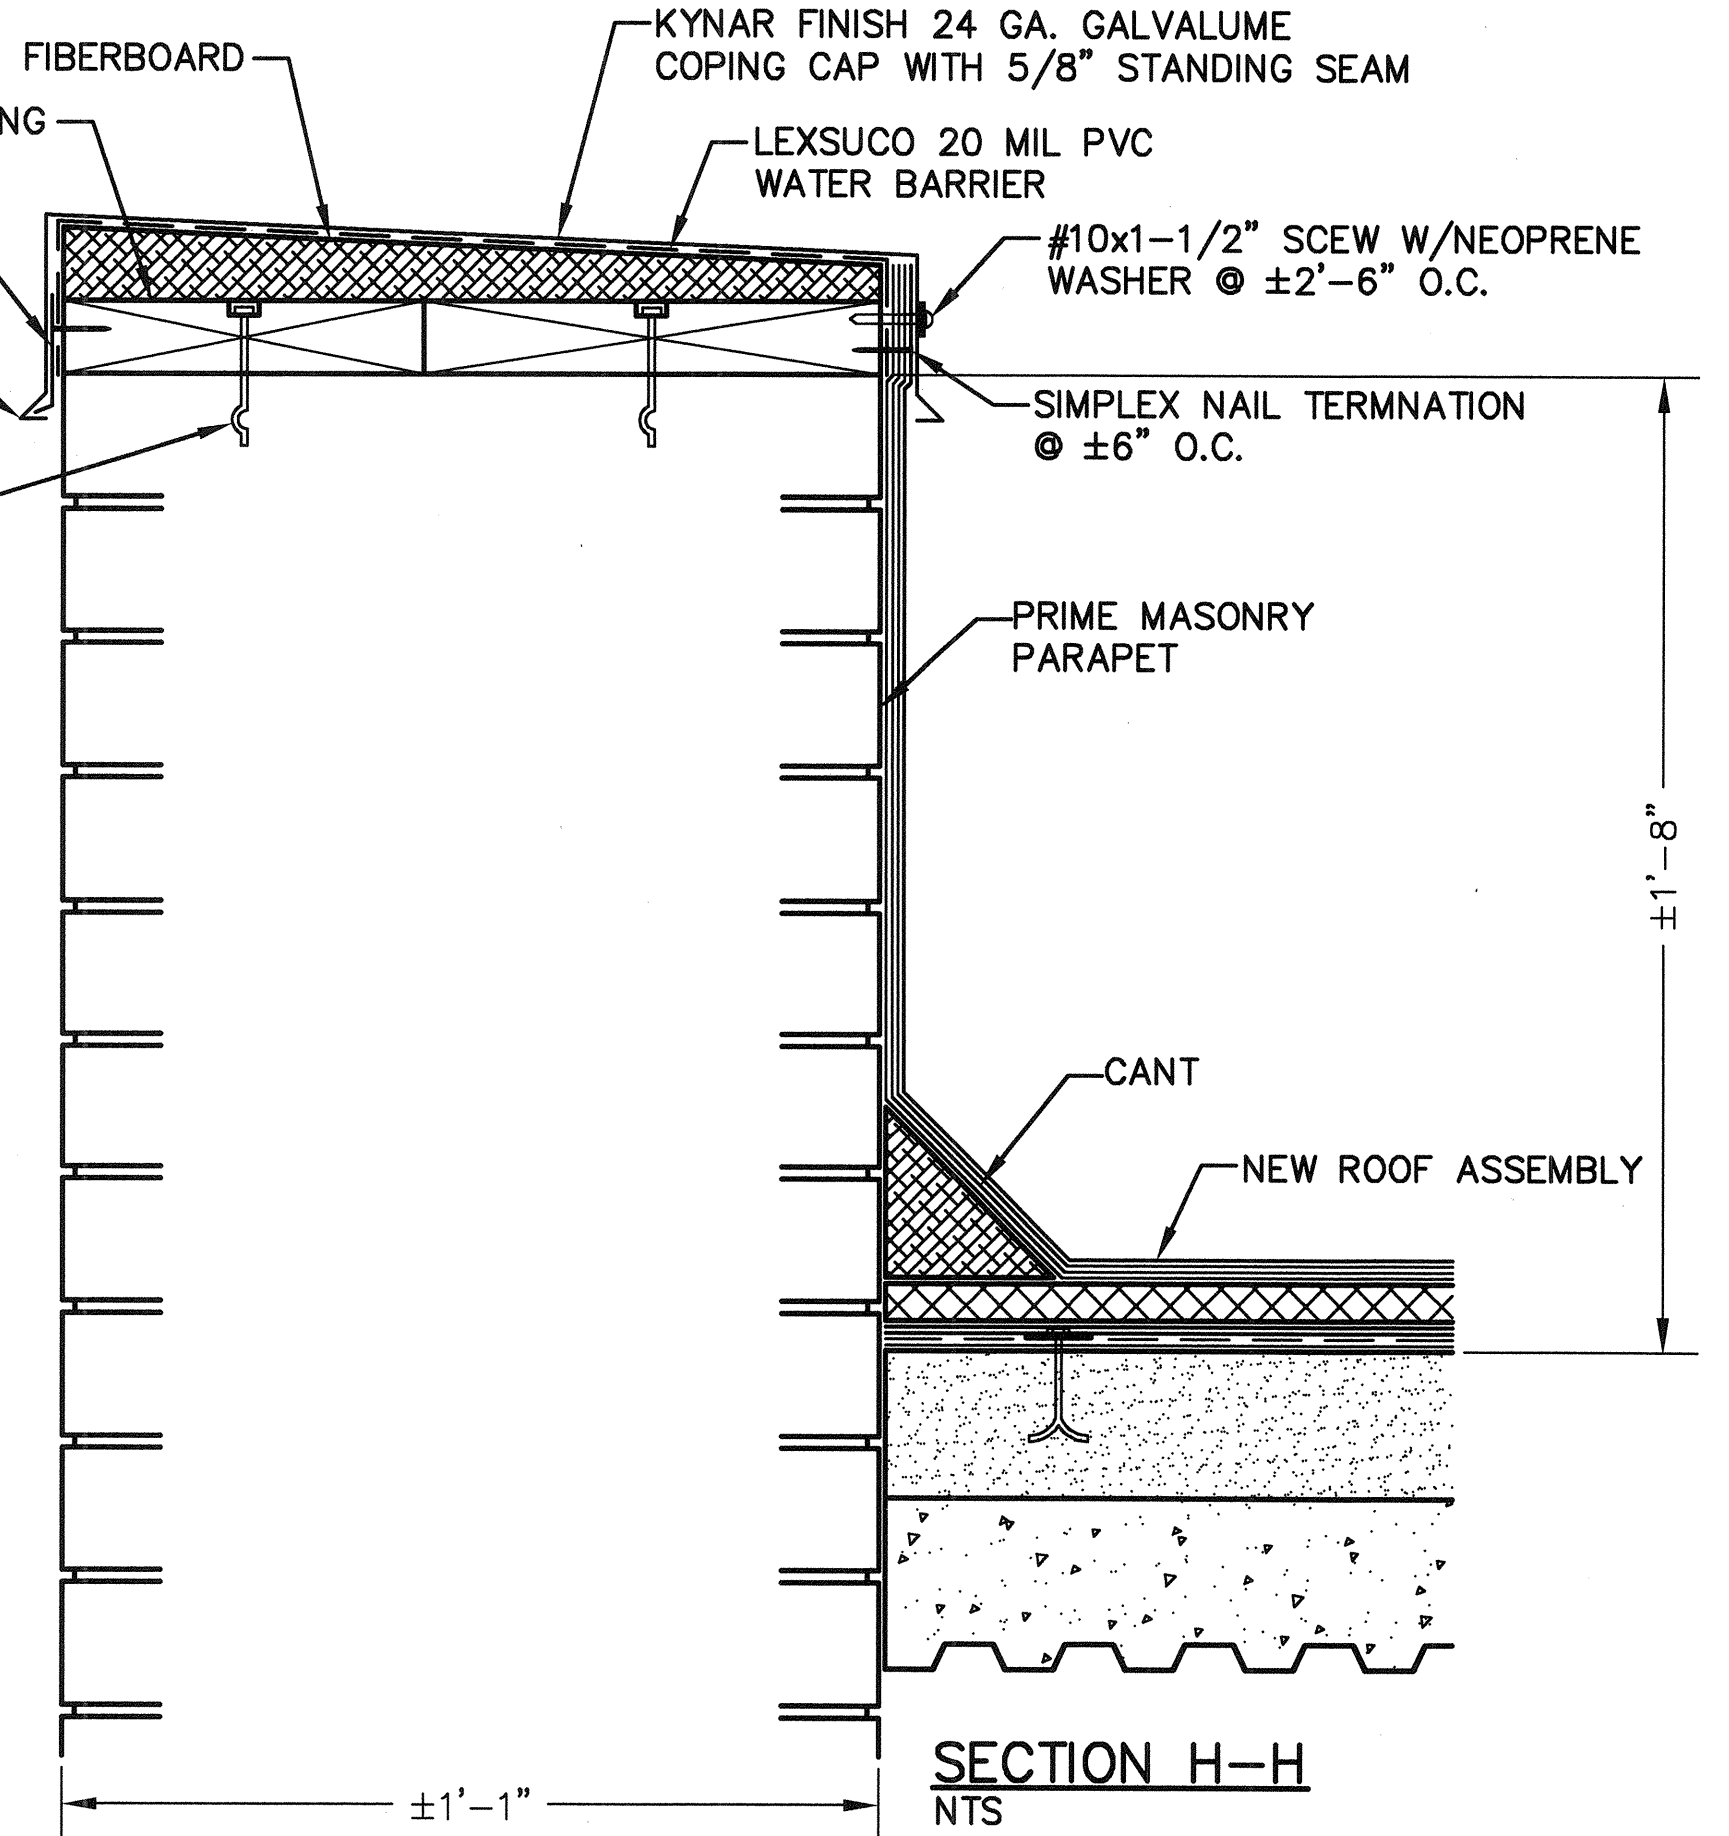


SECTION H-H
NTS

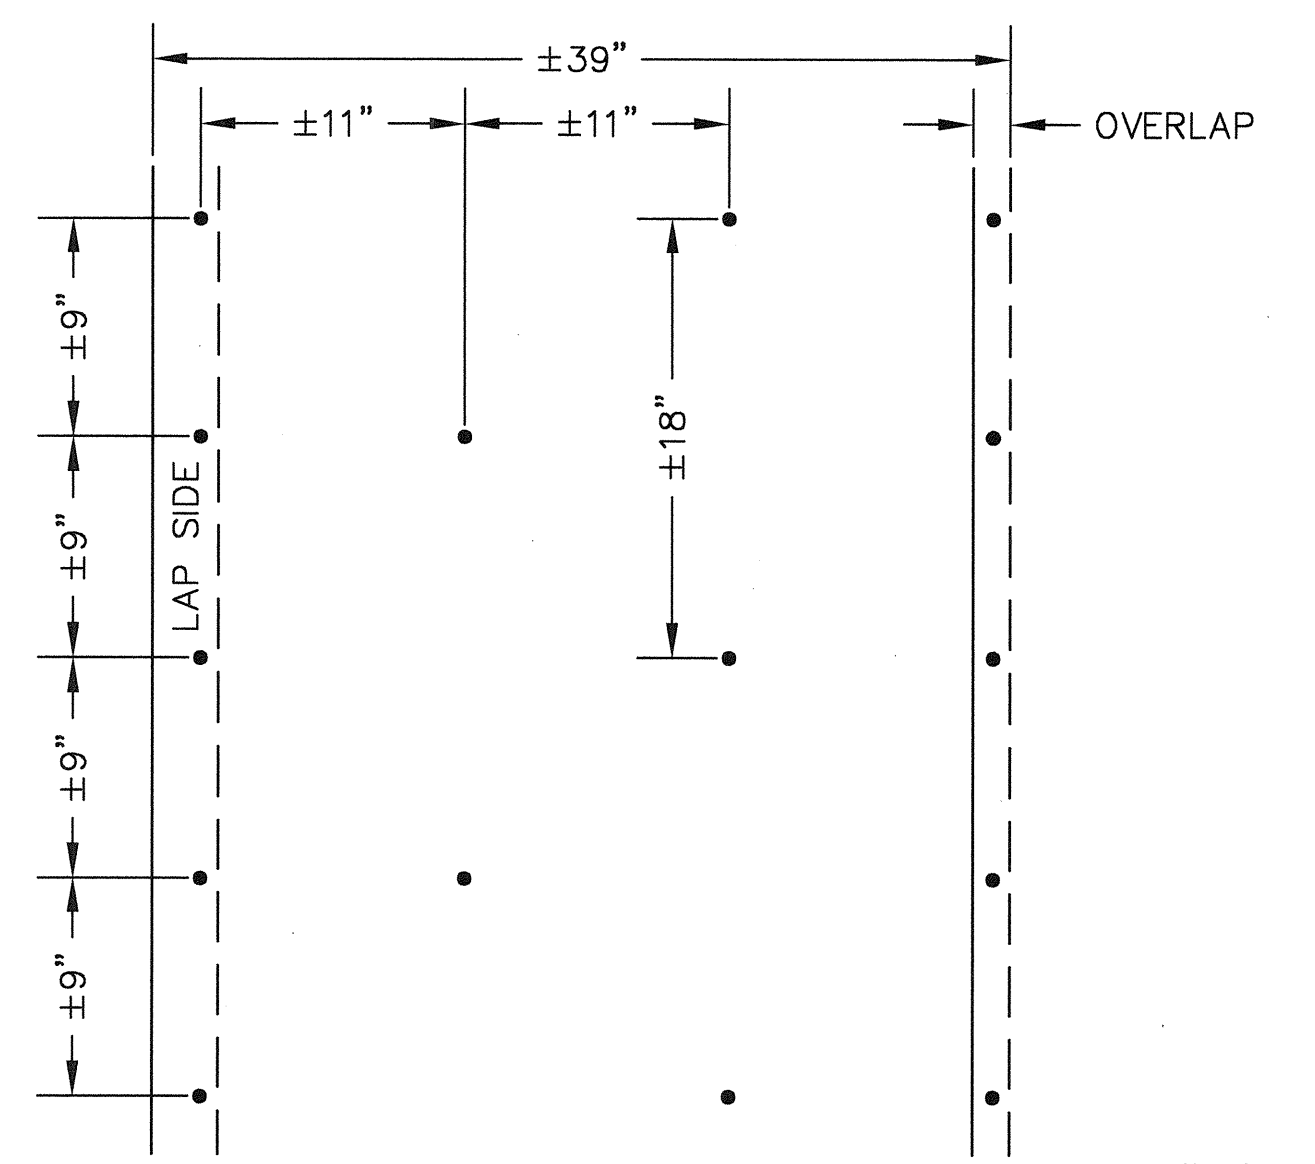

BASE SHEET FASTENER PATTERN AREA "D"
NTS

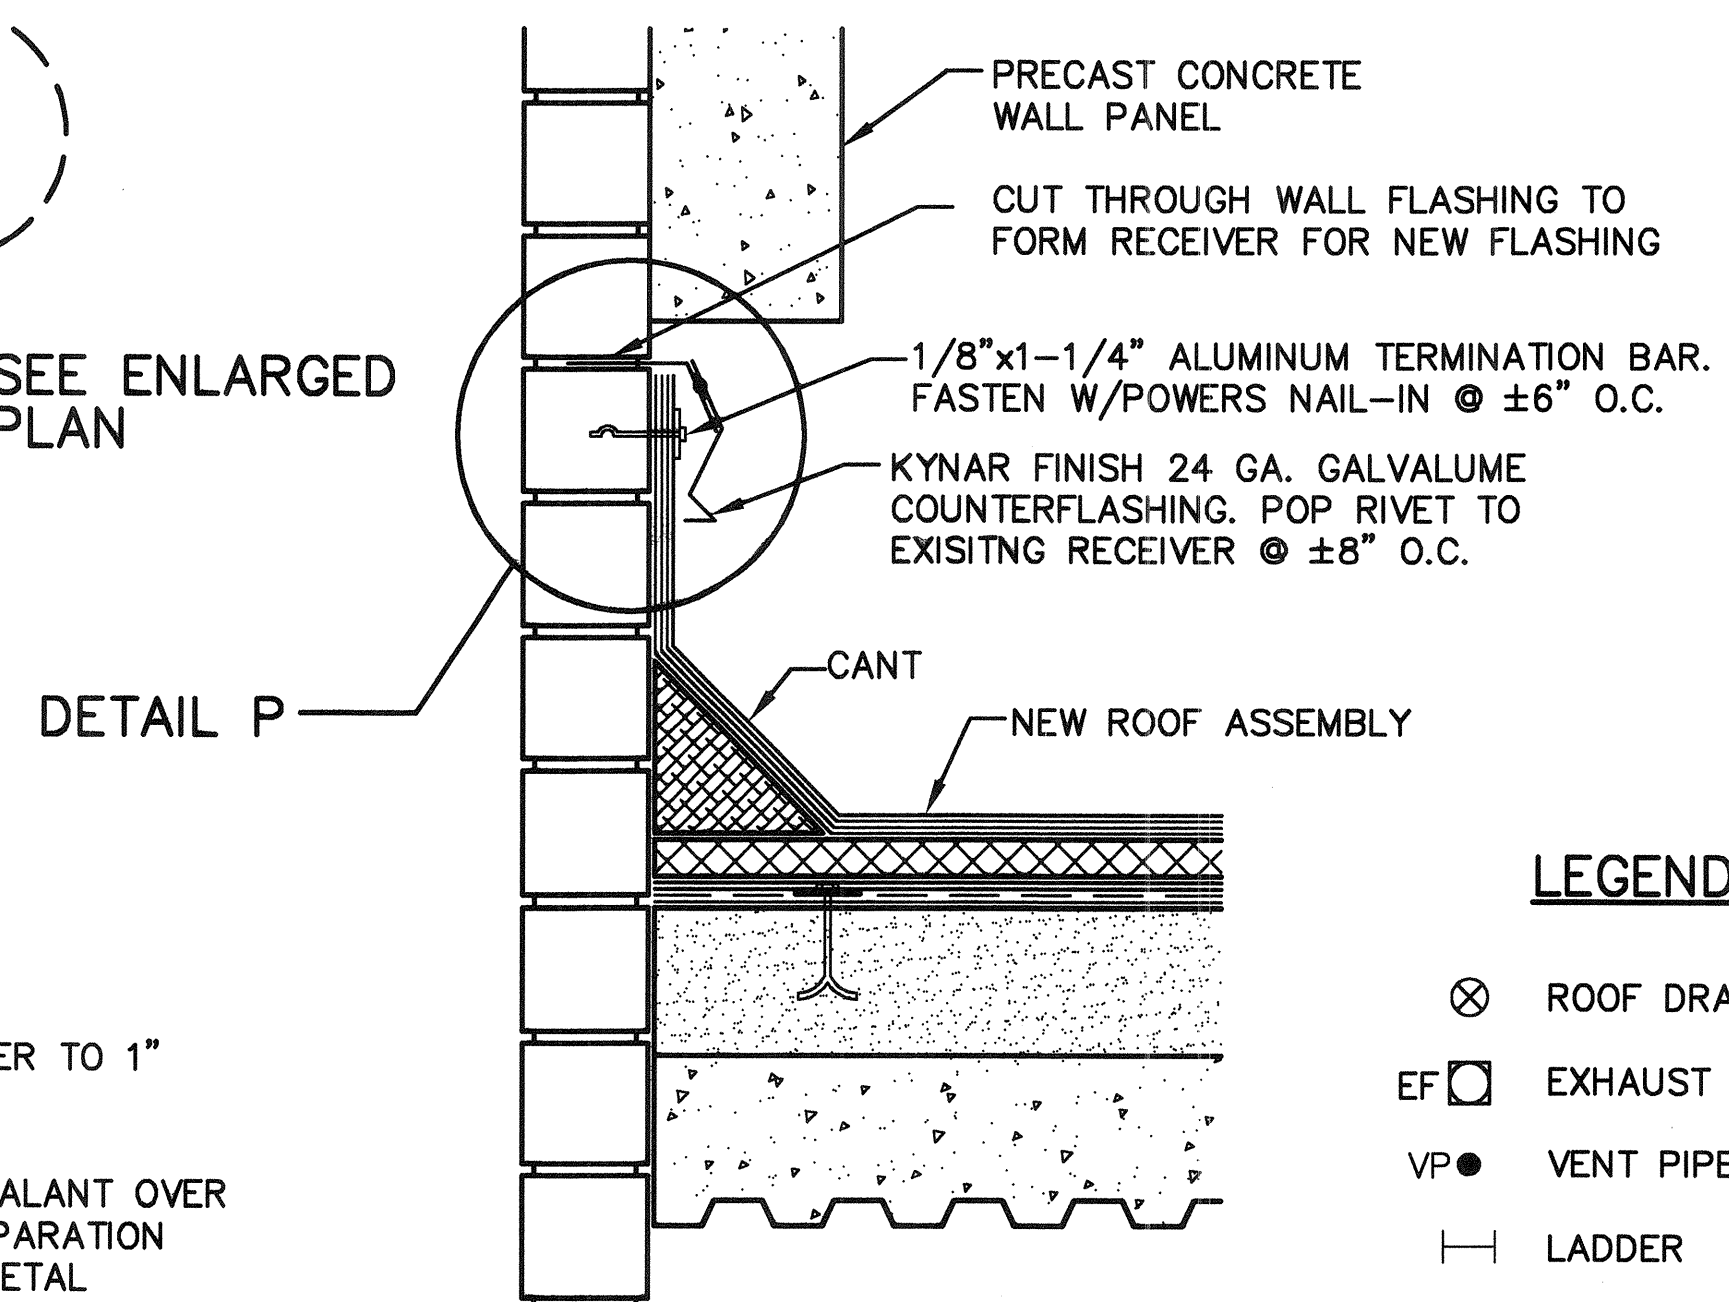



DETAIL P
NTS

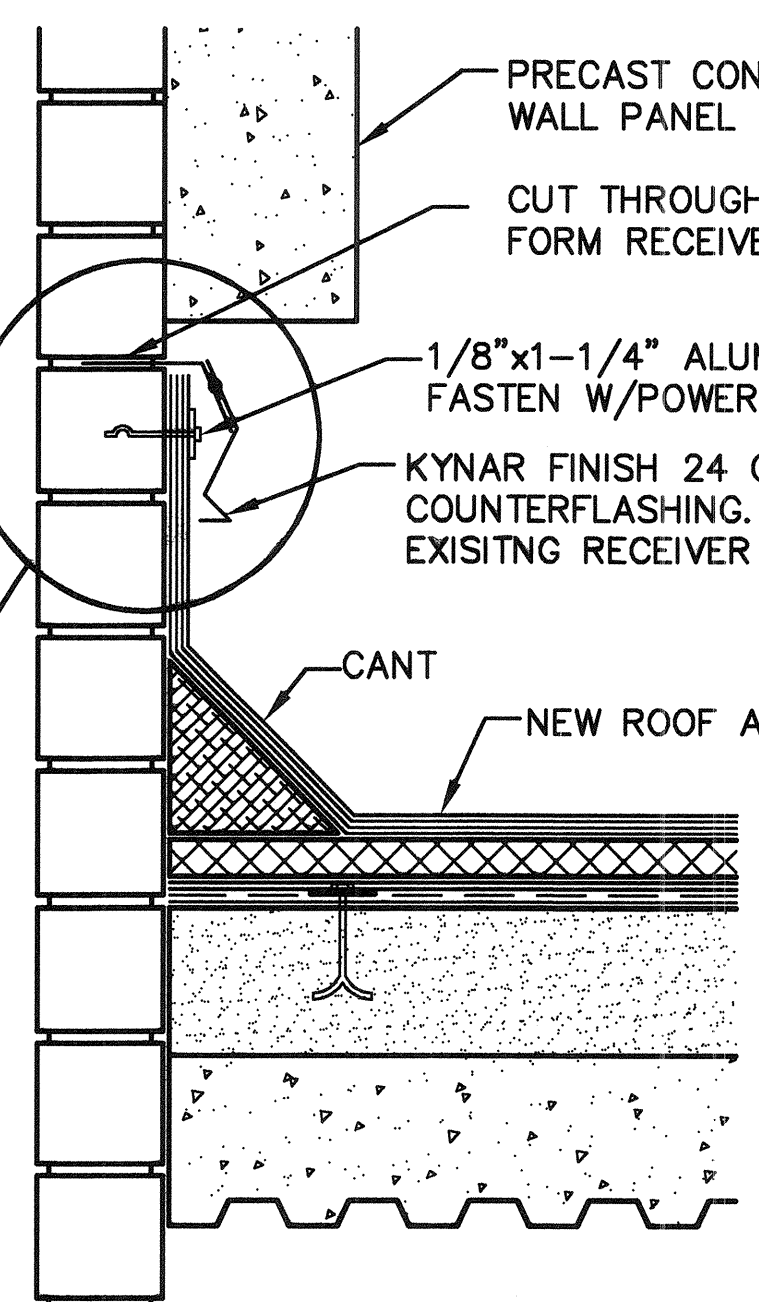


SECTION K-K
NTS

LEGEND


- ⊗ ROOF DRAIN
- EF EXHAUST FAN
- VP VENT PIPE
- LADDER
- S SCUPPER
- PP PITCH PAN

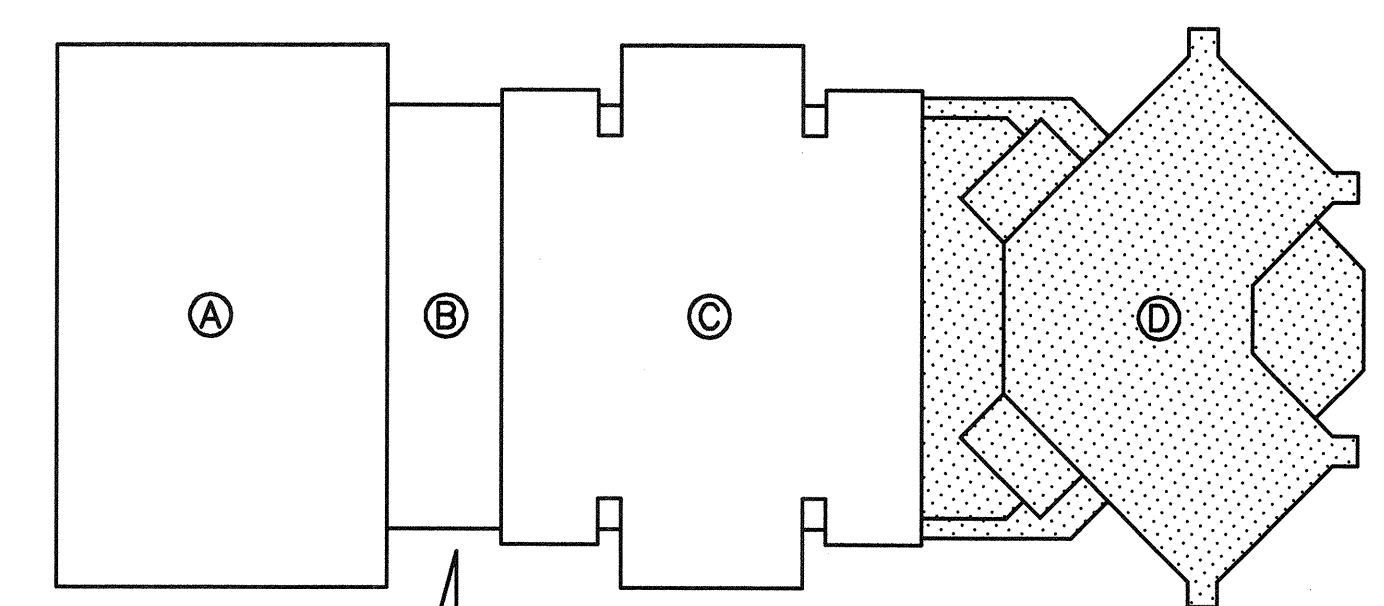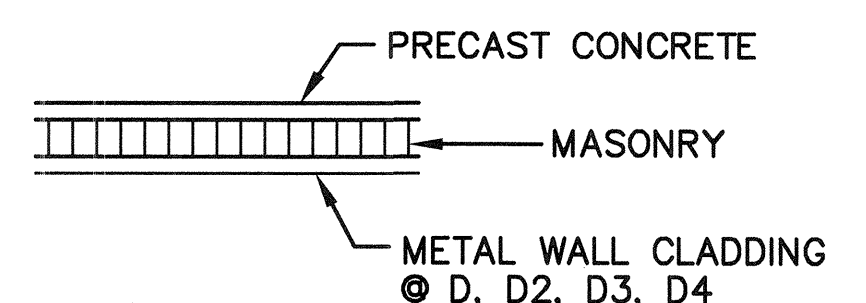

KEY PLAN
NTS







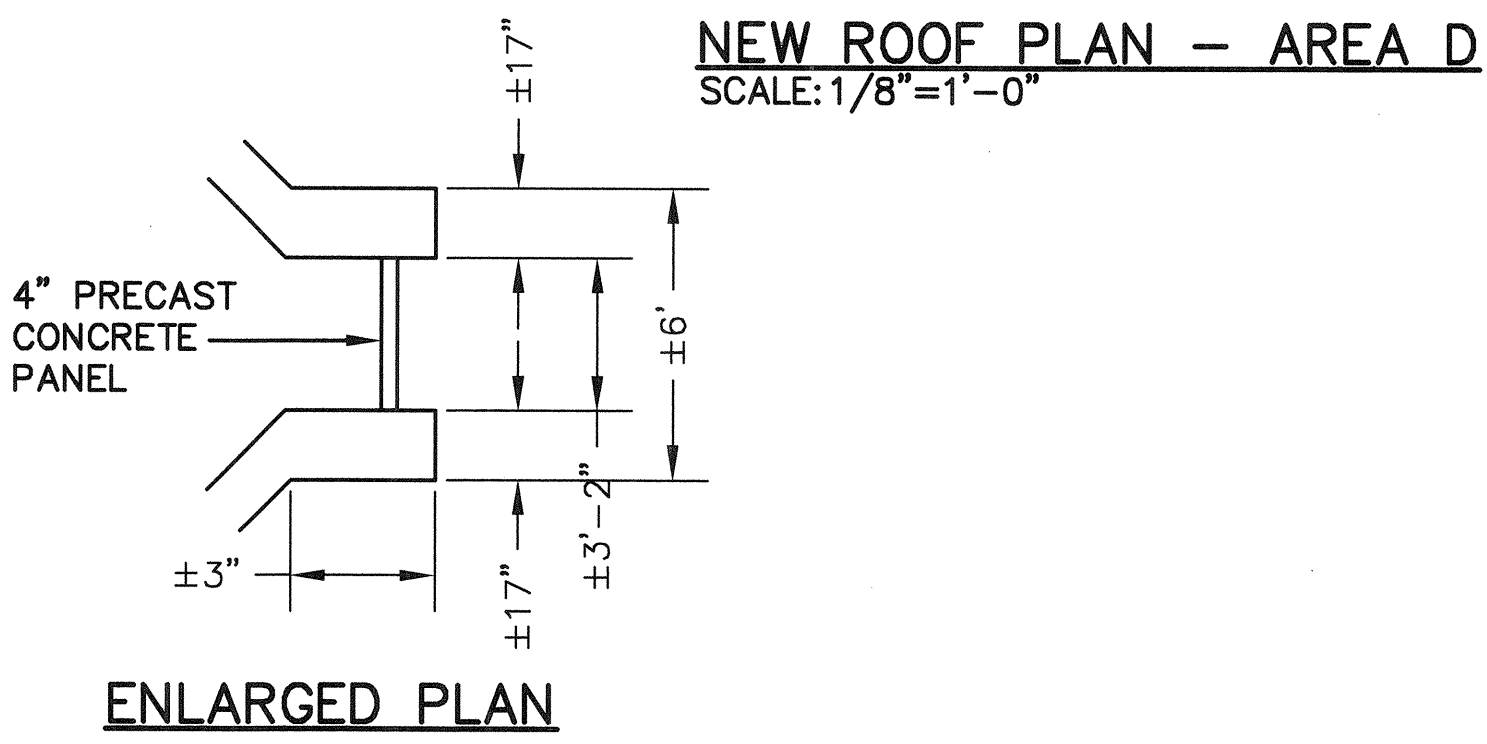


NEW ROOF PLAN - AREA D
SCALE: 1/8"=1'-0"

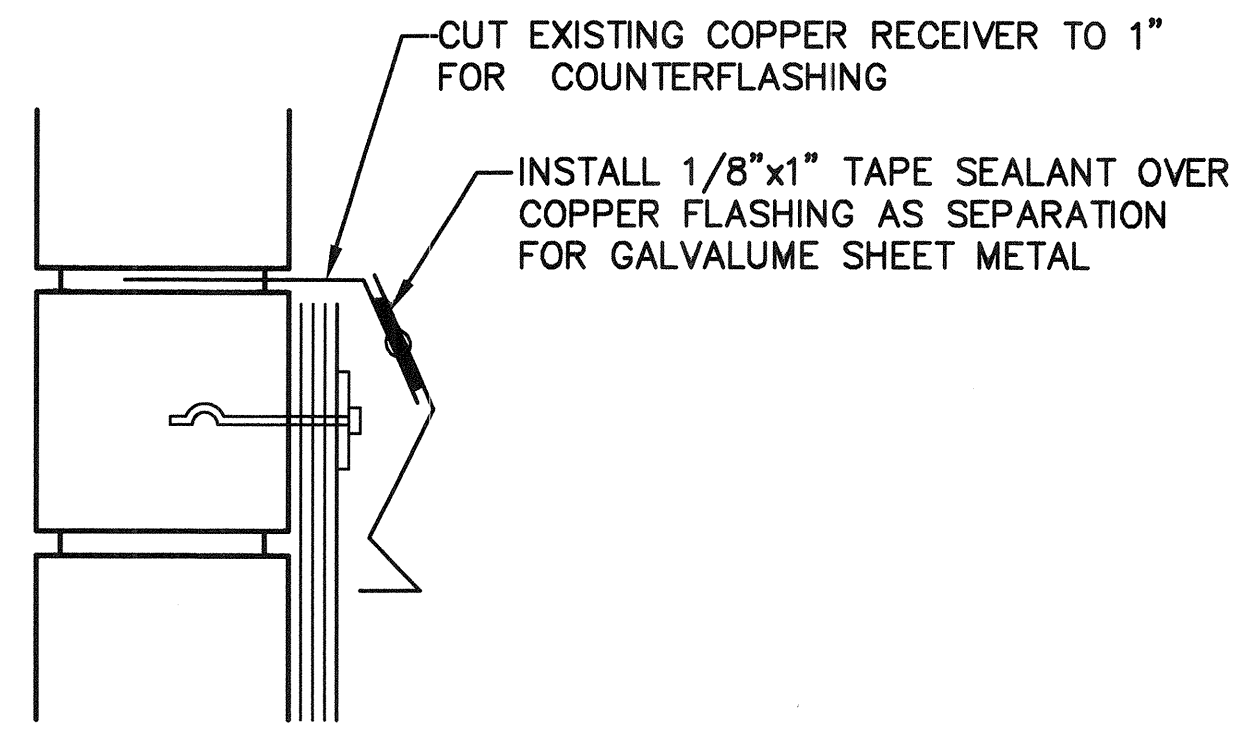

DETAIL P
NTS

REV. NO.	DESCRIPTION	DATE
1	CRF DM LAW CENTER ROOF REPLACEMENT UNIVERSITY OF SOUTH CAROLINA NEW ROOF PLAN-AREA "D" STATE PROJECT NO. H27-6094-F USC PROJECT NO. CP00336850 COLUMBIA, SOUTH CAROLINA	
FLOYD ABRAMS COMPANY COLUMBIA, SOUTH CAROLINA		Roof Consulting Services
SCALE: 1/8"=1'-0"	DRAWN BY: JDL	CHECKED BY: FA
PROJECT NO: 12.0100	DATE: 3/27/2012	SHEET R5 OF 6

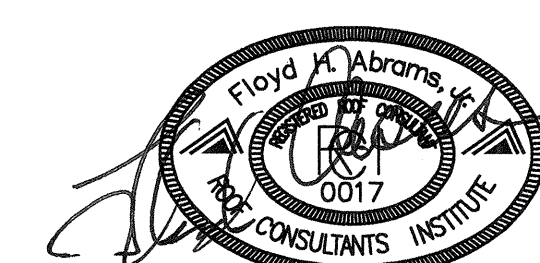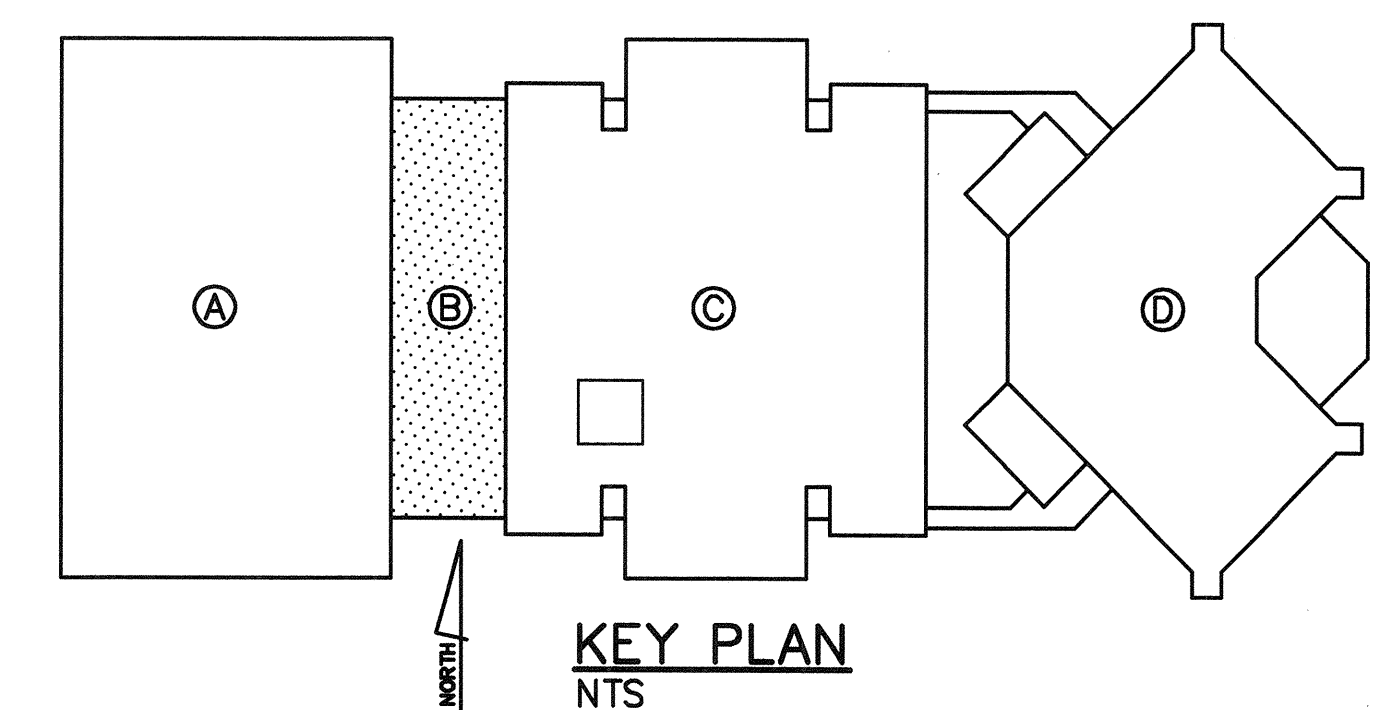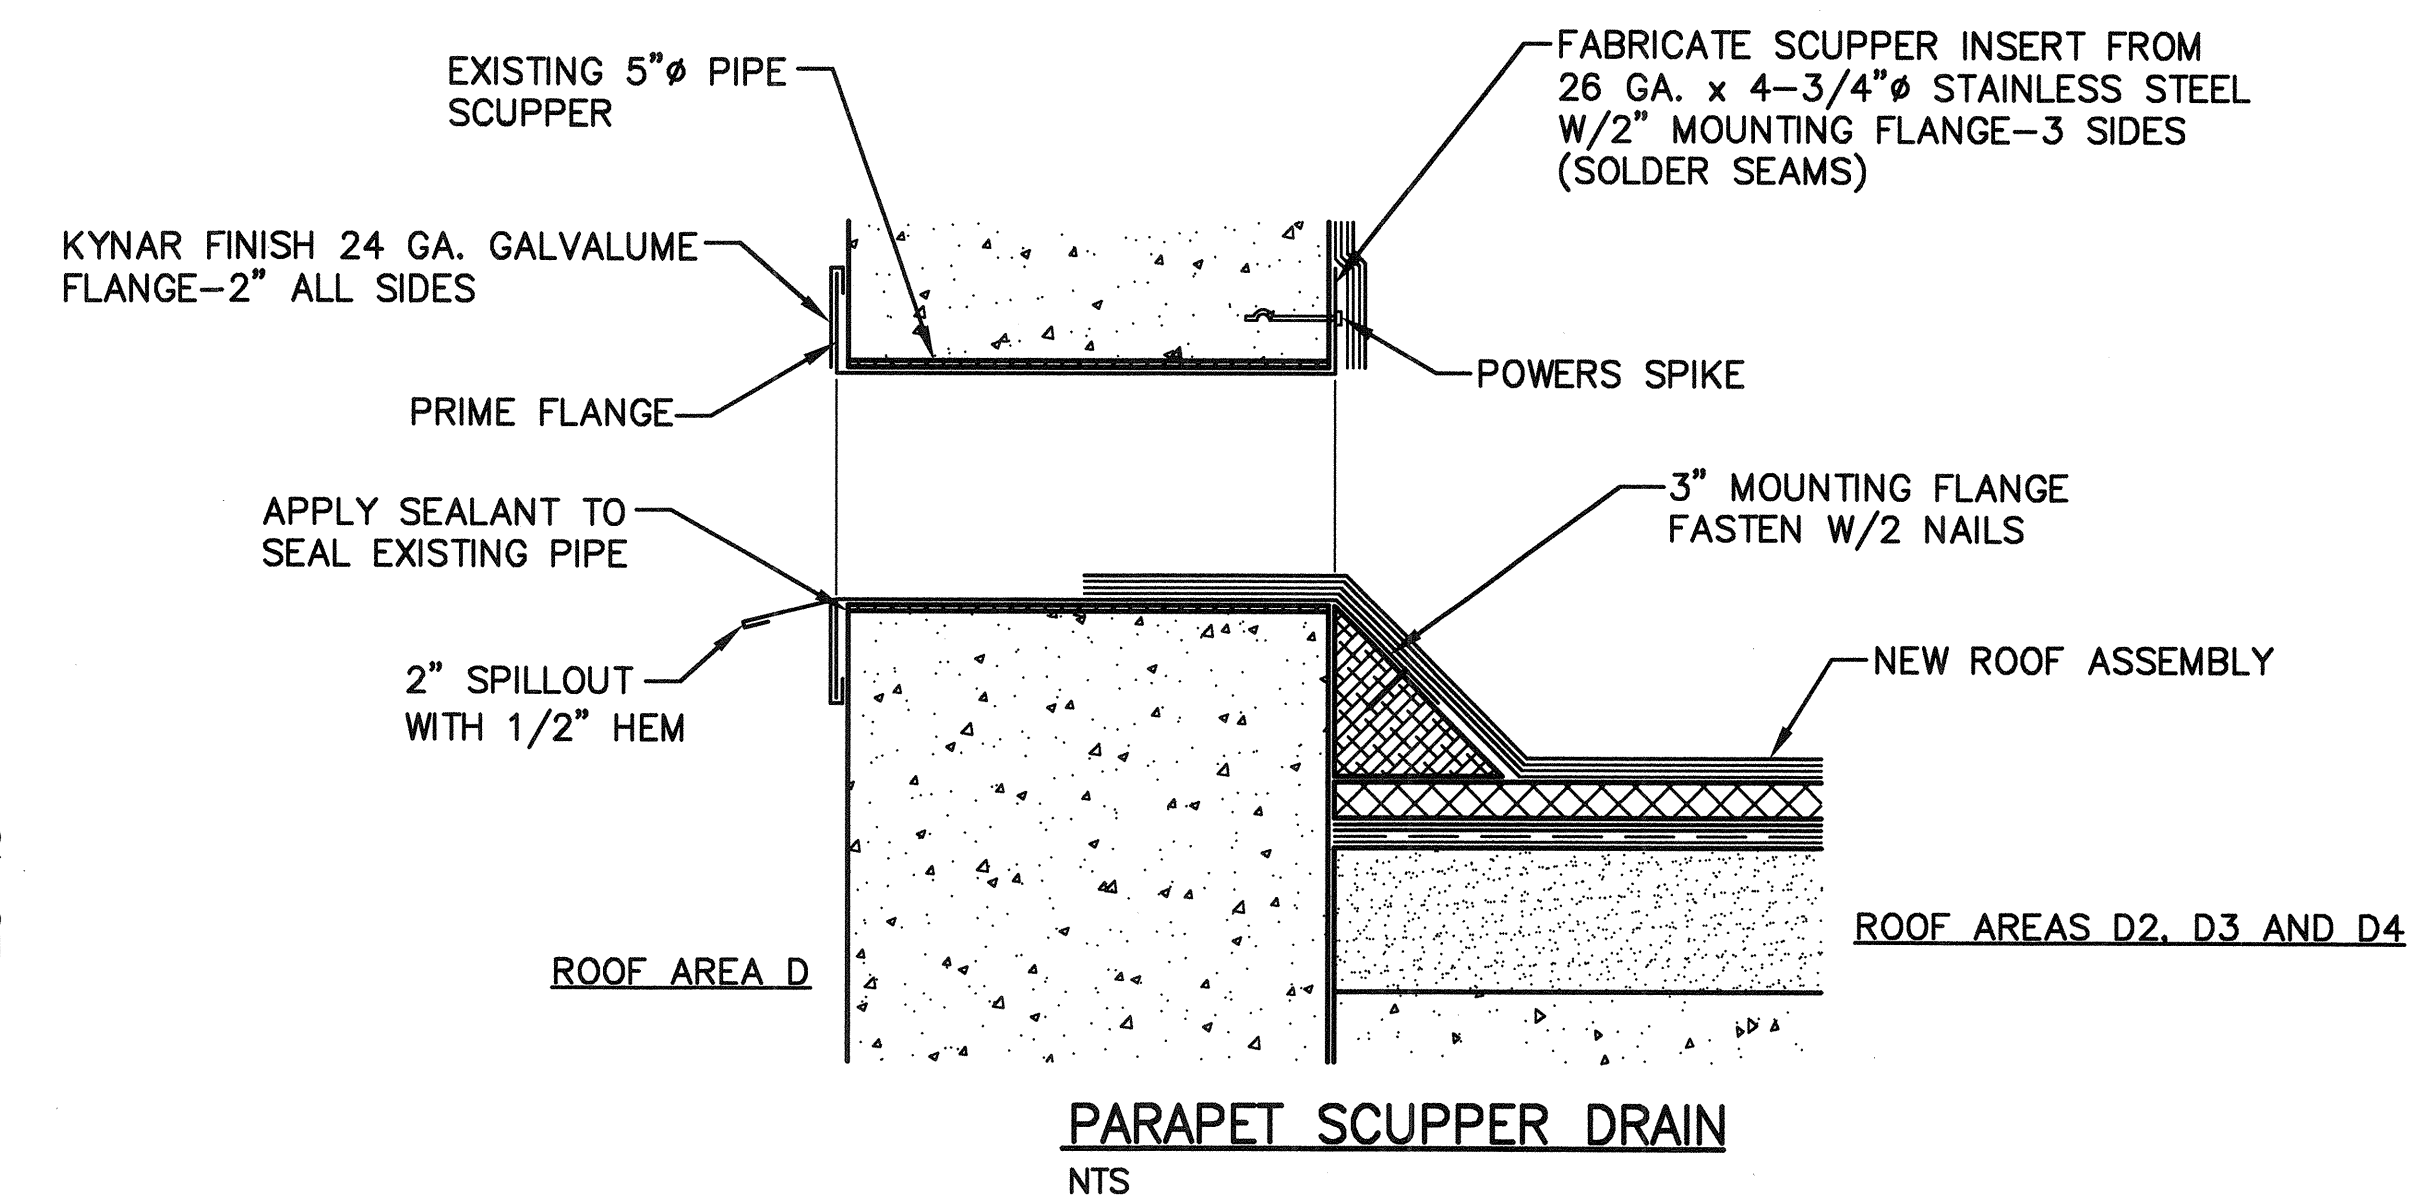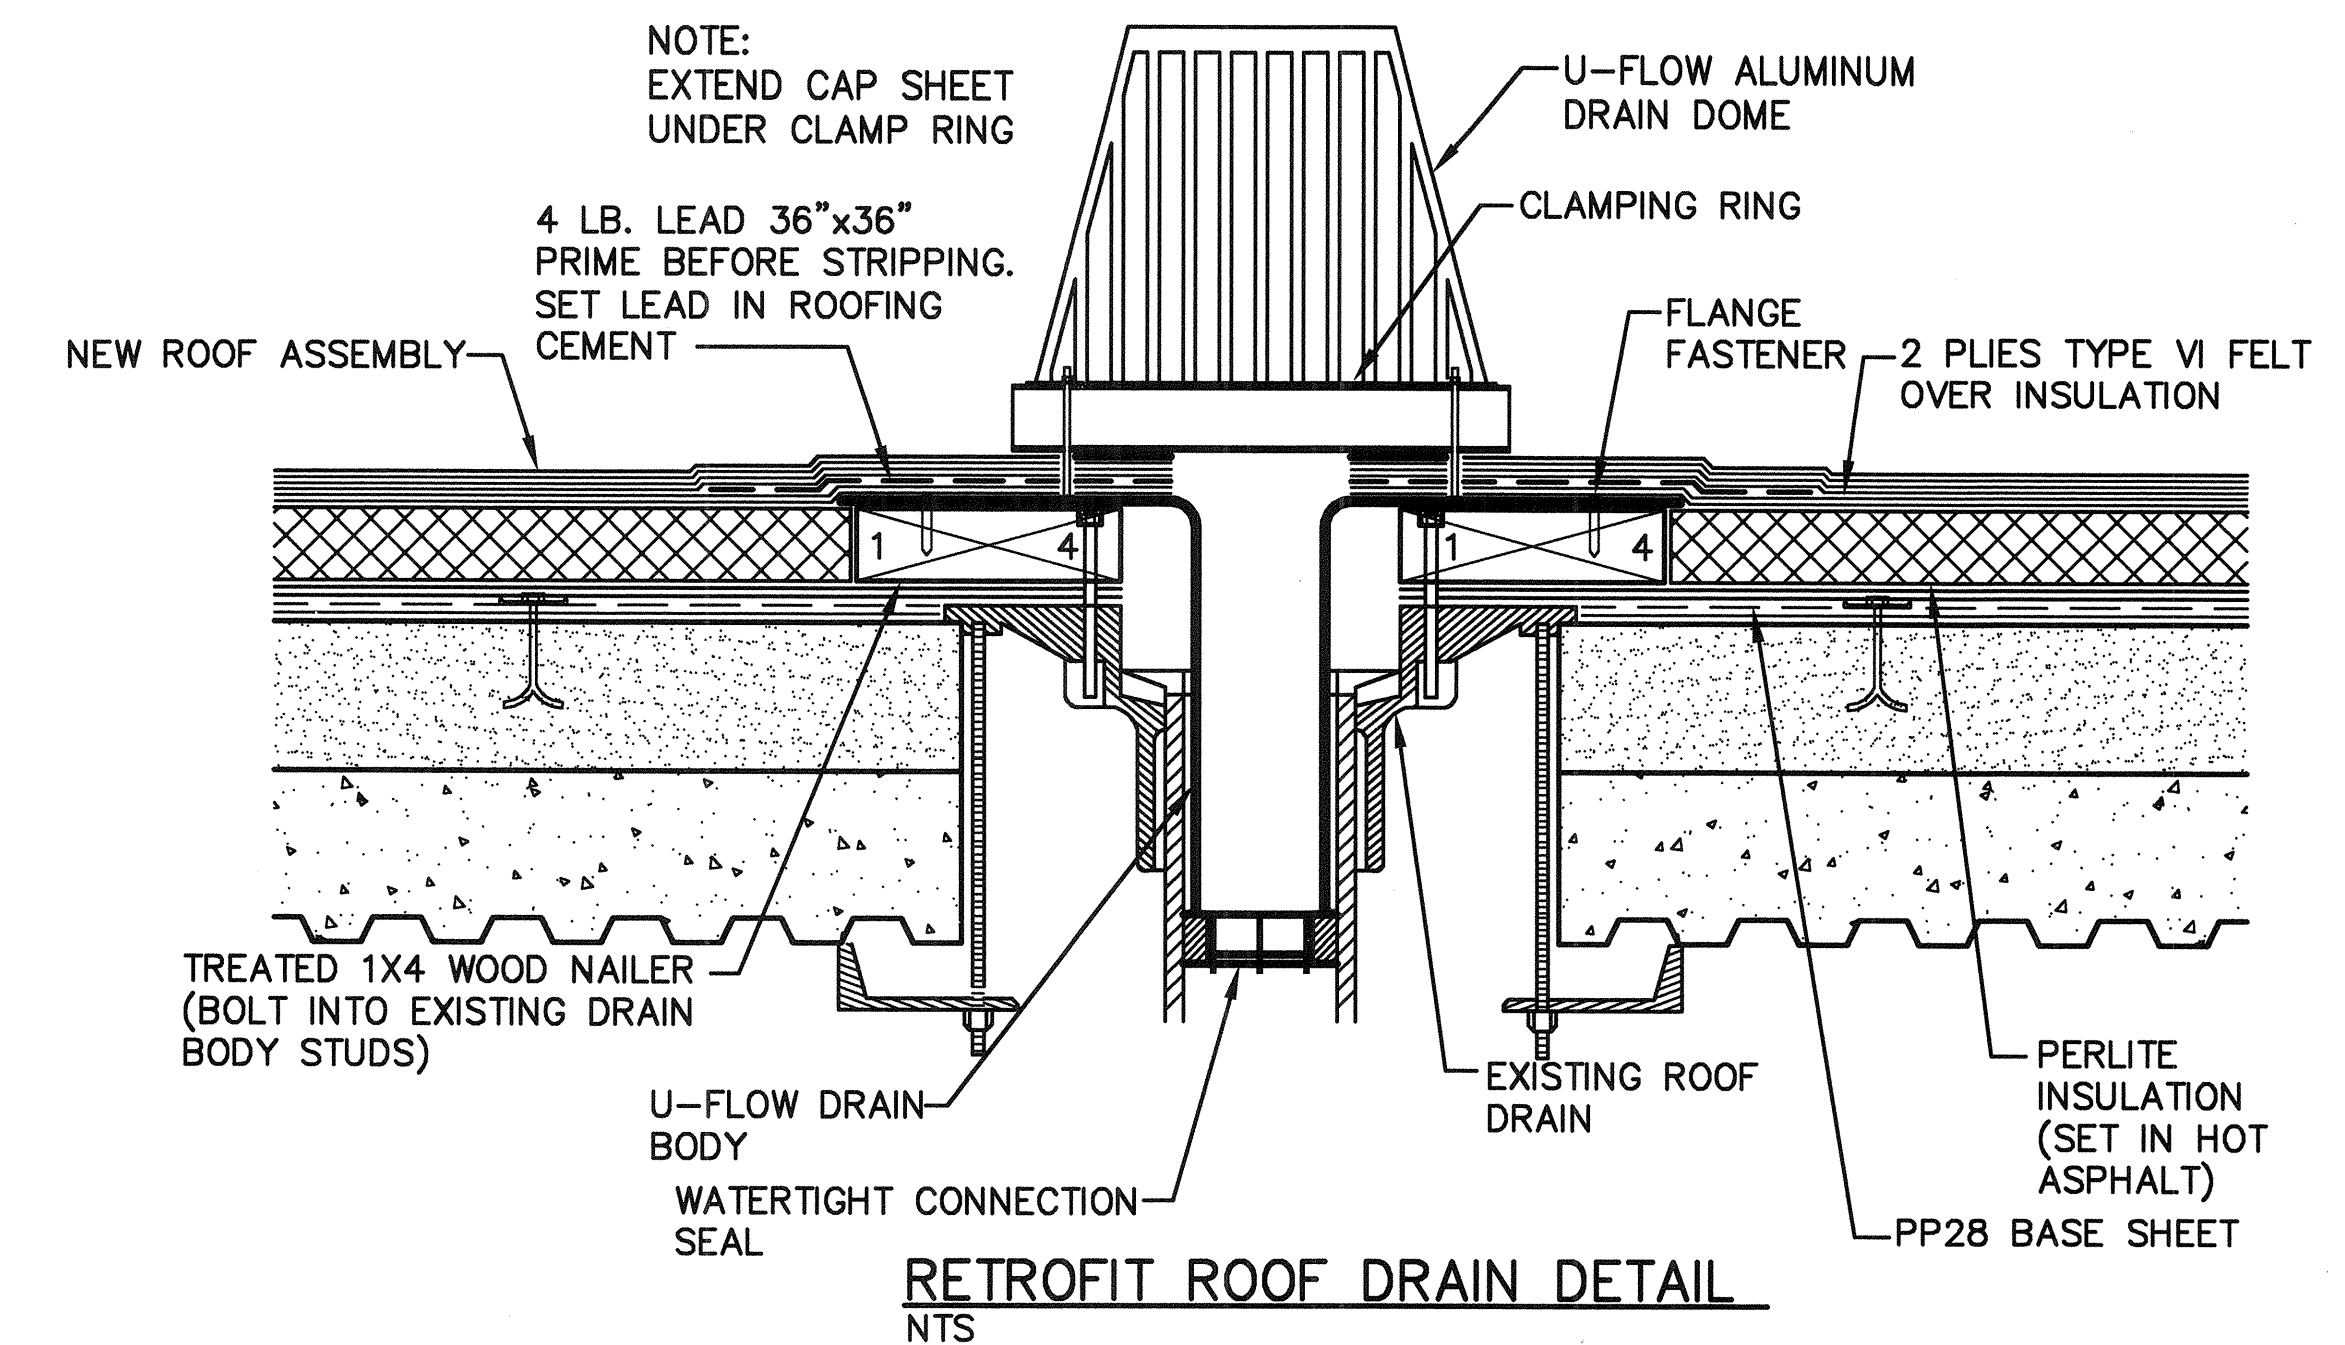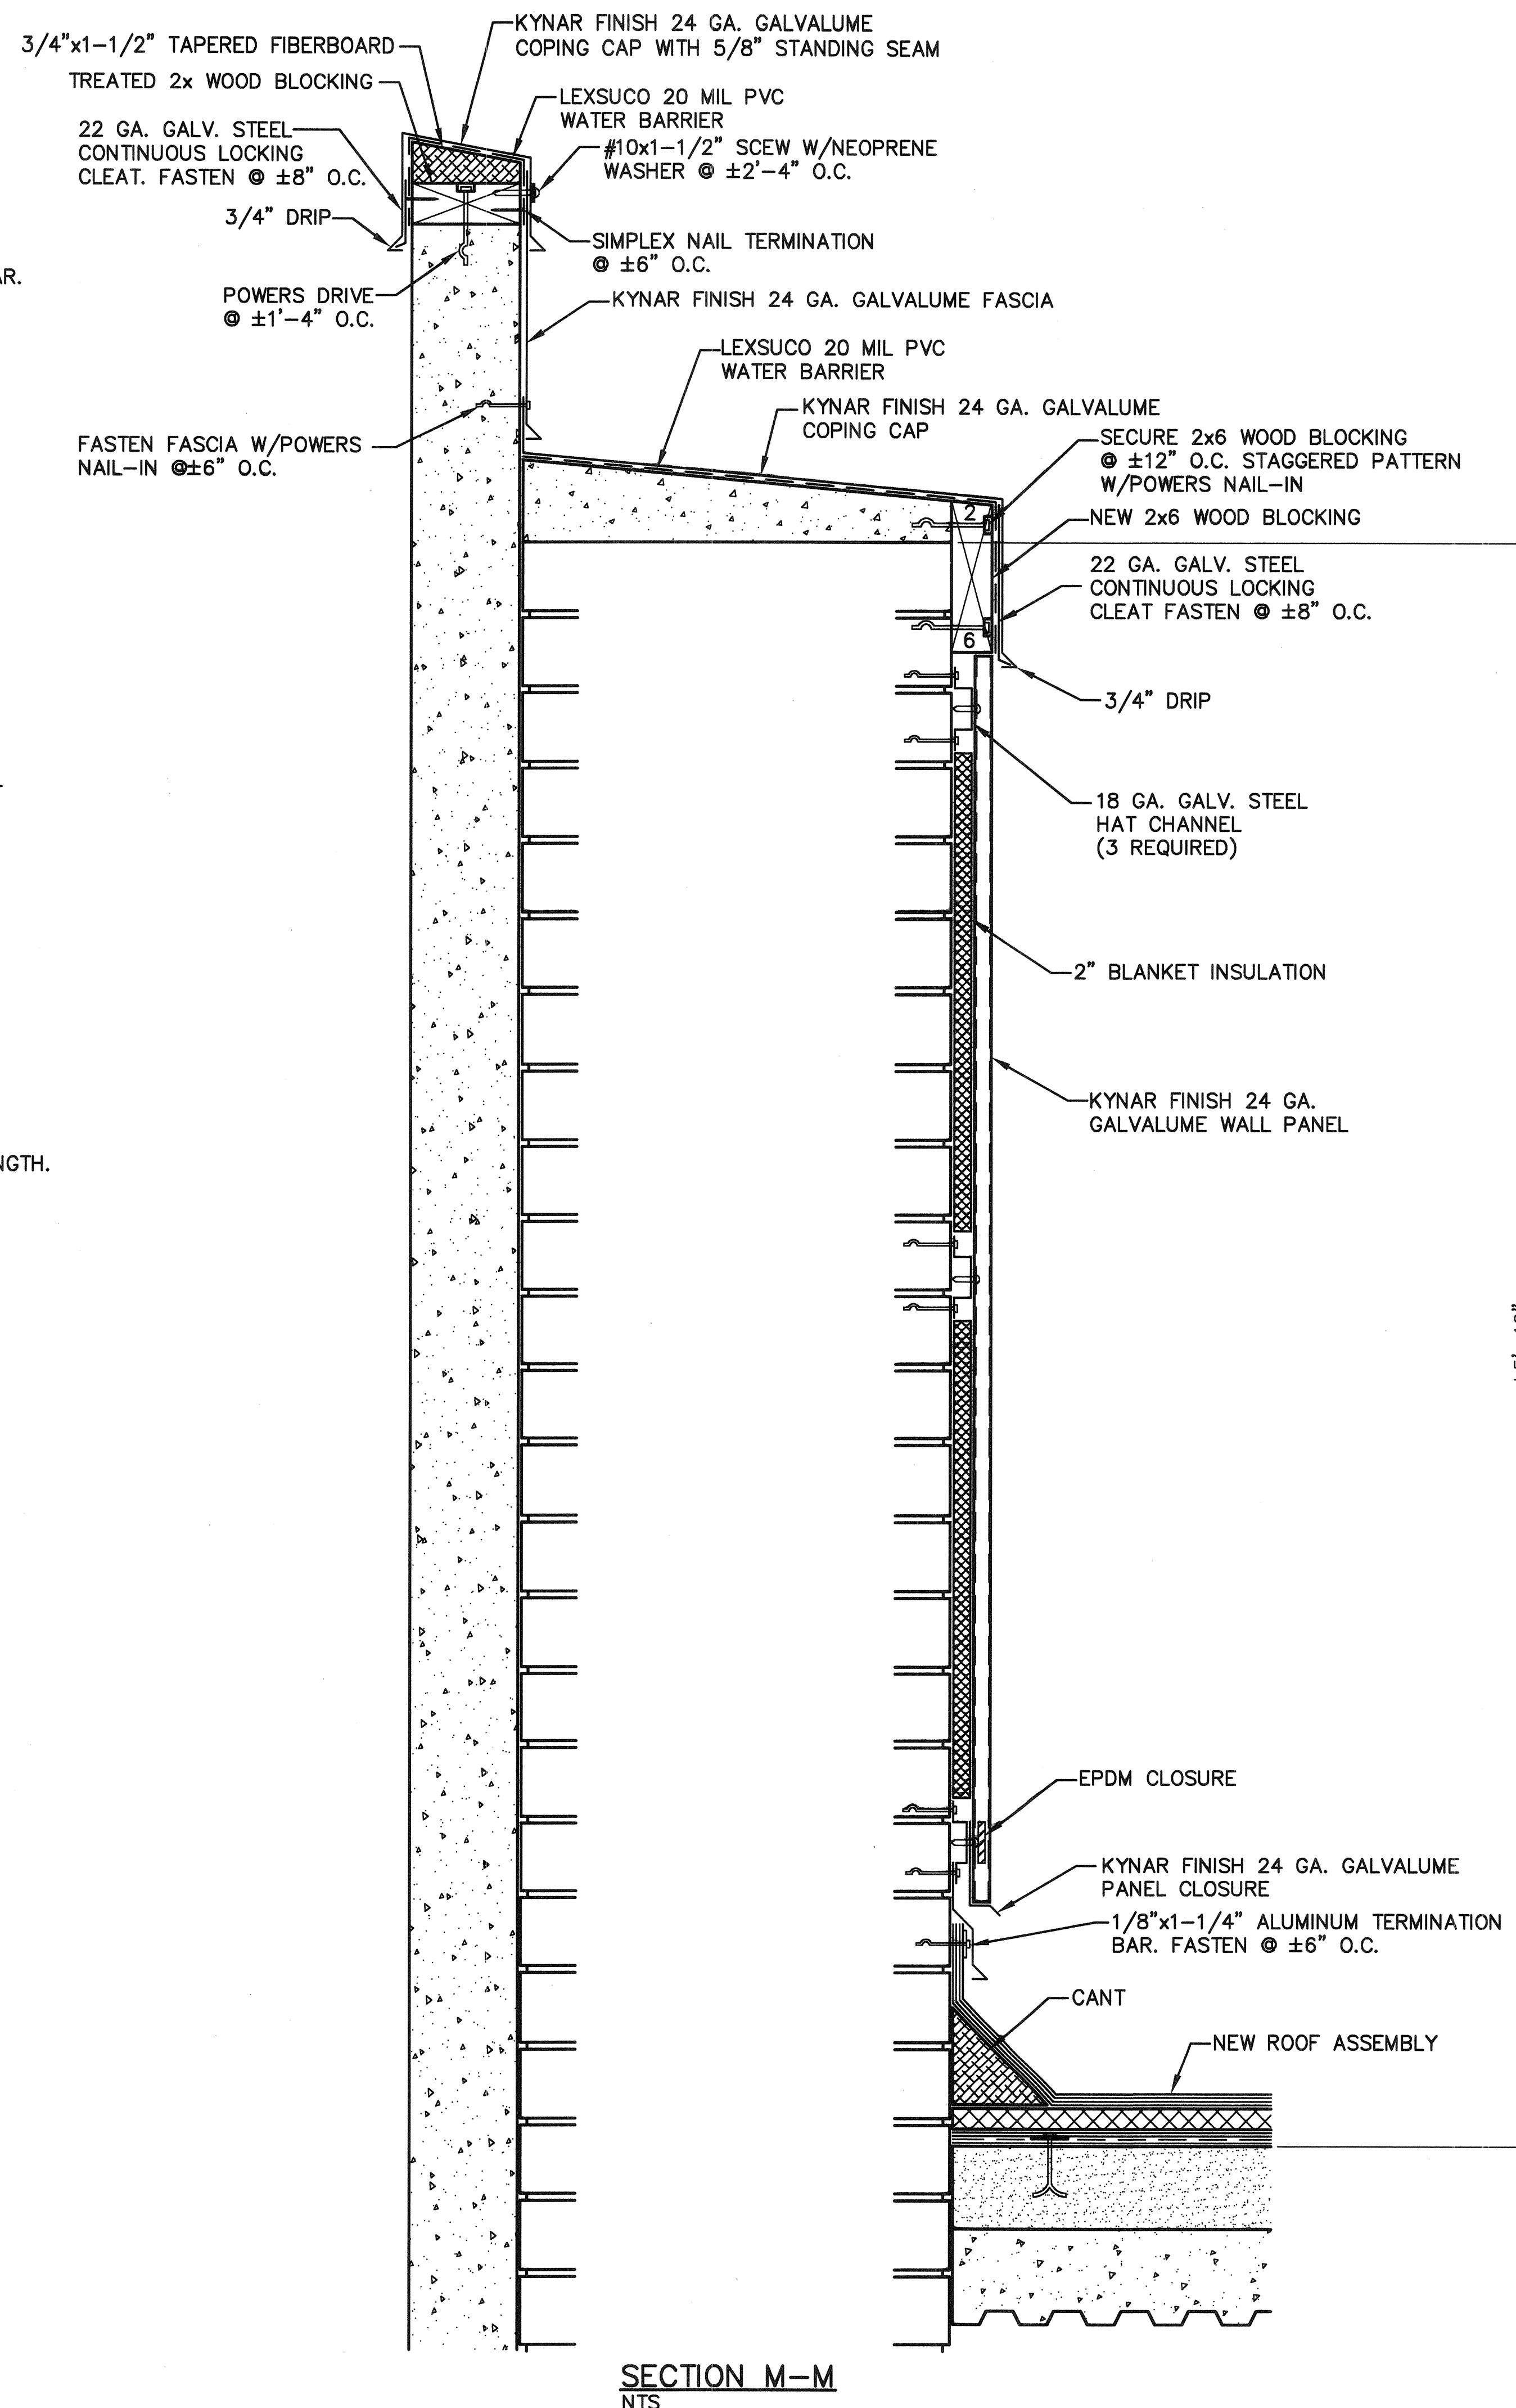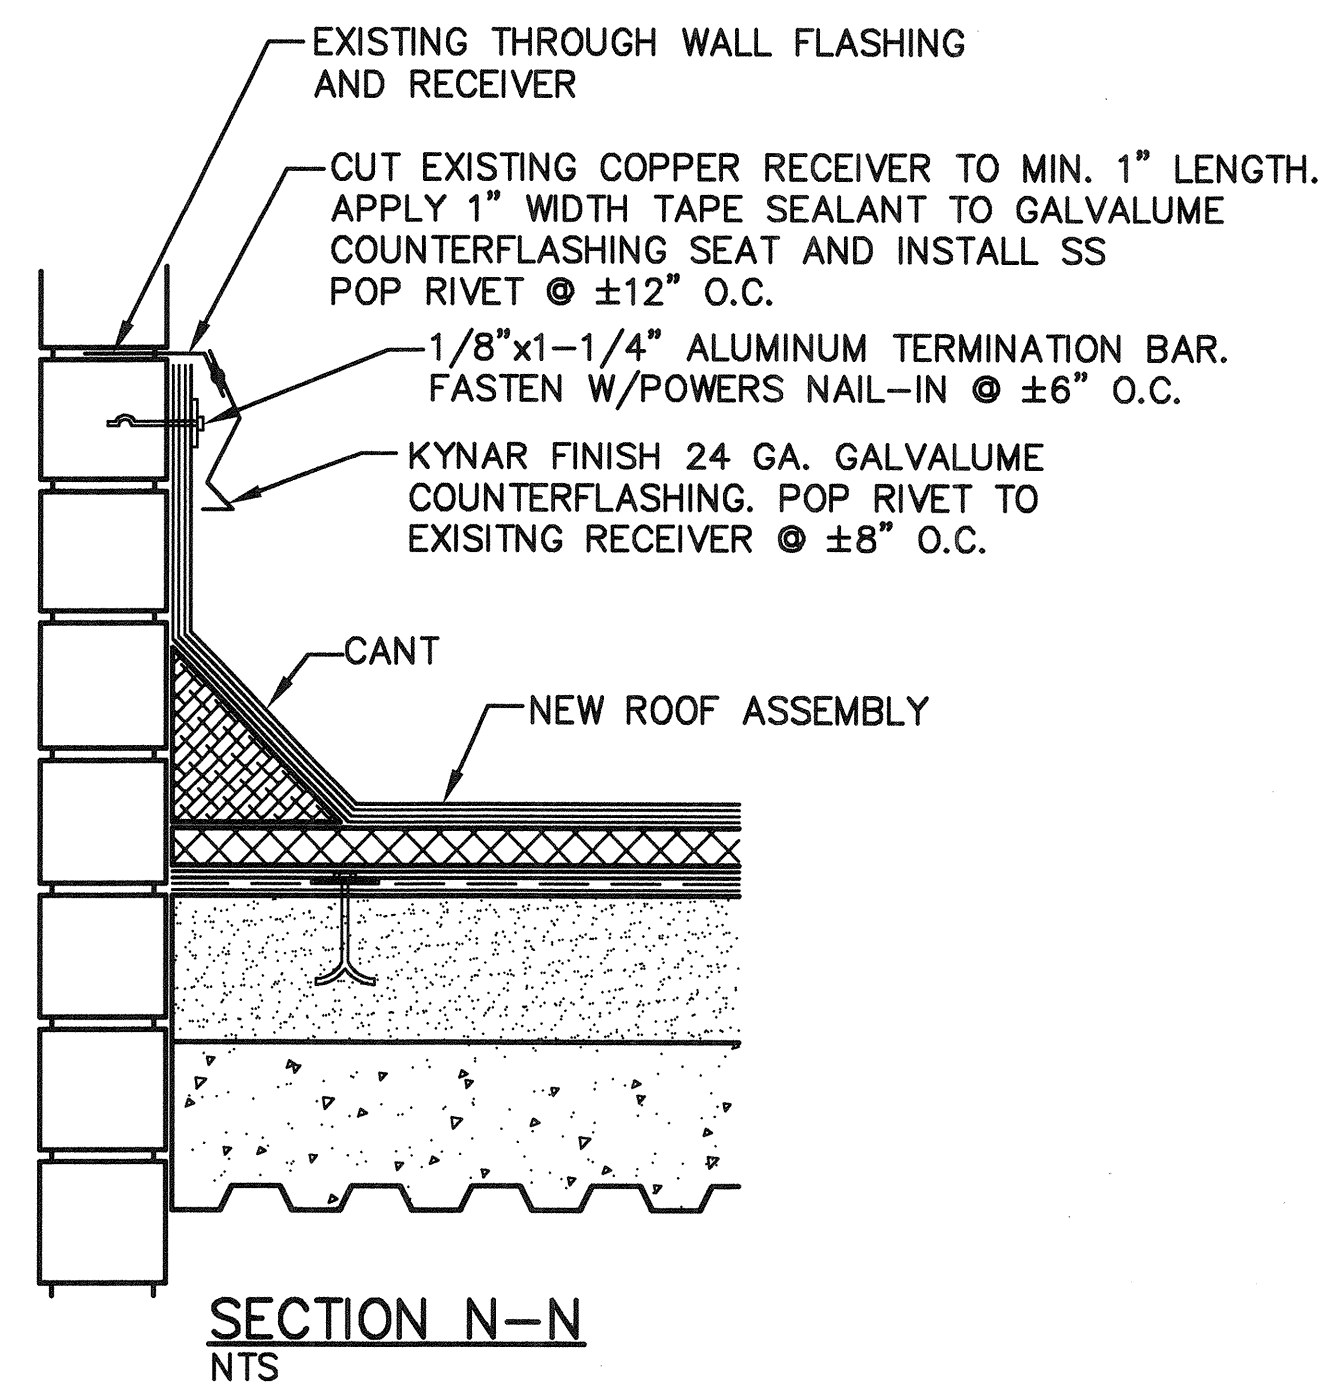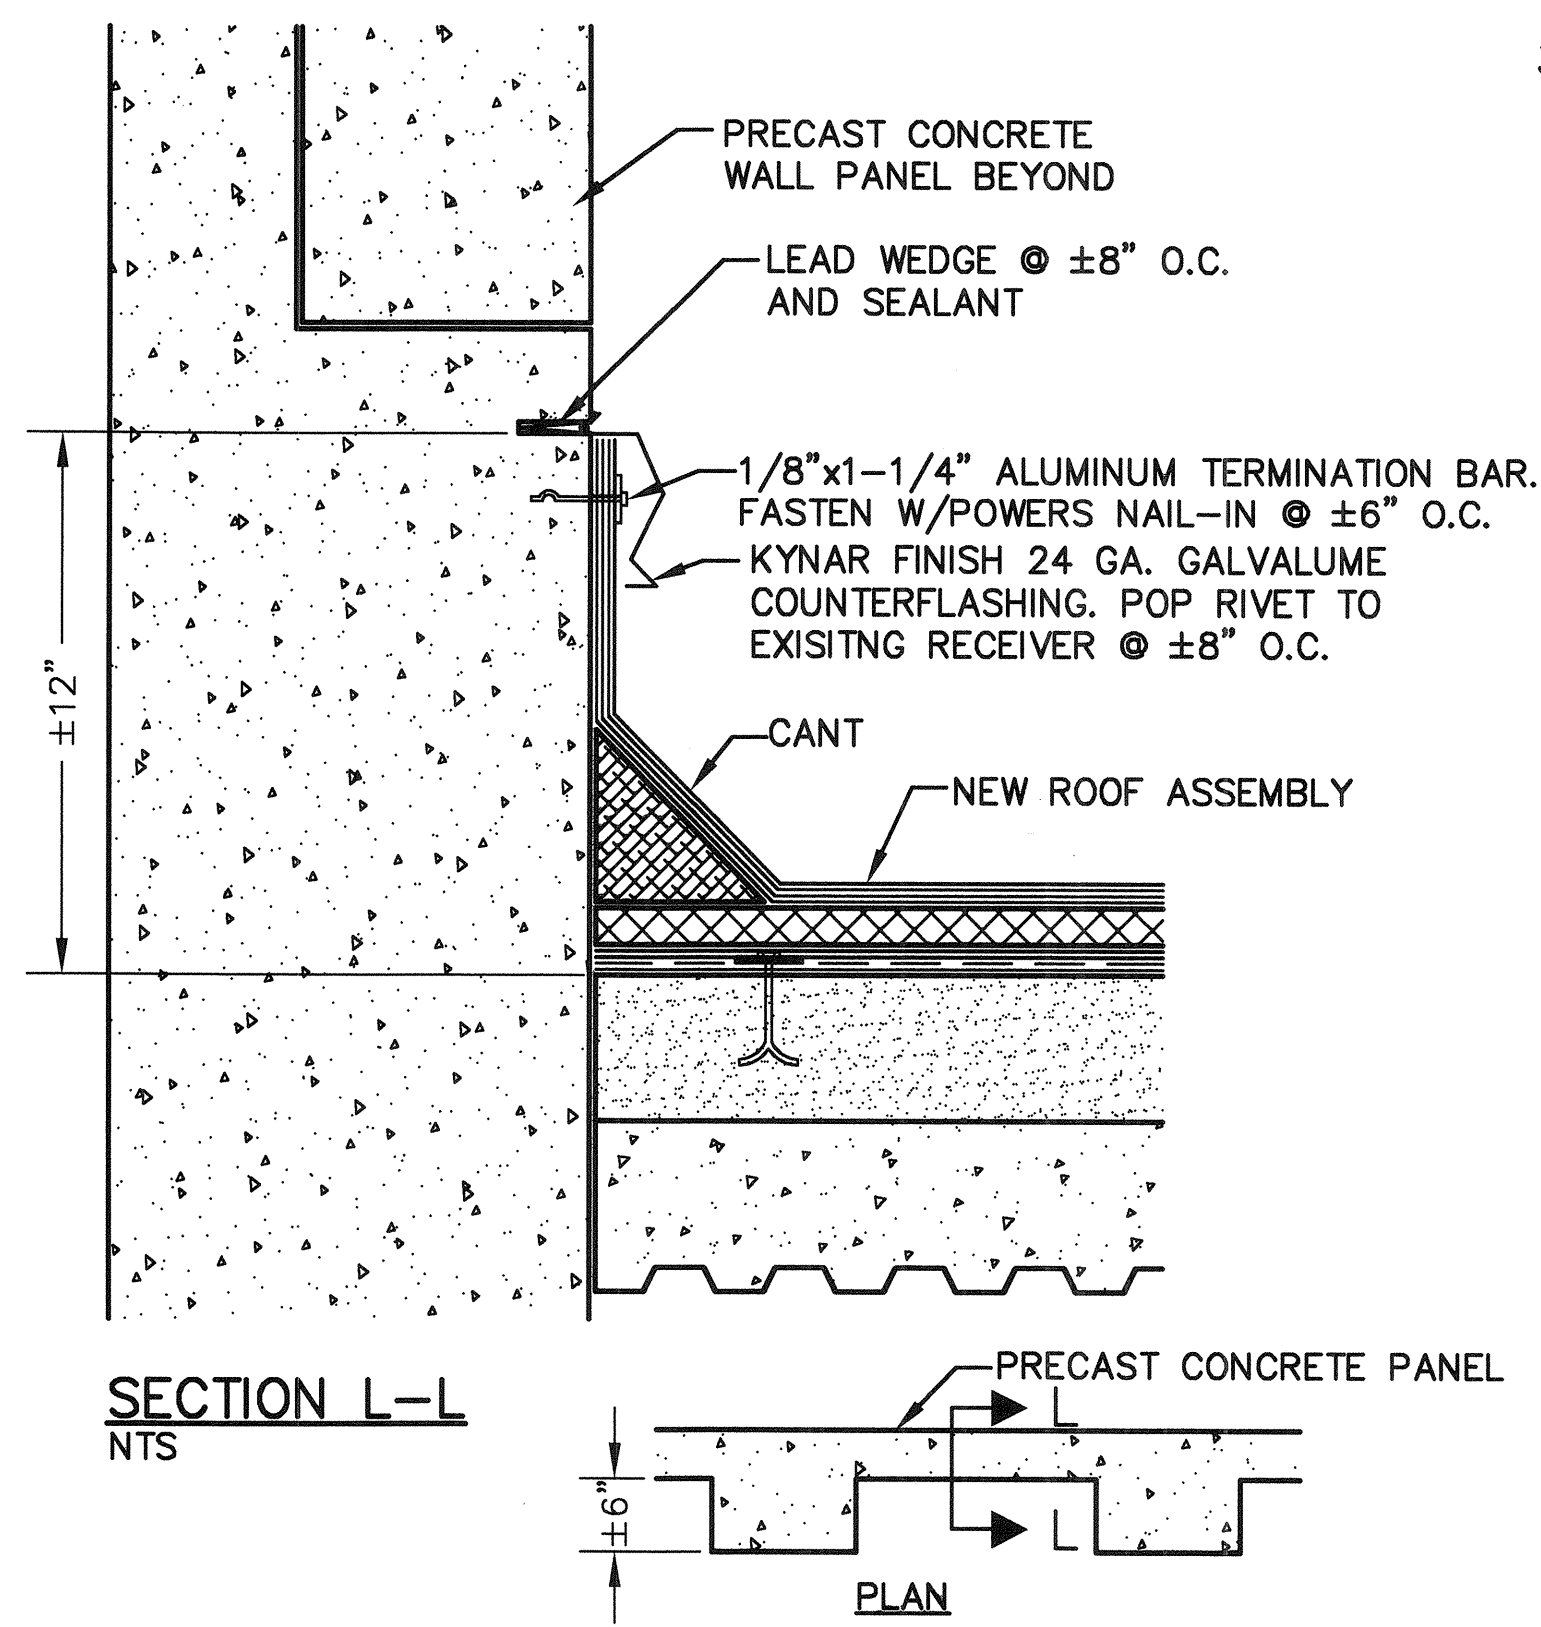

REV. NO.	DESCRIPTION	DATE
1	CRF DM LAW CENTER ROOF REPLACEMENT UNIVERSITY OF SOUTH CAROLINA SECTIONS-AREA "D"	
2	STATE PROJECT NO. H27-6094-F USC PROJECT NO. CP00336850 COLUMBIA, SOUTH CAROLINA	
FLOYD ABRAMS COMPANY COLUMBIA, SOUTH CAROLINA		Roof Consulting Services
SCALE: NTS	DRAWN BY: JDL	CHECKED BY: FA
PROJECT NO: 12.0100	DATE: 3/27/2012	SHEET R6 OF 6