

SECTION 00 9111 - ADDENDUM NUMBER 1

PARTICULARS

1.01 DATE: OCTOBER 21, 2014

1.02 PROJECT: USC BYRNES MECHANICAL - ELECTRICAL INFRASTRUCTURE UPGRADES

1.03 A/E PROJECT NUMBER:14024.01

1.04 USC PROJECT NUMBER: H27-Z153

1.05 OWNER: UNIVERSITY OF SOUTH CAROLINA

1.06 ARCHITECT:GMK ASSOCIATES, INC.

TO: PROSPECTIVE BIDDERS

2.01 THIS ADDENDUM FORMS A PART OF THE CONTRACT DOCUMENTS AND MODIFIES THE BIDDING DOCUMENTS DATED OCTOBER 21, 2014 , WITH AMENDMENTS AND ADDITIONS NOTED BELOW.

2.02 ACKNOWLEDGE RECEIPT OF THIS ADDENDUM IN THE SPACE PROVIDED IN THE BID FORM. FAILURE TO DO SO MAY DISQUALIFY THE BIDDER.

2.03 THIS ADDENDUM CONSISTS OF 1 PAGE AND THE FOLLOWING ATTACHMENTS:

- A. E4.0 - FIFTH, SIXTH & SEVENTH FLOOR ELECTRICAL PLANS
- B. Table of Contents
- C. Pre-bid Conference Sign-in

CHANGES TO THE PROJECT MANUAL

3.01 TABLE OF CONTENTS

- A. Add SECTION 00 9111 - ADDENDUM NUMBER 1

CHANGES TO THE DRAWINGS

4.01 DRAWING E4.0 - FIFTH, SIXTH & SEVENTH FLOOR ELECTRICAL PLANS

- A. Entirely new sheet added to the set of drawings.

4.02 DRAWING M1.0 - MECHANICAL PIPING BASEMENT DEMOLITION FLOOR PLAN

- A. Delete 2/M1.0 from the project. There will be no mechanical demolition in the first floor mechanical room 125.

END OF ADDENDUM NUMBER 1

TABLE OF CONTENTS

PROJECT NUMBER: H27-Z153

**PROJECT NAME: USC BYRNES MECHANICAL – ELECTRICAL
INFRASTRUCTURE UPGRADES**

SECTION

Table of Contents	4
 Invitation for Bids (SE-310).....	1
Section 00 2000 - Instructions to Bidders (AIA Document A701 – 1997 Edition)..	1
 Instructions to Bidders (AIA Document A701 – 1997 Edition *).....	6
 00201-0SE Standard Supplemental Instructions to Bidders.....	10
Section 00 2011 – Supplement A – Request for Information	
Section 00 3000 - Bid Bond (AIA A310).....	1
 Bid Bond (AIA A310).....	1
 Standard Bid Form (SE-330).....	6
Section 00 3100 - Available Project Information.....	1
Attachment: Hazardous Materials Reports	
Section 00 4000 - Procurement Forms and Supplements.....	1
Section 00 4010 – Supplement B - Substitution Request Form	
Section 00 5000 - Agreement.....	1
 Standard Form of Agreement between Owner and Contractor (AIA Document A101 – 2007 Edition*)	
 00501-0SE Standard Modifications to AIA A101-2007.....	3
<i>[Insert supplemental project specific modifications to AIA A101 if needed.]</i>	
Section 00 7000 - General Conditions.....	1
 General Conditions of the Contract for Construction (AIA Document A201 – 2007 Edition*)	

Section 00 8000 - Supplementary Conditions	1
00811-Standard Supplementary Conditions	25
(Supplement to AIA Document A201-2007 Edition General Conditions of the Contract)	
Performance Bond (SE-355)	2
Labor and Material Payment Bond (SE-357)	2
USC Supplemental General Conditions	2
Campus Vehicle Expectations	1
Contractors One Year Guarantee	1
SECTION 00 9111 – ADDENDUM NUMBER 1	1

TECHNICAL SPECIFICATIONS

DIVISION 1 - GENERAL REQUIREMENTS

01 2000	PRICE AND PAYMENT PROCEDURES	5
01 3000	ADMINISTRATIVE REQUIREMENTS	6
01 3216	CONSTRUCTION PROGRESS SCHEDULE	4
01 4000	QUALITY REQUIREMENTS	4
01 5000	TEMPORARY FACILITIES AND CONTROLS	4
01 6000	PRODUCT REQUIREMENTS	4
01 6010	SUPPLEMENT A - SUBSTITUTION REQUEST FORM	2
01 7000	EXECUTION AND CLOSEOUT REQUIREMENTS	12
01 7800	CLOSEOUT SUBMITTALS	6
01 7900	DEMONSTRATION AND TRAINING	1

DIVISION 2 – EXISTING CONDITIONS

02 4100	MINOR DEMOLITION FOR REMODELING	4
---------	---------------------------------	---

DIVISION 6 – WOOD, PLASTICS AND COMPOSITES

06 1000	ROUGH CARPENTRY	2
---------	-----------------	---

DIVISION 7 – THERMAL & MOISTURE PROTECTION

07 8400	FIRESTOPPING	5
---------	--------------	---

DIVISION 8 – OPENINGS

08 1113	HOLLOW METAL DOORS AND FRAMES	4
08 7110	FINISH HARDWARE	6

DIVISION 9 - FINISHES

09 2116	GYPSUM BOARD ASSEMBLIES	4
09 5100	ACOUSTICAL CEILINGS	5
09 6500	RESILIENT FLOORING	5
09 9000	PAINTS AND COATINGS	2

DIVISION 23 - MECHANICAL

23 0513	COMMON MOTOR REQUIREMENTS FOR HVAC EQUIPMENT	2
23 0519	METERS AND GAGES FOR HVAC PIPING	1
23 0520	VARIABLE FREQUENCY DRIVES	4
23 0548	VIBRATION AND SEISMIC CONTROLS	2
23 0553	IDENTIFICATION FOR HVAC PIPING AND EQUIPMENT	2
23 0593	TESTING, ADJUSTING AND BALANCING FOR HVAC	4
23 0716	HVAC EQUIPMENT INSULATION	3
23 0719	HVAC PIPING INSULATION	3
23 0913	INSTRUMENTATION AND CONTROL DEVICES FOR HVAC	6
23 0923	DIRECT - DIGITAL CONTROL SYSTEM FOR HVAC	11
23 0993	SEQUENCE OF OPERATION FOR HVAC CONTROLS	2
23 2113	HYDRONIC PIPING	7
23 2114	HYDRONIC SPECIALTIES	4
23 2123	HYDRONIC PUMPS	2
23 2500	HVAC WATER TREATMENT	2
23 8101	TERMINAL HEAT TRANSFER UNITS	2

DIVISION 26 - ELECTRICAL

26 0519	LOW - VOLTAGE ELECTRICAL POWER CONDUCTORS ...	4
26 0526	GROUNDING AND BONDING FOR ELECTRICAL SYSTEMS	2
26 0533	RACEWAY AND BOXES FOR ELECTRICAL SYSTEMS	3
26 0553	IDENTIFICATION FOR ELECTRICAL SYSTEMS	2
26 2200	LOW VOLTAGE TRANSFORMERS	3
26 2416	PANELBOARDS	3
26 2726	WIRING DEVICES	3
26 2813	FUSES	2

26 2819	ENCLOSED SWITCHES		2
26 5100	INTERIOR LIGHTING		2

END OF TABLE OF CONTENTS

University of South Carolina Pre Bid Sign In Sheet

Columbia, South Carolina

USC BYRNES MECHANICAL –
ELECTRICAL

INFRASTRUCTURE UPGRADES

H27-2153

Project Name:

Project Number:

Pre Bid Date & Time:

Tuesday, October 21, 2014 @ 10:00am

Name	Company Name	Address	Phone #	Email
Jerome Simons	Gmk Associates	1201 Main St. Ste 2100 Columbia SC 29201	803-256-0000	jsimons@gmkta.com
Jeff Bernagozzi	" "	" "	" "	jbernagozzi@gmkta.com
Kevin BELLA	BELLA ENR.	2 CLEVELAND COL, 29210	803-731-1665	kbella@bellath.net
Michael Dennis	Construction Services & SC	500 Greenwood Rd W. Columbia, SC 29169	803-600-0965	mdennis@csosfsc.com
Gill Holland	Johnson Controls	1400 Oakmont Dr Columbia SC 29212	803-237-8880	gill.holland@jci.com
Michelle Adams	USC	743 Greene St Columbia, SC	717-0981	mdadams@fmc.sc.edu

* Please make sure you list your company name as registered with ULR.

* By signing and providing your email address, you are authorizing the University of South Carolina to send you information electronically.

University of South Carolina Pre Bid Sign In Sheet

Columbia, South Carolina

USC BYRNES MECHANICAL -
ELECTRICAL

Project Name:

INFRASTRUCTURE UPGRADES

Project Number:


H27-2153

Pre Bid Date & Time:


Tuesday, October 21, 2014 @ 10:00am

Name	Company Name	Address	Phone #	Email
David T. Izzi	David T. Izzi	1901 Augusta Hwy Lex, SC 29072	803- 957-5522	tdizzi@scup.edu
ESTIMATING	COLLUM CONST.	3325 Pacific St N. Charleston SC 29418	843-554- 6645	Bids @ colluminc.com
ASUN ROUSE	Hammer LANS	785 Hampton Creek Columbia, 29209	803-788-7013	lee@hammerllc.com
Nick Miller	Sherry & Sons	PO Box 4253 C. Col. H. SC	794-2302	nick-miller@berkwith.net
Mike Peters	MFP Electric Inc	123 Sena Street West Columbia SC	518 7930	mfpelctric@gmail.com
Chris Meninger	USC	743 Greene St. Columbia SC.	717-5758 4509	emengner@fawc.sc.edu


*Please make sure you list your company name as registered with LLC.
* By signing and providing your email address, you are authorizing the University of South Carolina to send you information electronically.

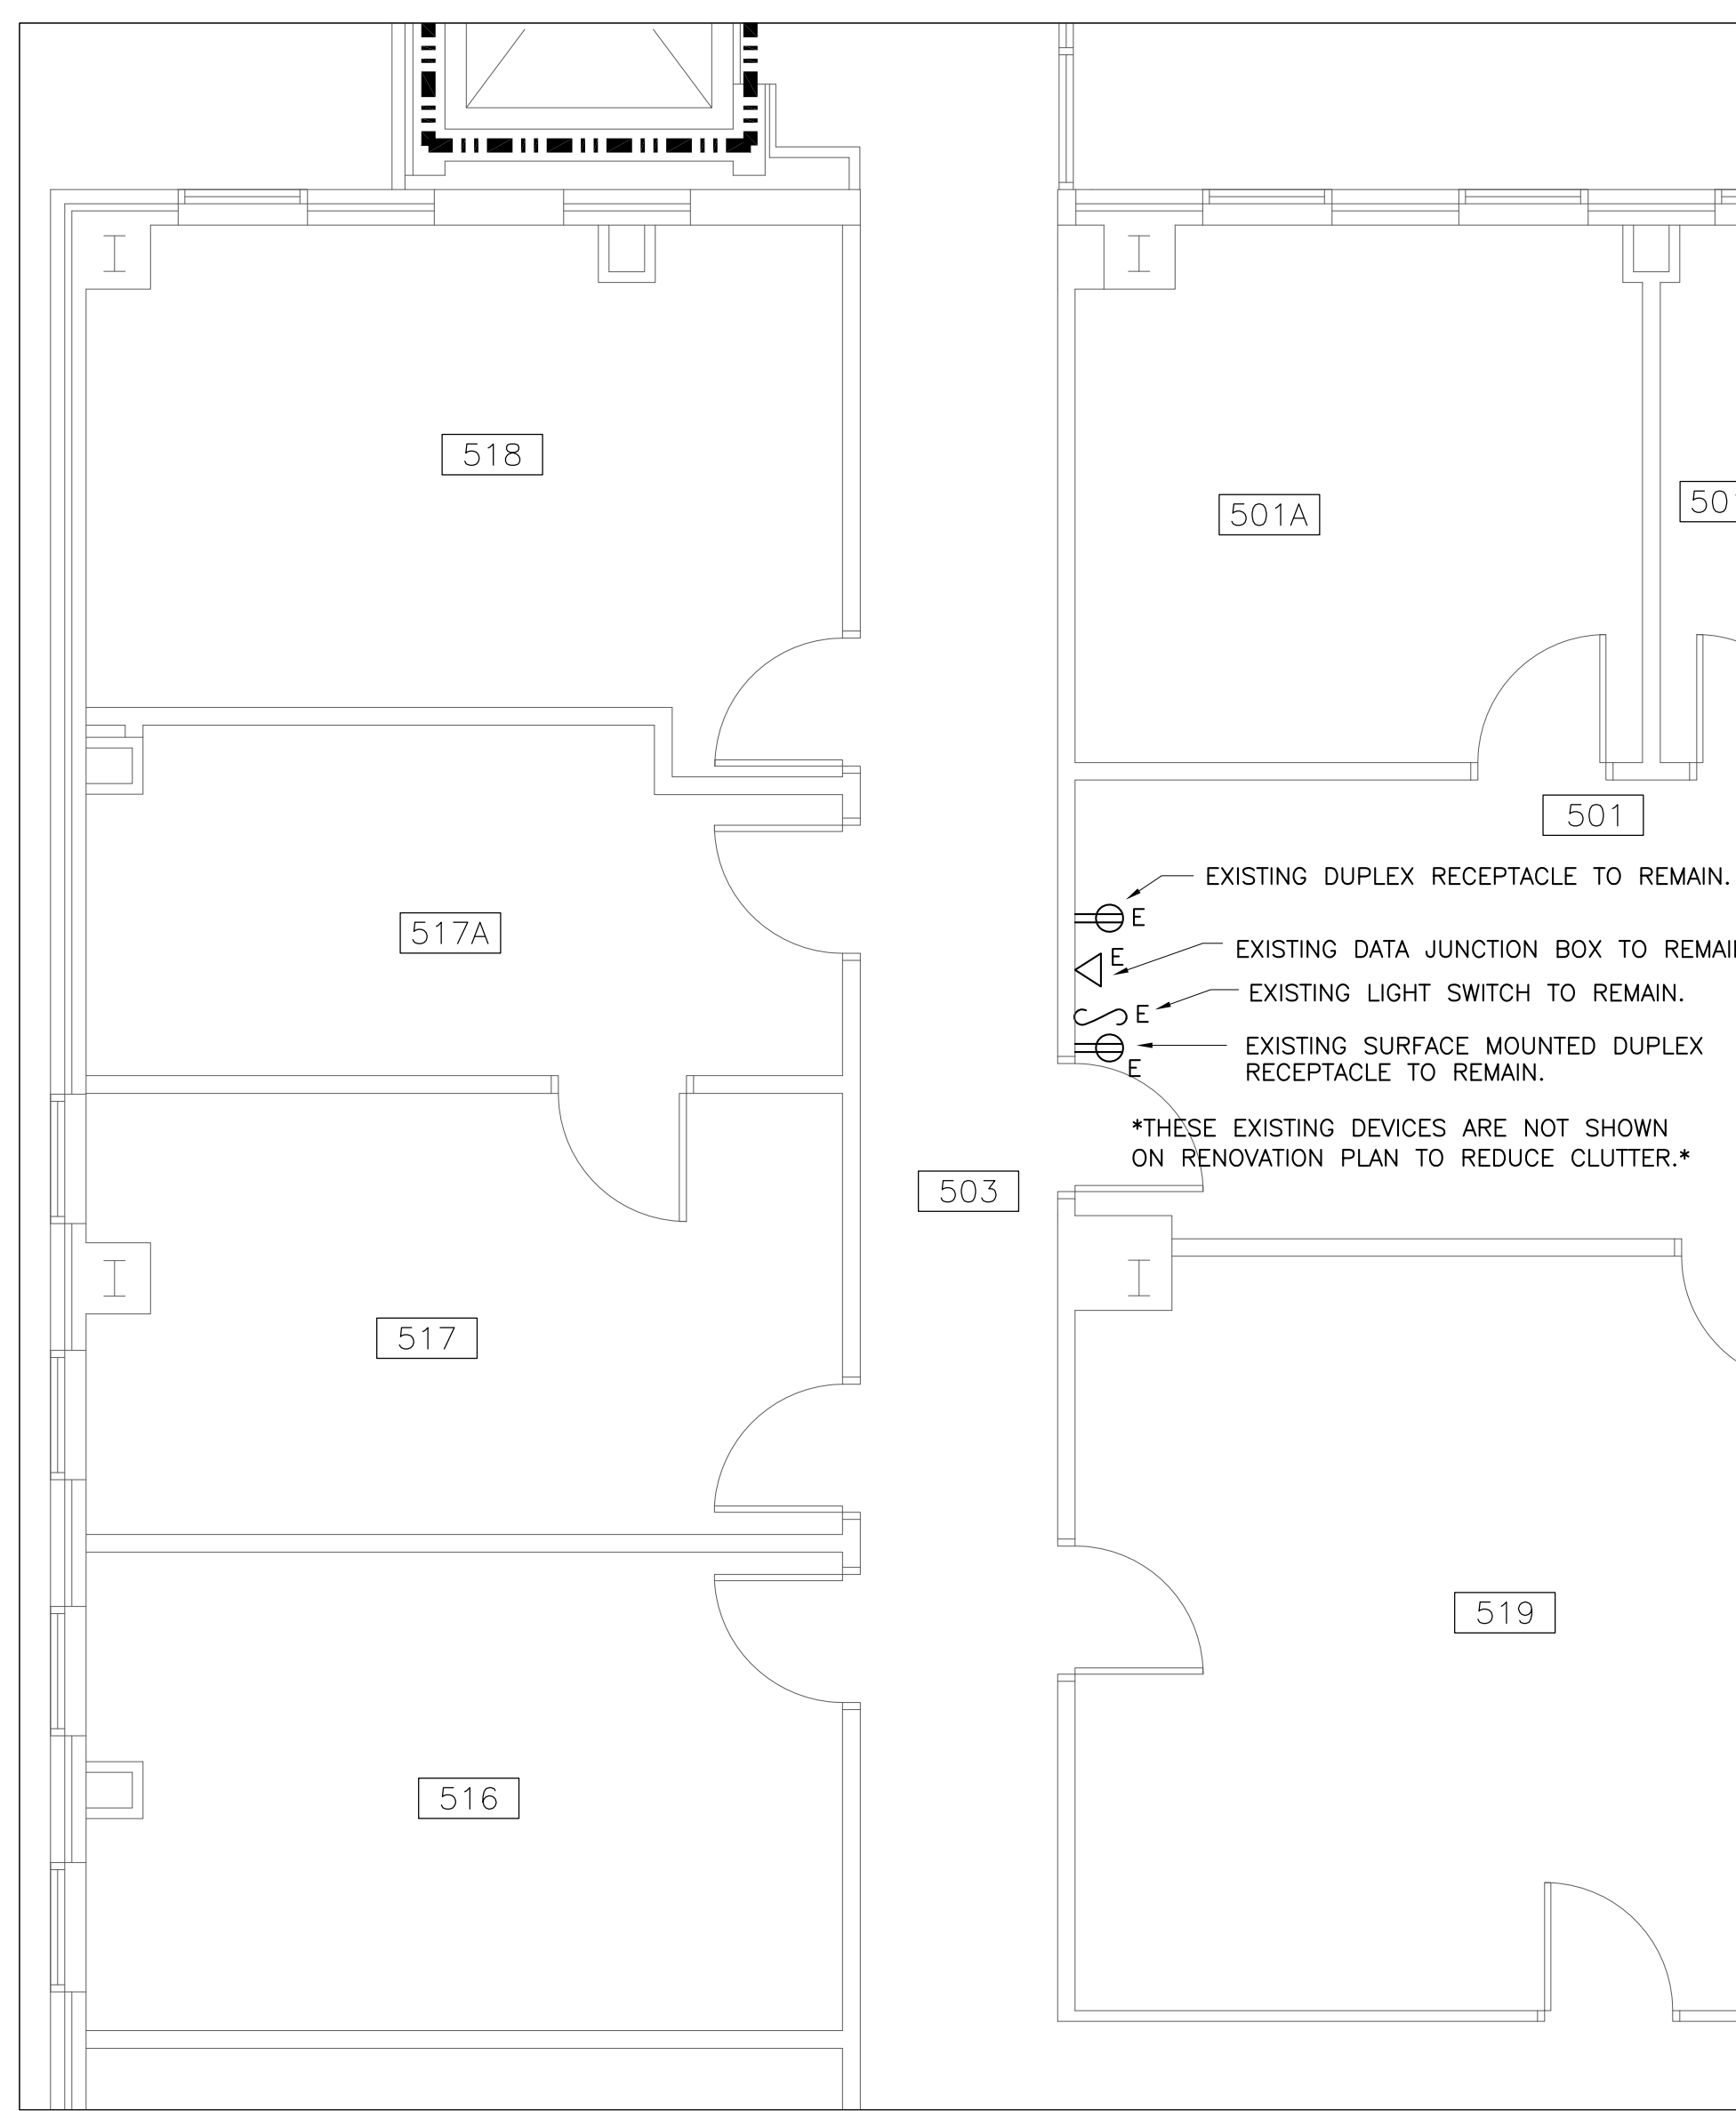


1
E4
5TH FLOOR PARTIAL
DEMOLITION PLAN
SCALE: 1/4" = 1'-0"

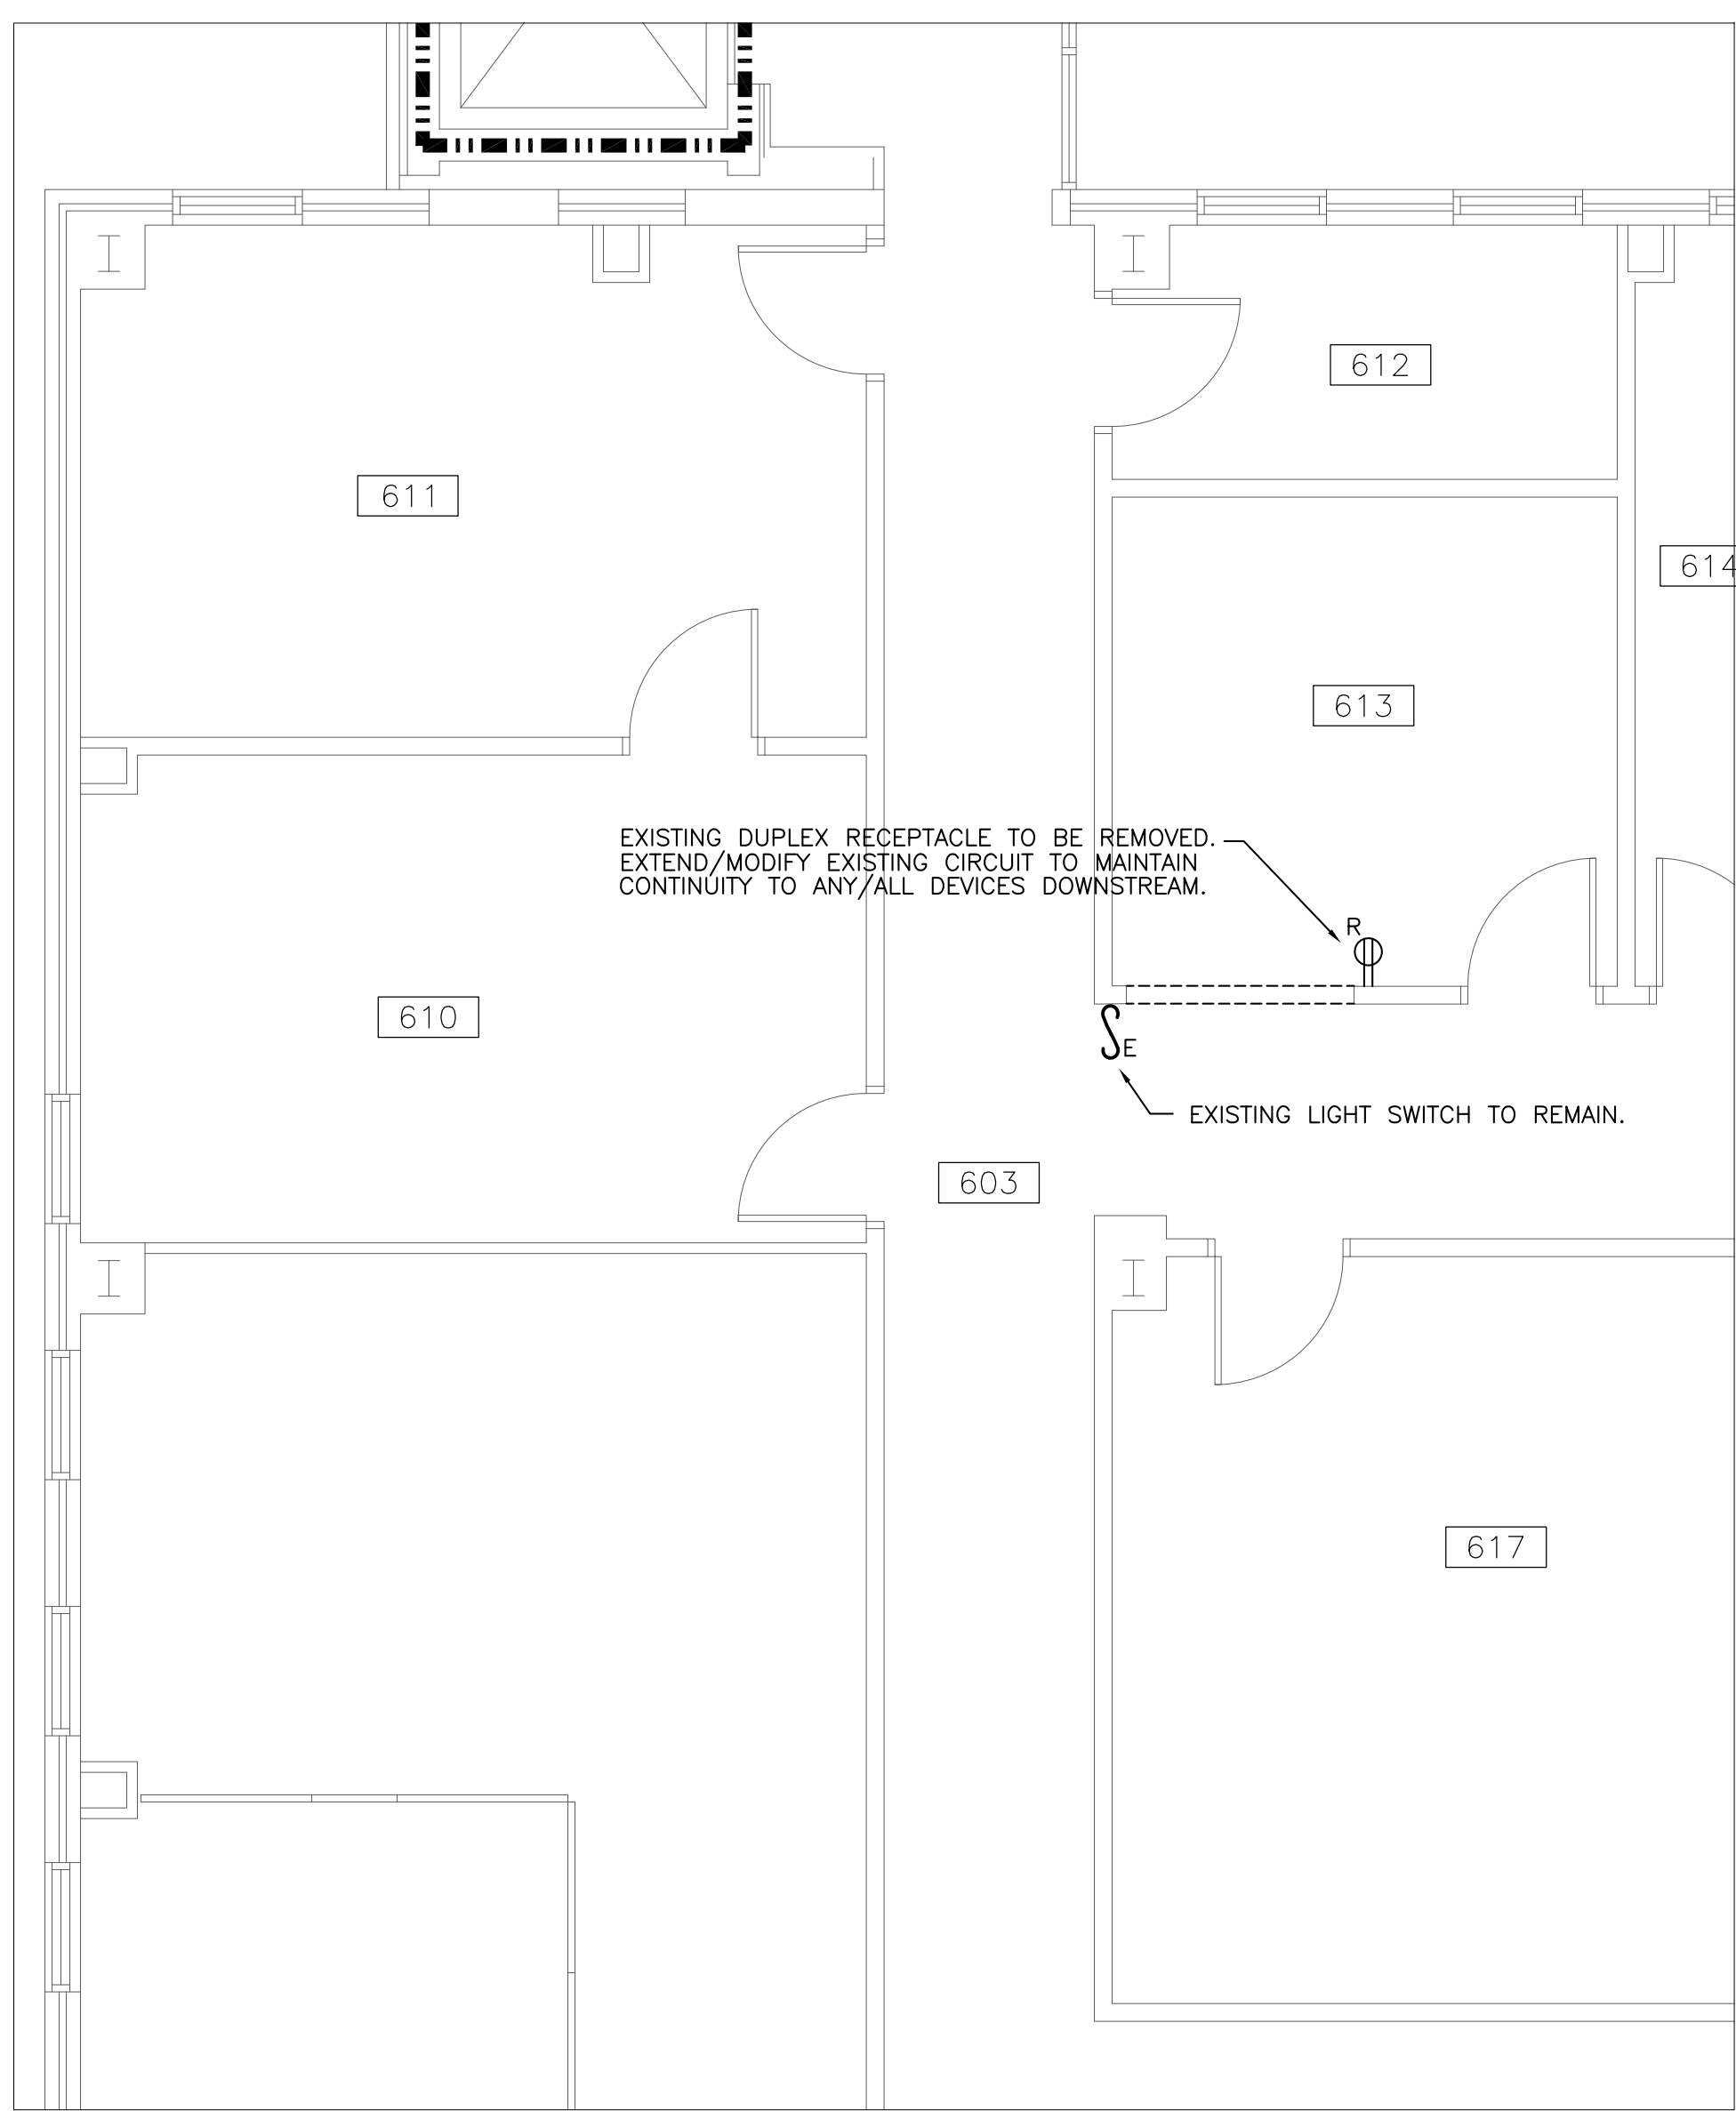


2
E4
6TH FLOOR PARTIAL
DEMOLITION PLAN
SCALE: 1/4" = 1'-0"

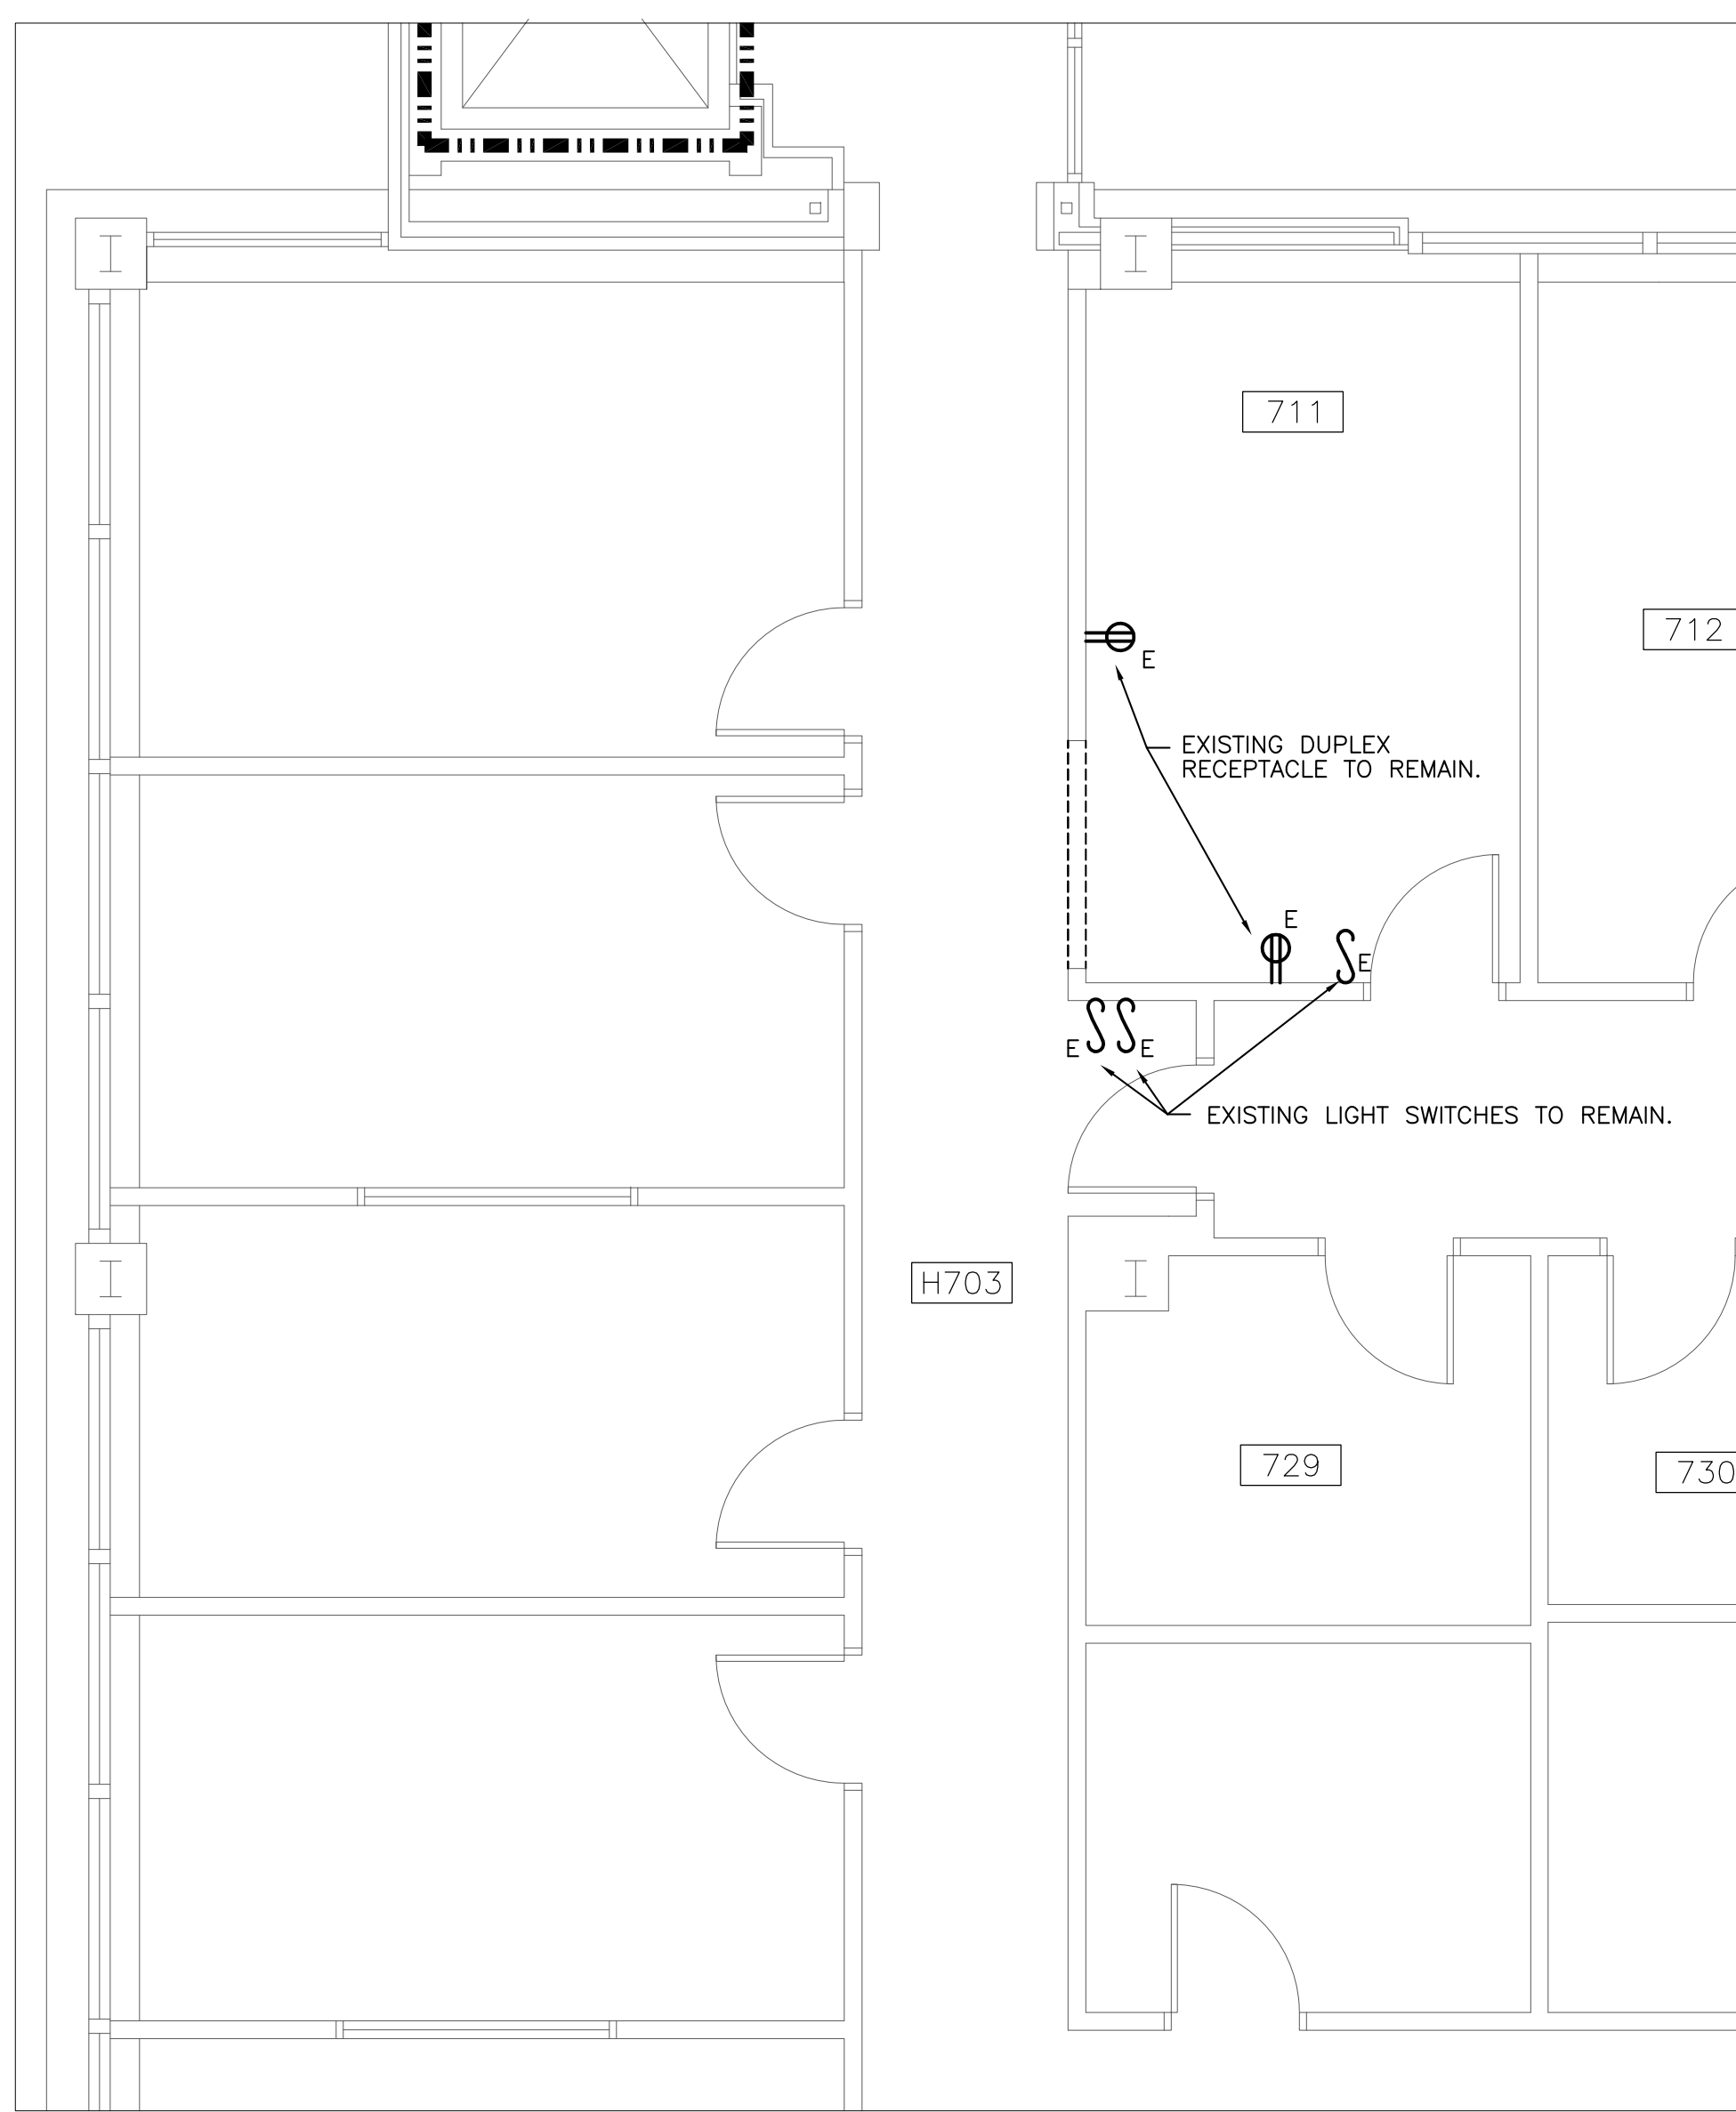


3
E4
7TH FLOOR PARTIAL
DEMOLITION PLAN
SCALE: 1/4" = 1'-0"

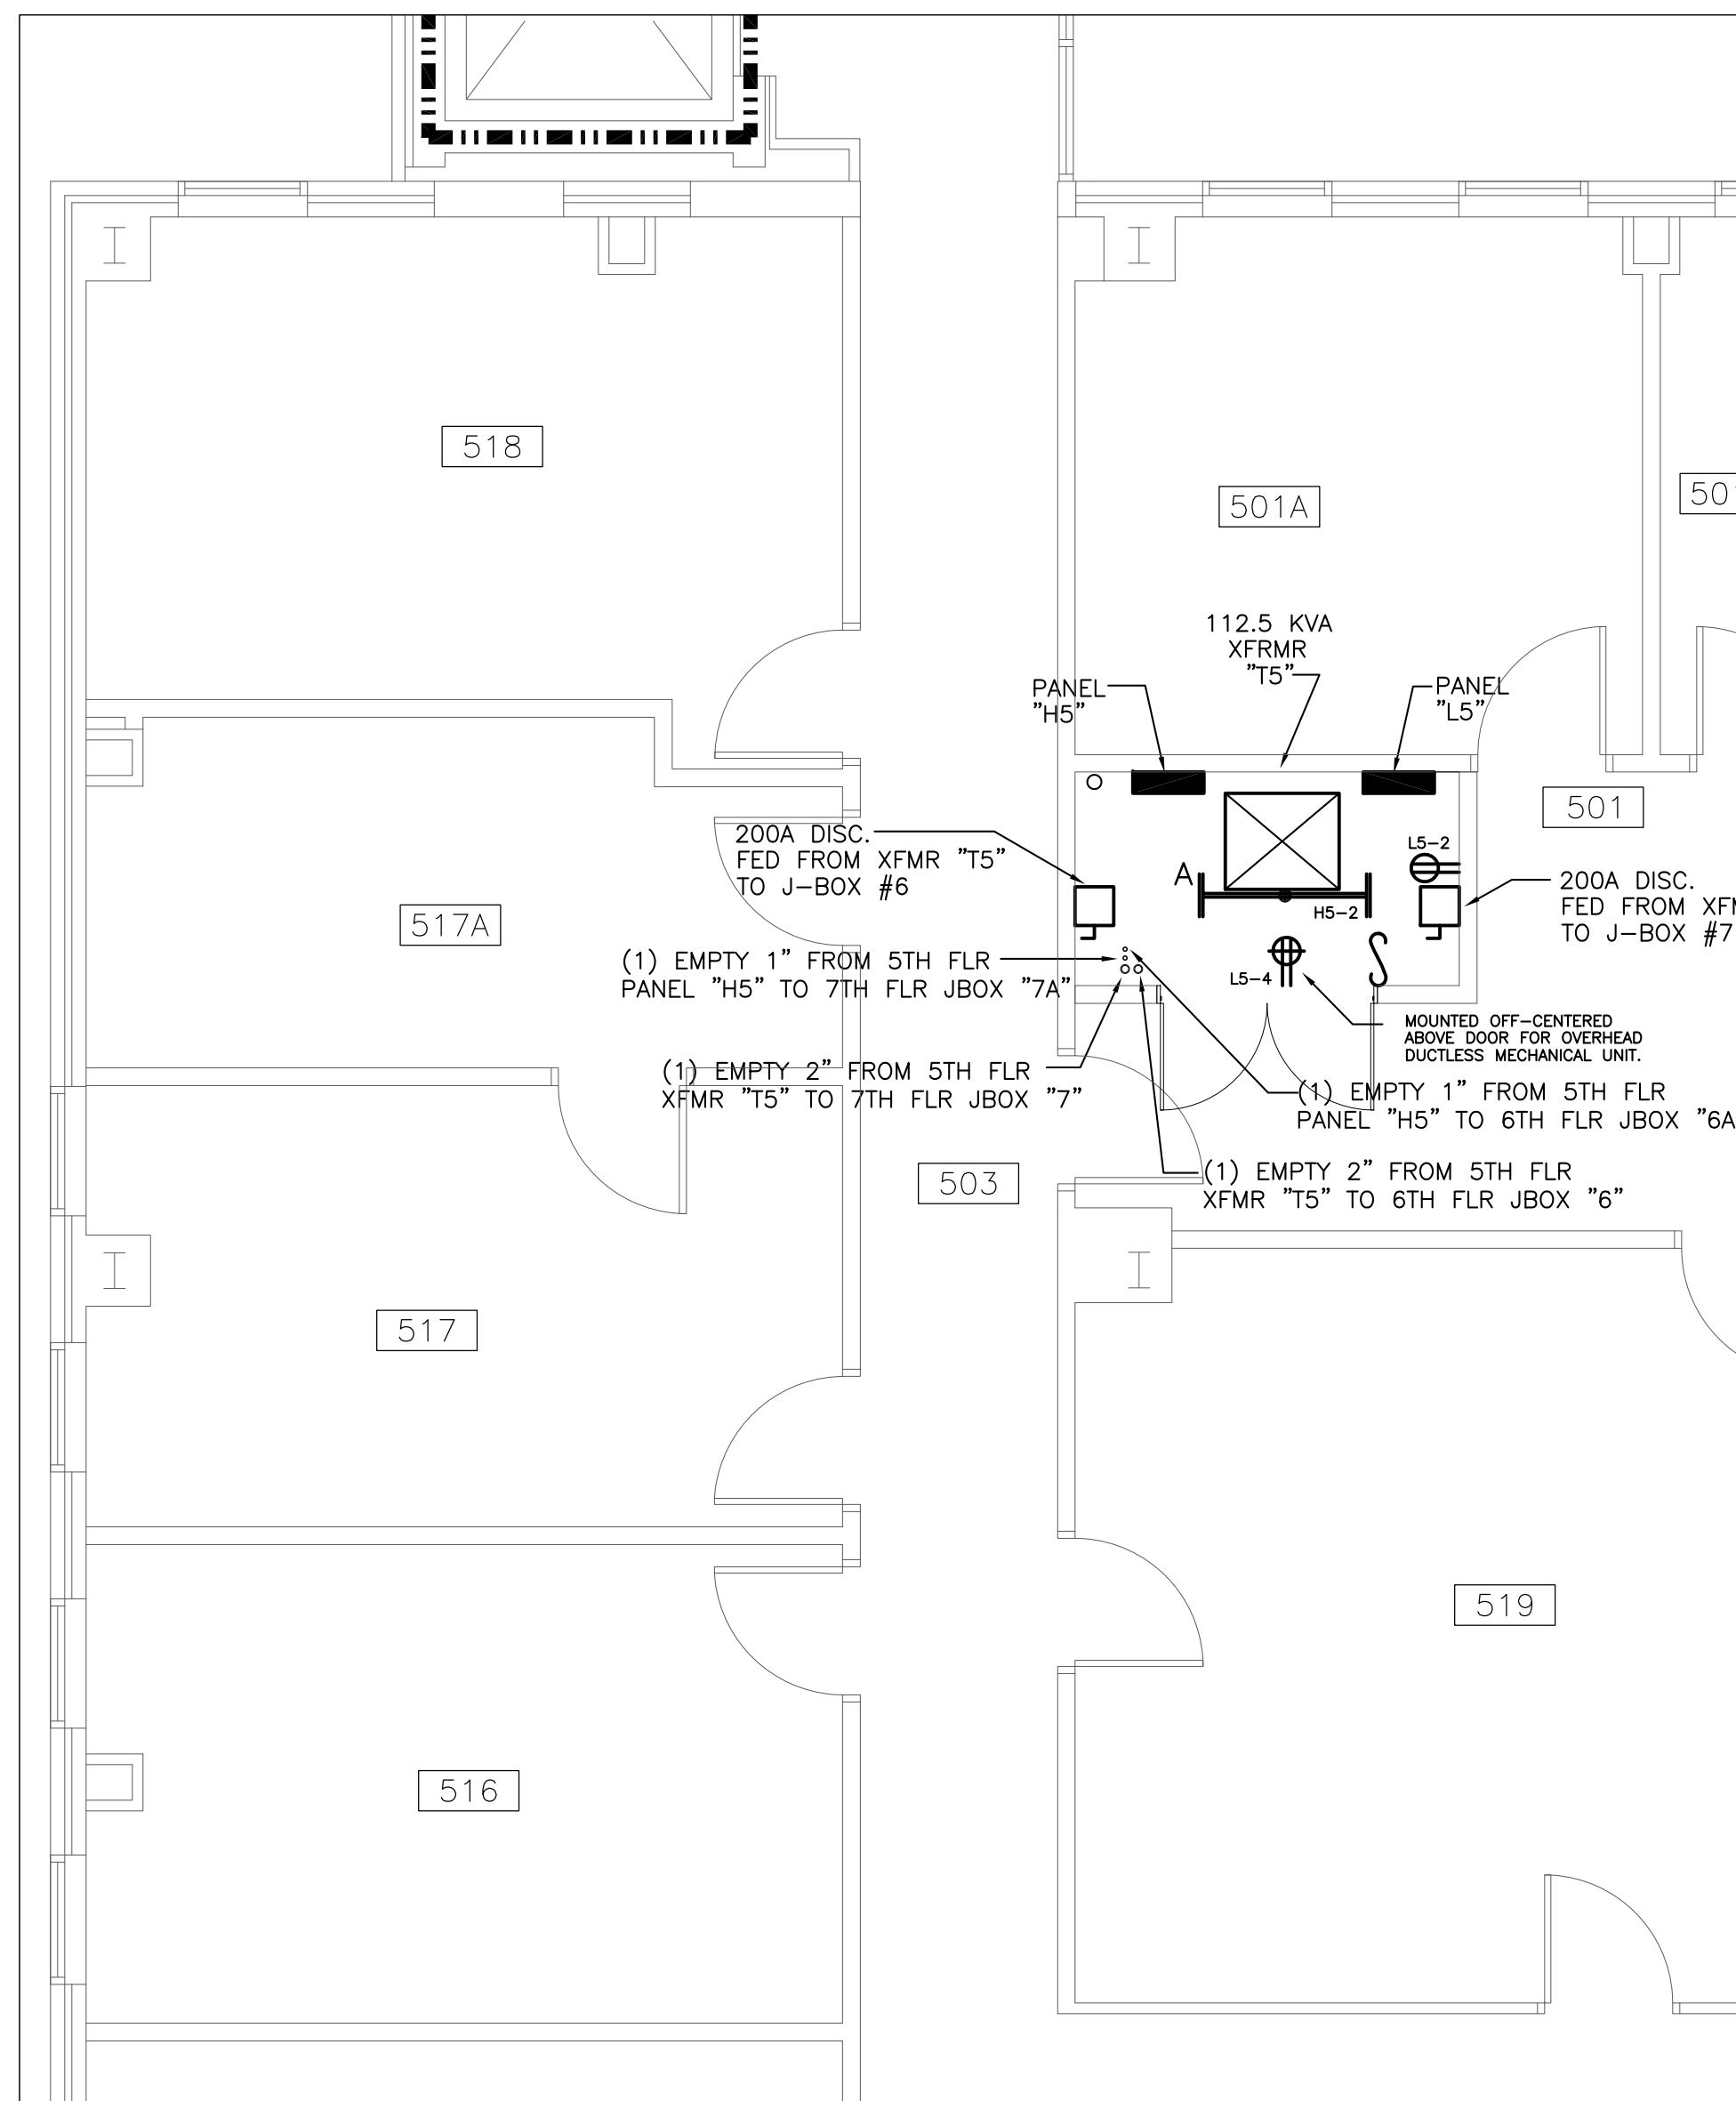




4
E4
5TH FLOOR
ELECTRICAL RM.
SCALE: 1/4" = 1'-0"

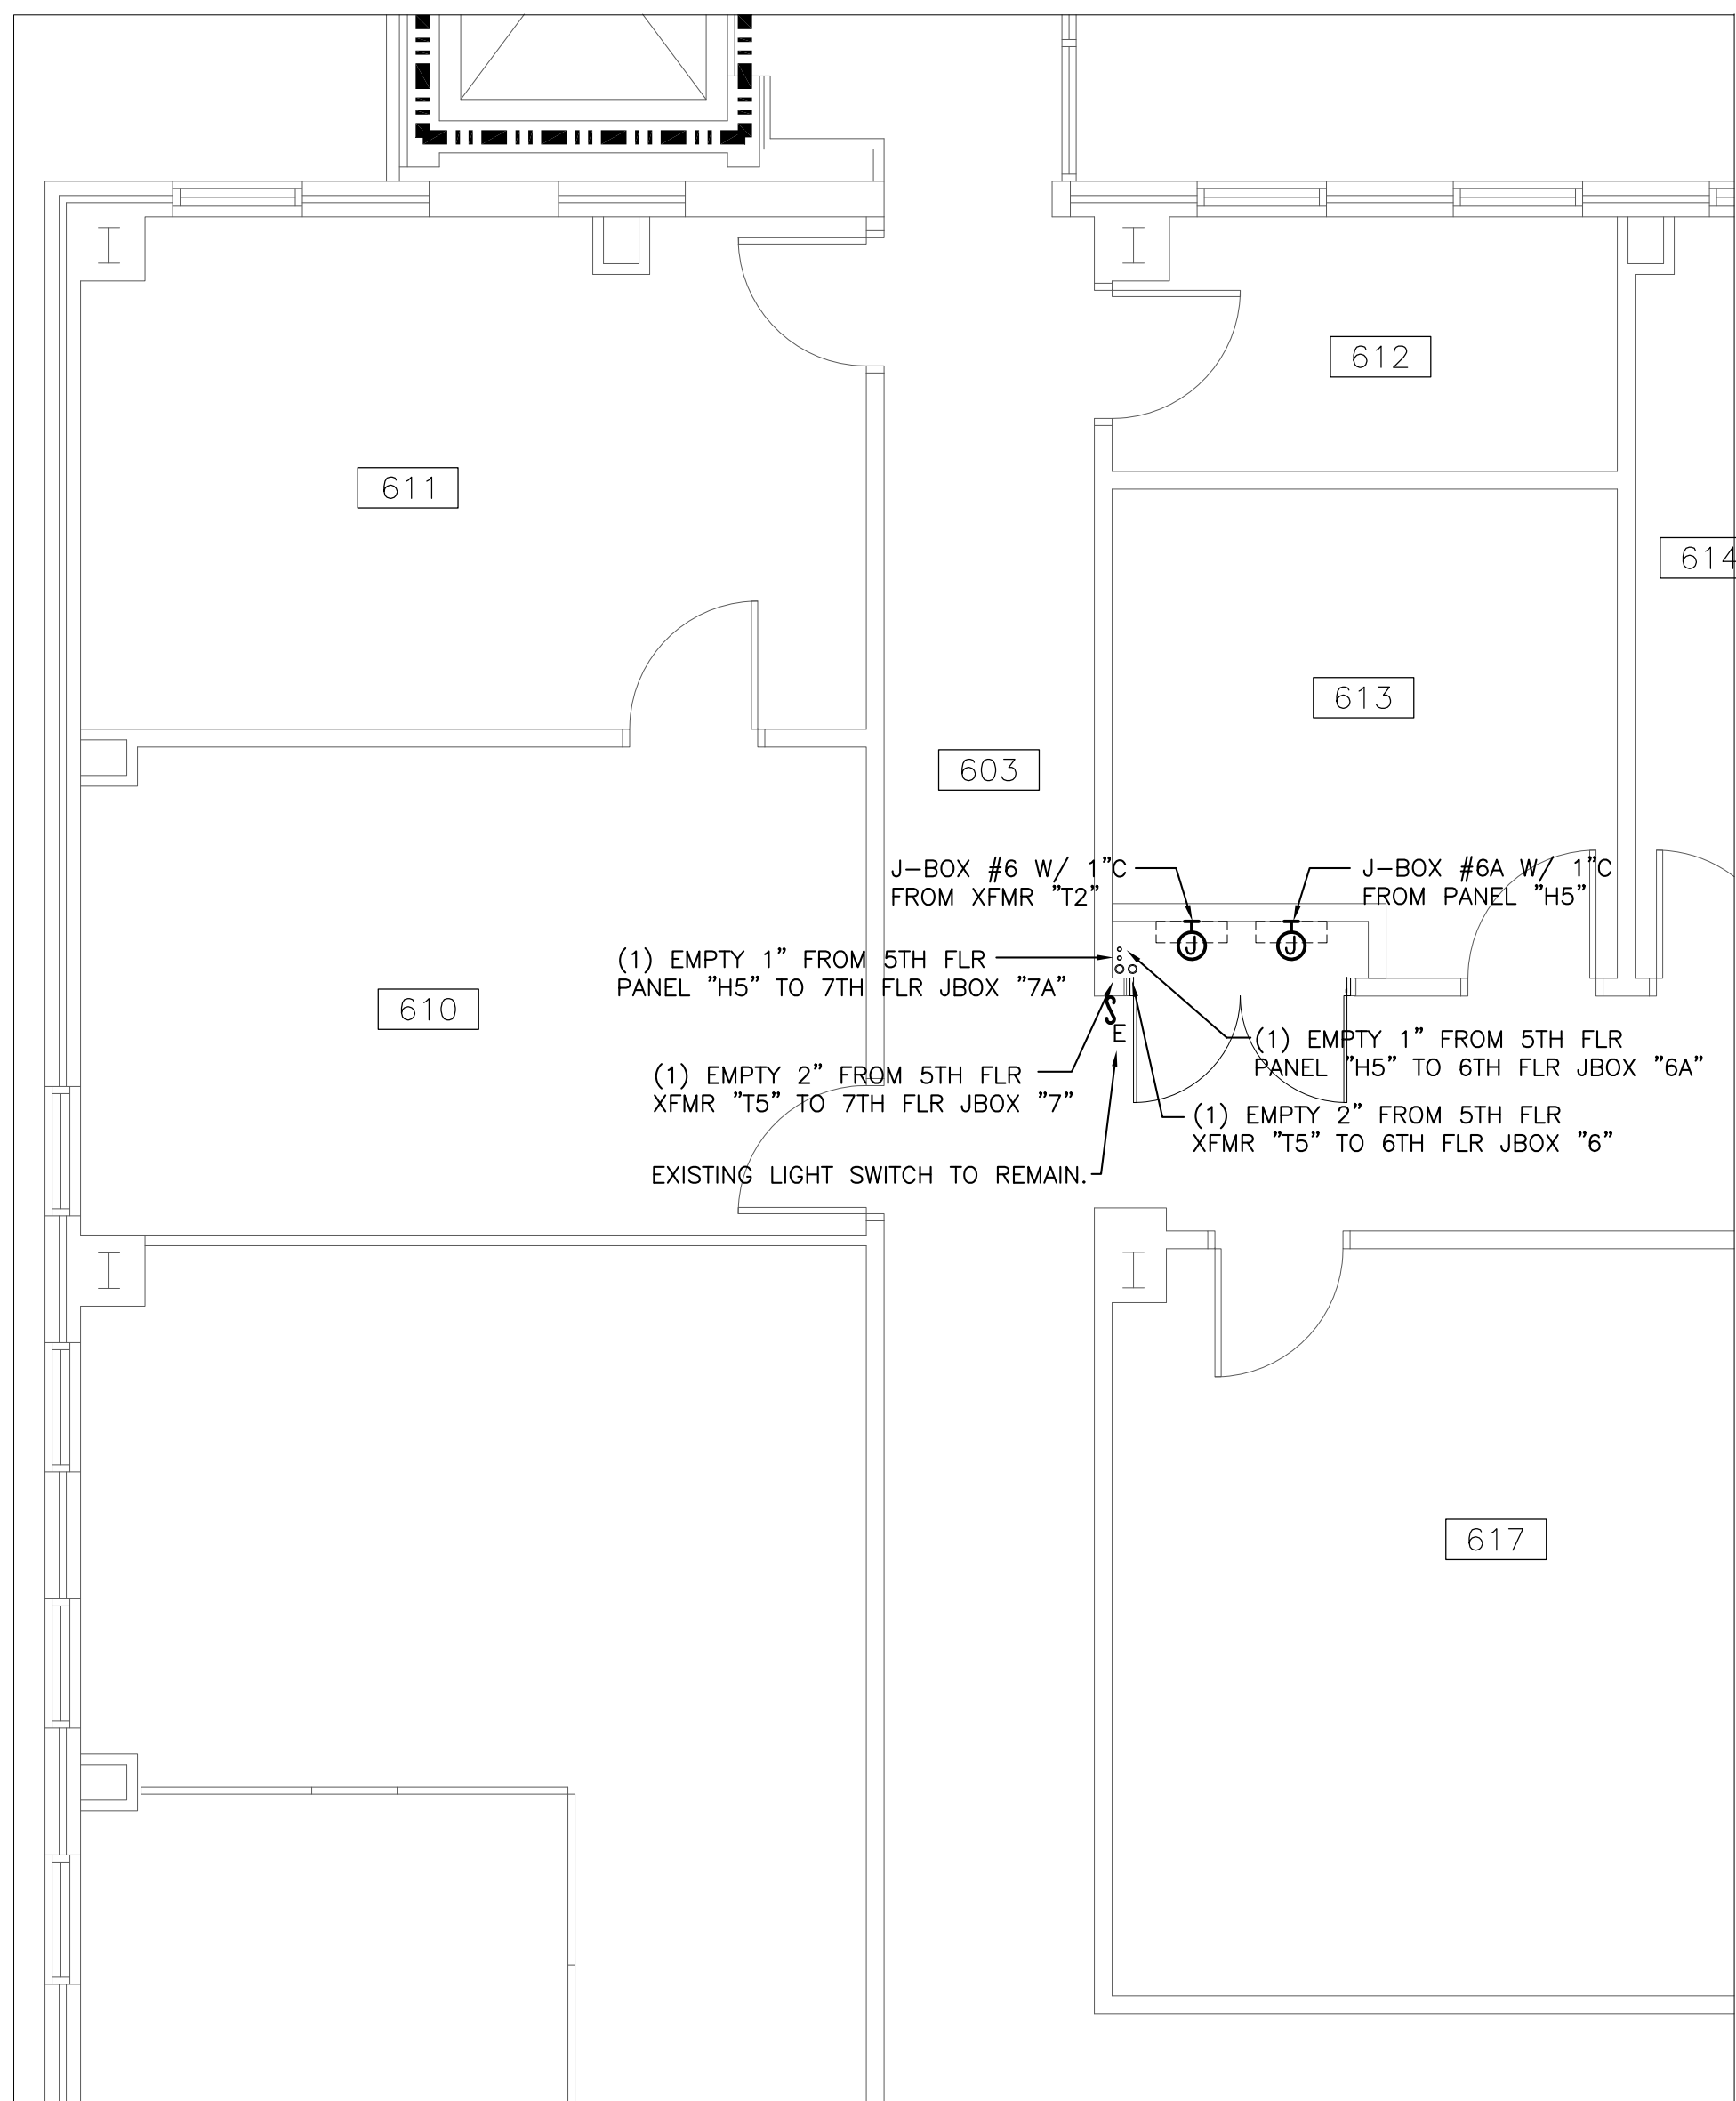

5
E4
6TH FLOOR
ELECTRICAL RM.
SCALE: 1/4" = 1'-0"

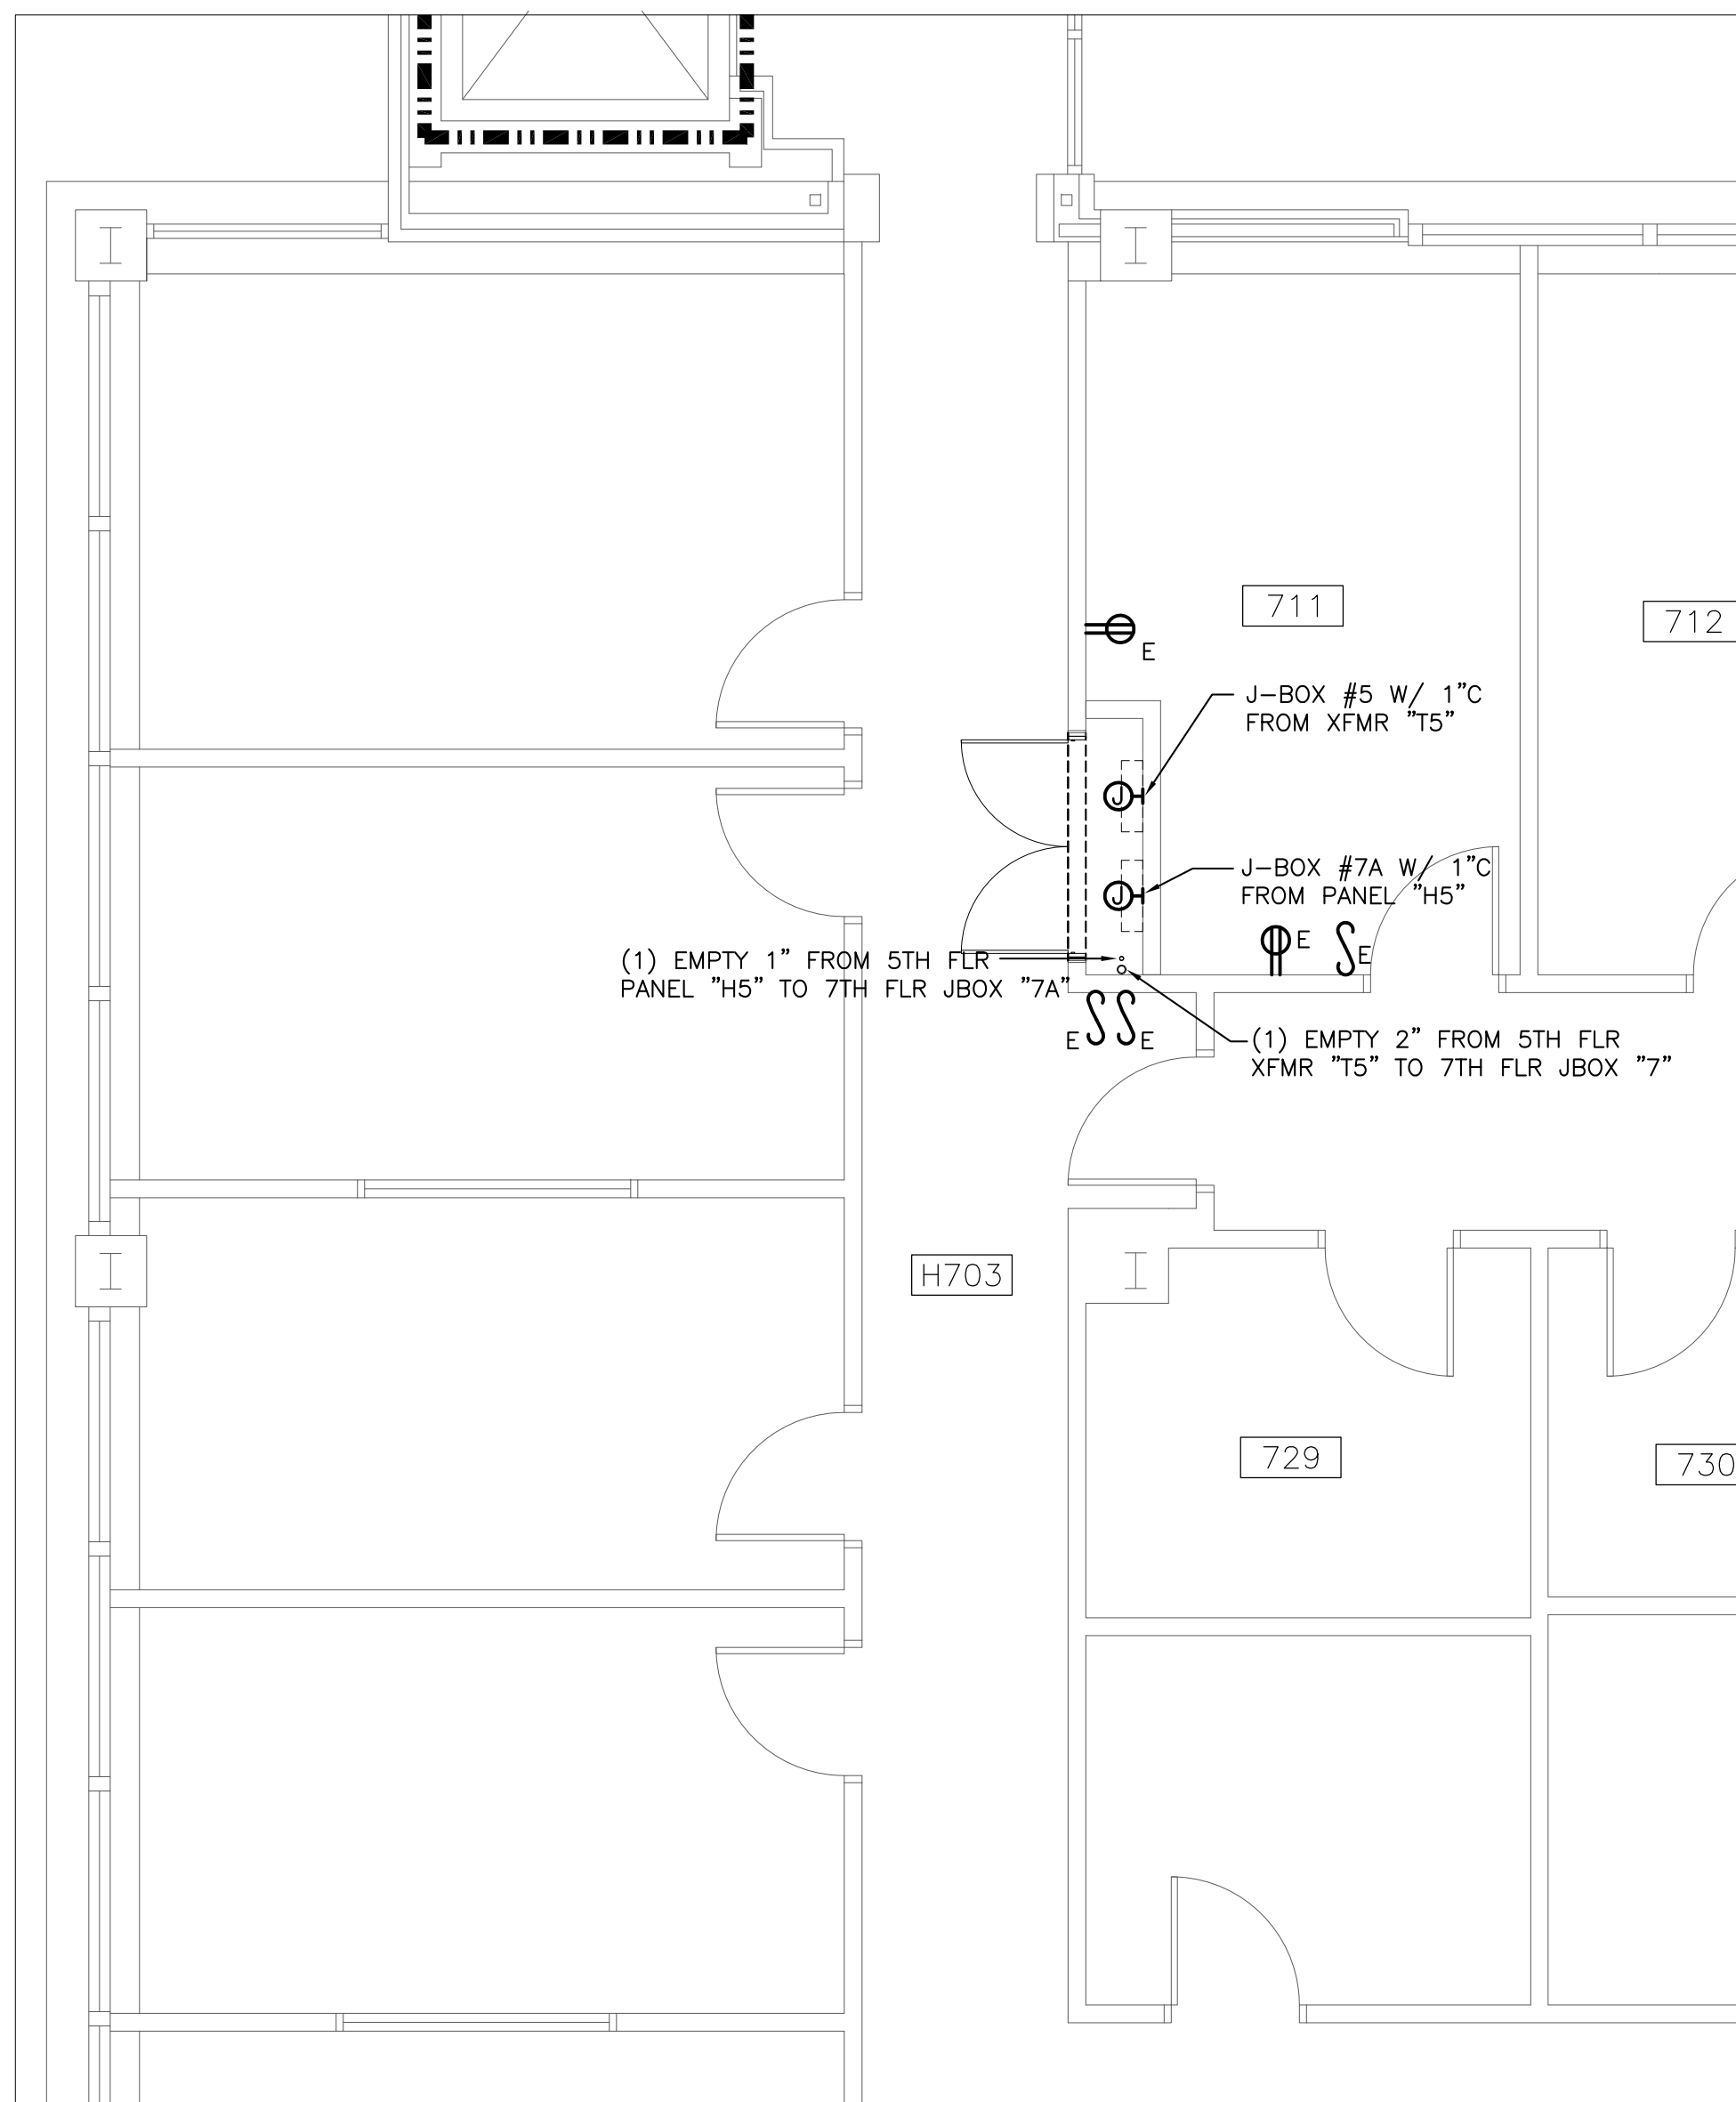

 6
E4
7TH FLOOR
ELECTRICAL RM.
SCALE: 1/4" = 1'-0"

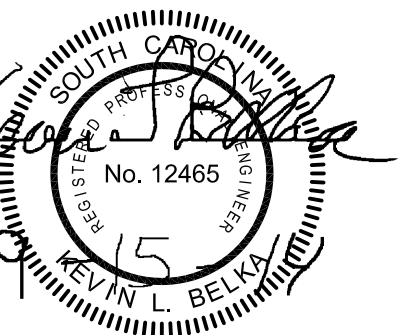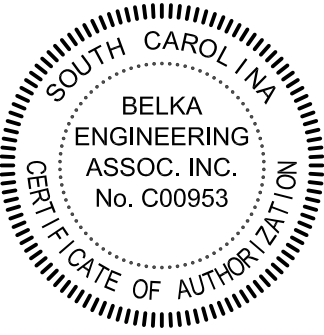

number	item	date
1	ADDENDUM 1	10/15/14

