



800 Columbiana Drive, Suite 208 • Irmo, SC • 29063 • 803-765-1007 • [www.simgroupusa.com](http://www.simgroupusa.com)

---

**USC CP00367346 DM12 USC A - Penland and H&SS Building Fire Alarm Upgrades**


ADDENDUM NO. 2  
February 27, 2015

This addendum modifies the Contract Documents only in the manner and to the extent stated herein and shown on any accompanying drawings and will become a part of the Contract Documents. Except as specified or otherwise indicated by this addendum, all work shall be in accordance with the basic requirements of the Contract Documents.

1. **DRAWINGS:**

- a. E001: General Notes No. 1 – Replace text “2008 NATIONAL ELECTRICAL CODE” with “2011 NATIONAL ELECTRICAL CODE”.
- b. E101(Penland):  
E101.1 (See attachment) – Change approximate location of fire alarm control panel and add one multi-detector in Mech/Elec room, add two ceiling mounted multi-detectors and one ceiling mounted strobe to Auditorium 106 located above aisles.
- c. E201(H&SS):  
E201.1 (See attachment) – Remove two beam type smoke detectors and add three ceiling mounted multi-detector in Auditorium 116 located above aisles.  
E201.2 (See attachment) – Remove two beam type smoke detectors and add three ceiling mounted multi-detector in Classroom 103 located above aisles.  
E201.3 (See attachment) – Change approximate location of fire alarm control panel in Elec. E-3.

Each Bidder shall acknowledge receipt of this Addendum and all other Addenda on his bid form.

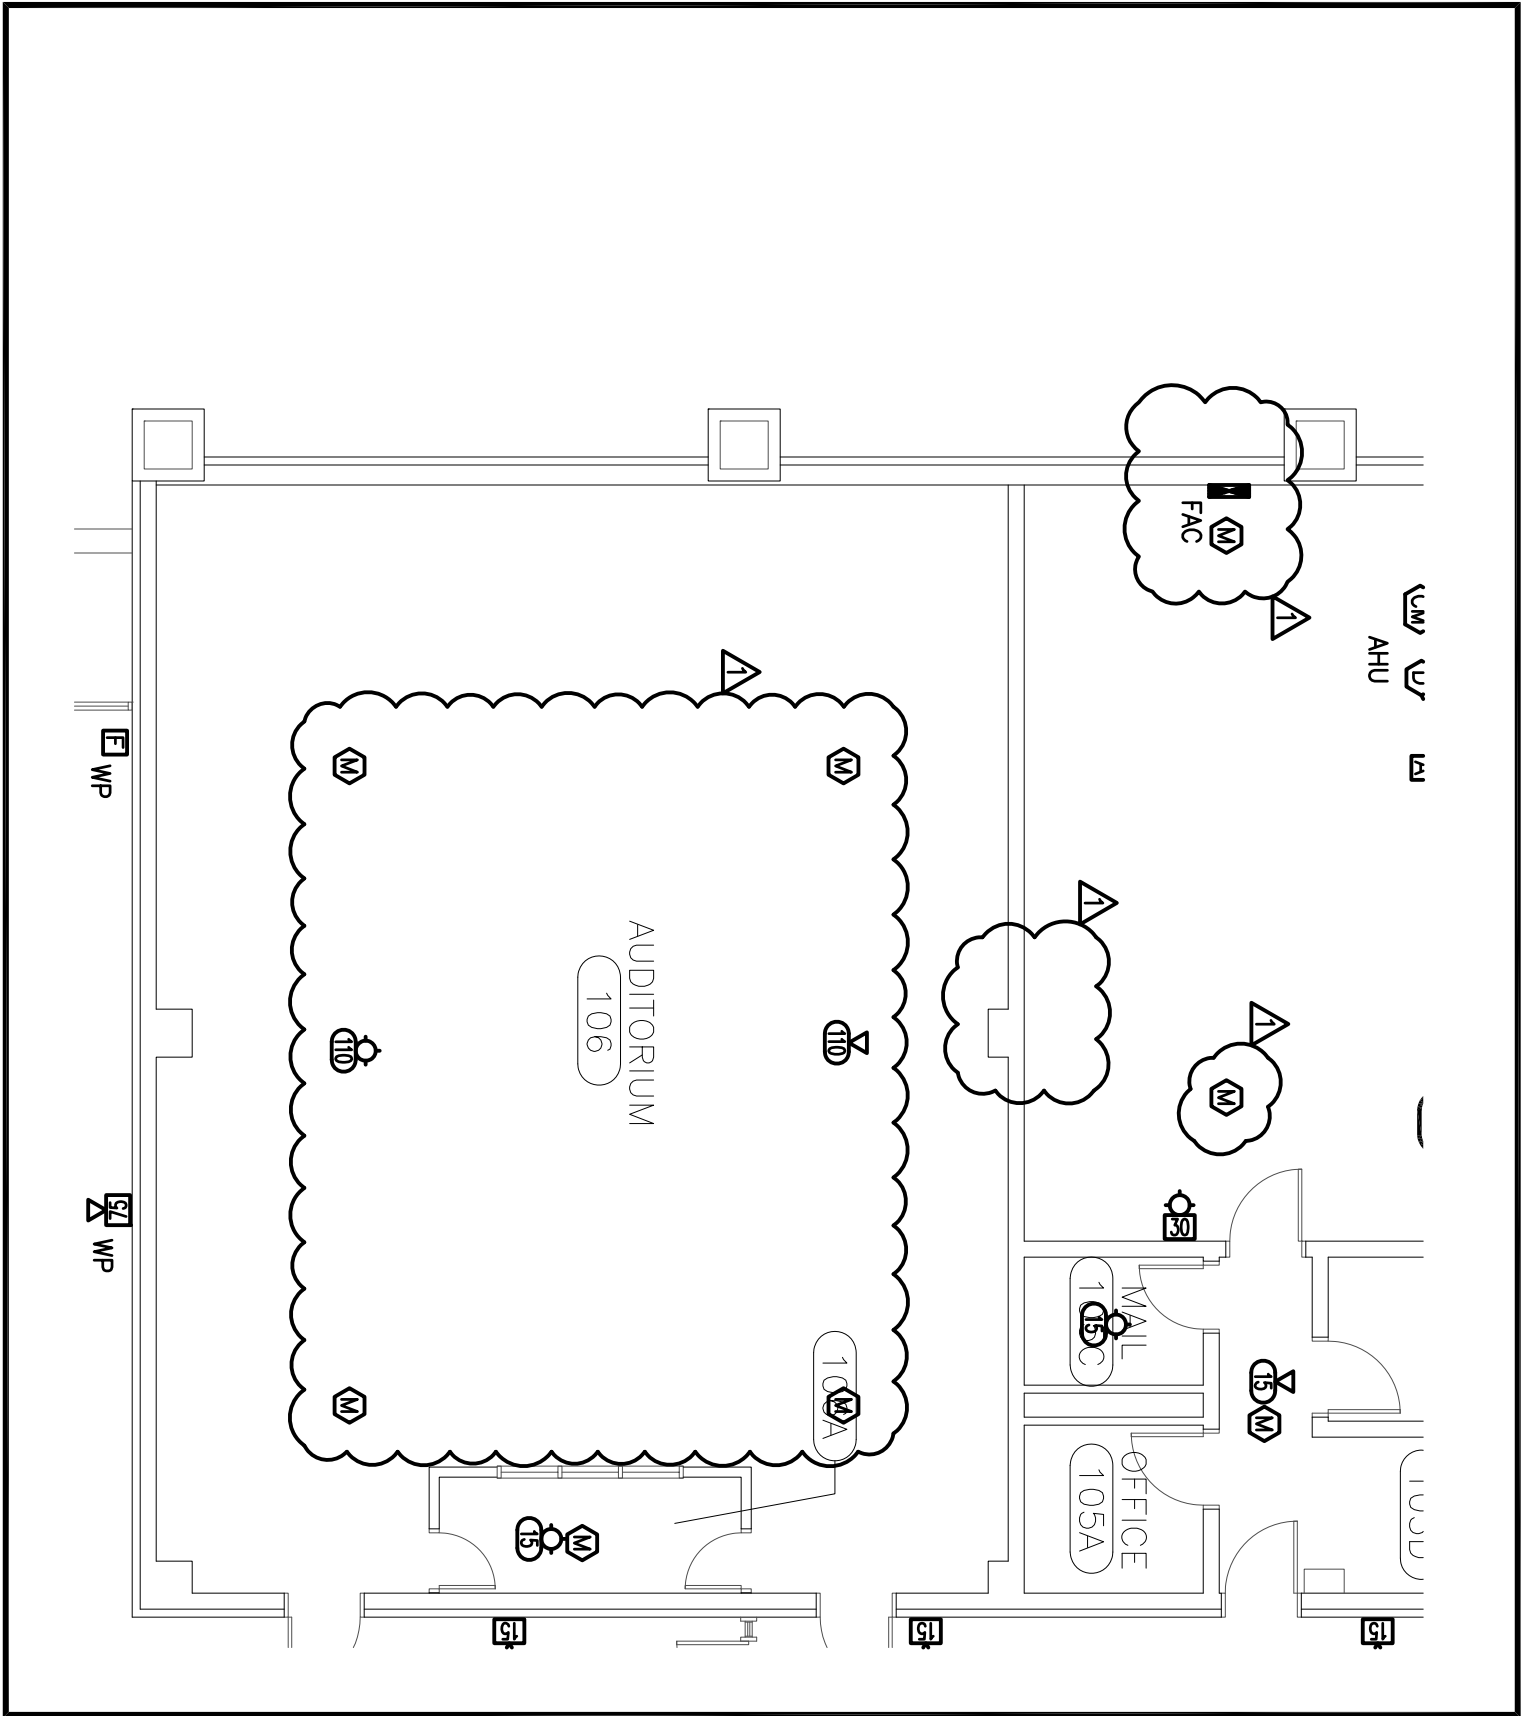


PROJECT NUMBER: C13047  
 REFERENCE DWG: E201  
 RFI/ADD./COR: ADD NO. 2  
**E101.1**  
 DATE: 27 FEBRUARY 2015

SHEET TITLE:  
**PENLAND  
 BUILDING  
 PARTIAL FIRST  
 FLOOR FIRE  
 ALARM PLAN**

PROJECT:  
 USCA PENLAND AND H&SS  
 BUILDING FIRE ALARM  
 UPGRADES

**sims group**   
 SIMS GROUP ENGINEERS, INC.  
 800 Columbiana Drive, Suite 208  
 Irmo, South Carolina 29063  
 Phone: (803) 765-1007 Fax: (803) 765-1030  
 www.simgroupusa.com

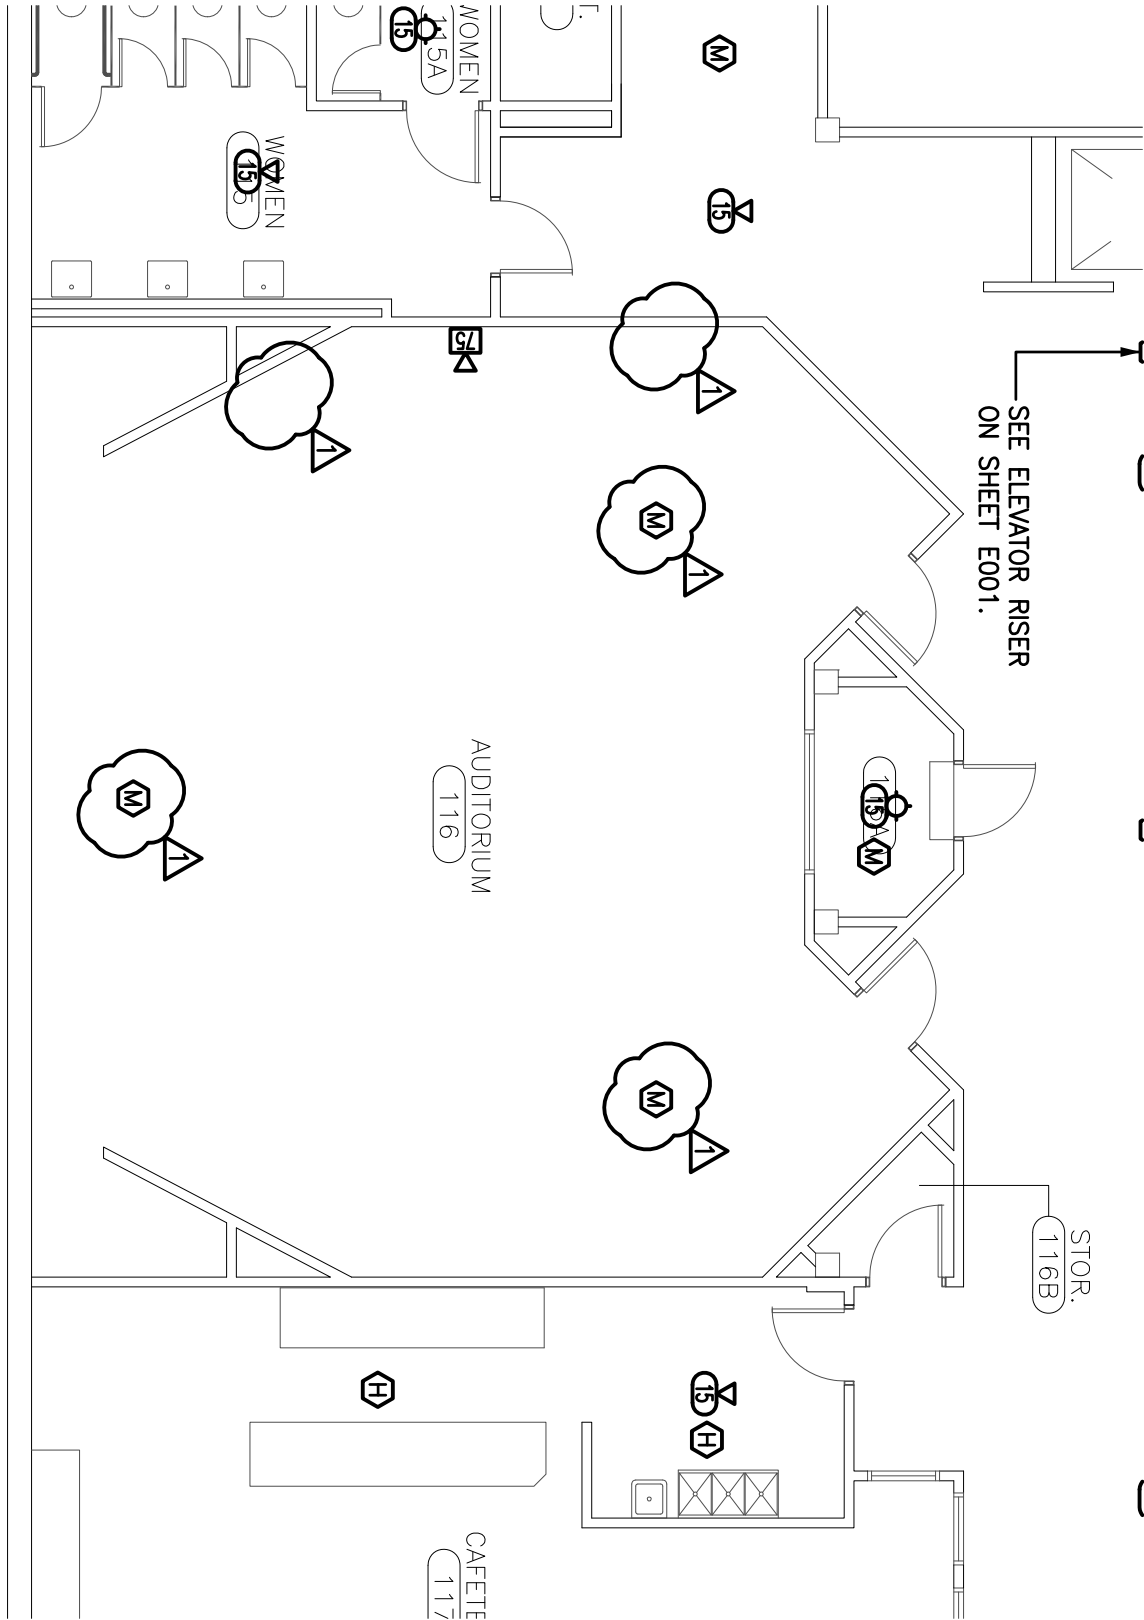

PROJECT NUMBER: C13047

REFERENCE DWG: E201

RFI/ADD./COR: ADD NO. 2

**E201.1**

DATE: 27 FEBRUARY 2015

SHEET TITLE:


**H AND SS  
BUILDING  
PARTIAL FIRST  
FLOOR FIRE  
ALARM PLAN**

PROJECT:

**USCA PENLAND AND H&SS  
BUILDING FIRE ALARM  
UPGRADES**

***sims group***

SIMS GROUP ENGINEERS, INC.  
800 Columbiana Drive, Suite 208  
Irmo, South Carolina 29063  
Phone: (803) 765-1007 Fax: (803) 765-1030  
www.simgroupusa.com

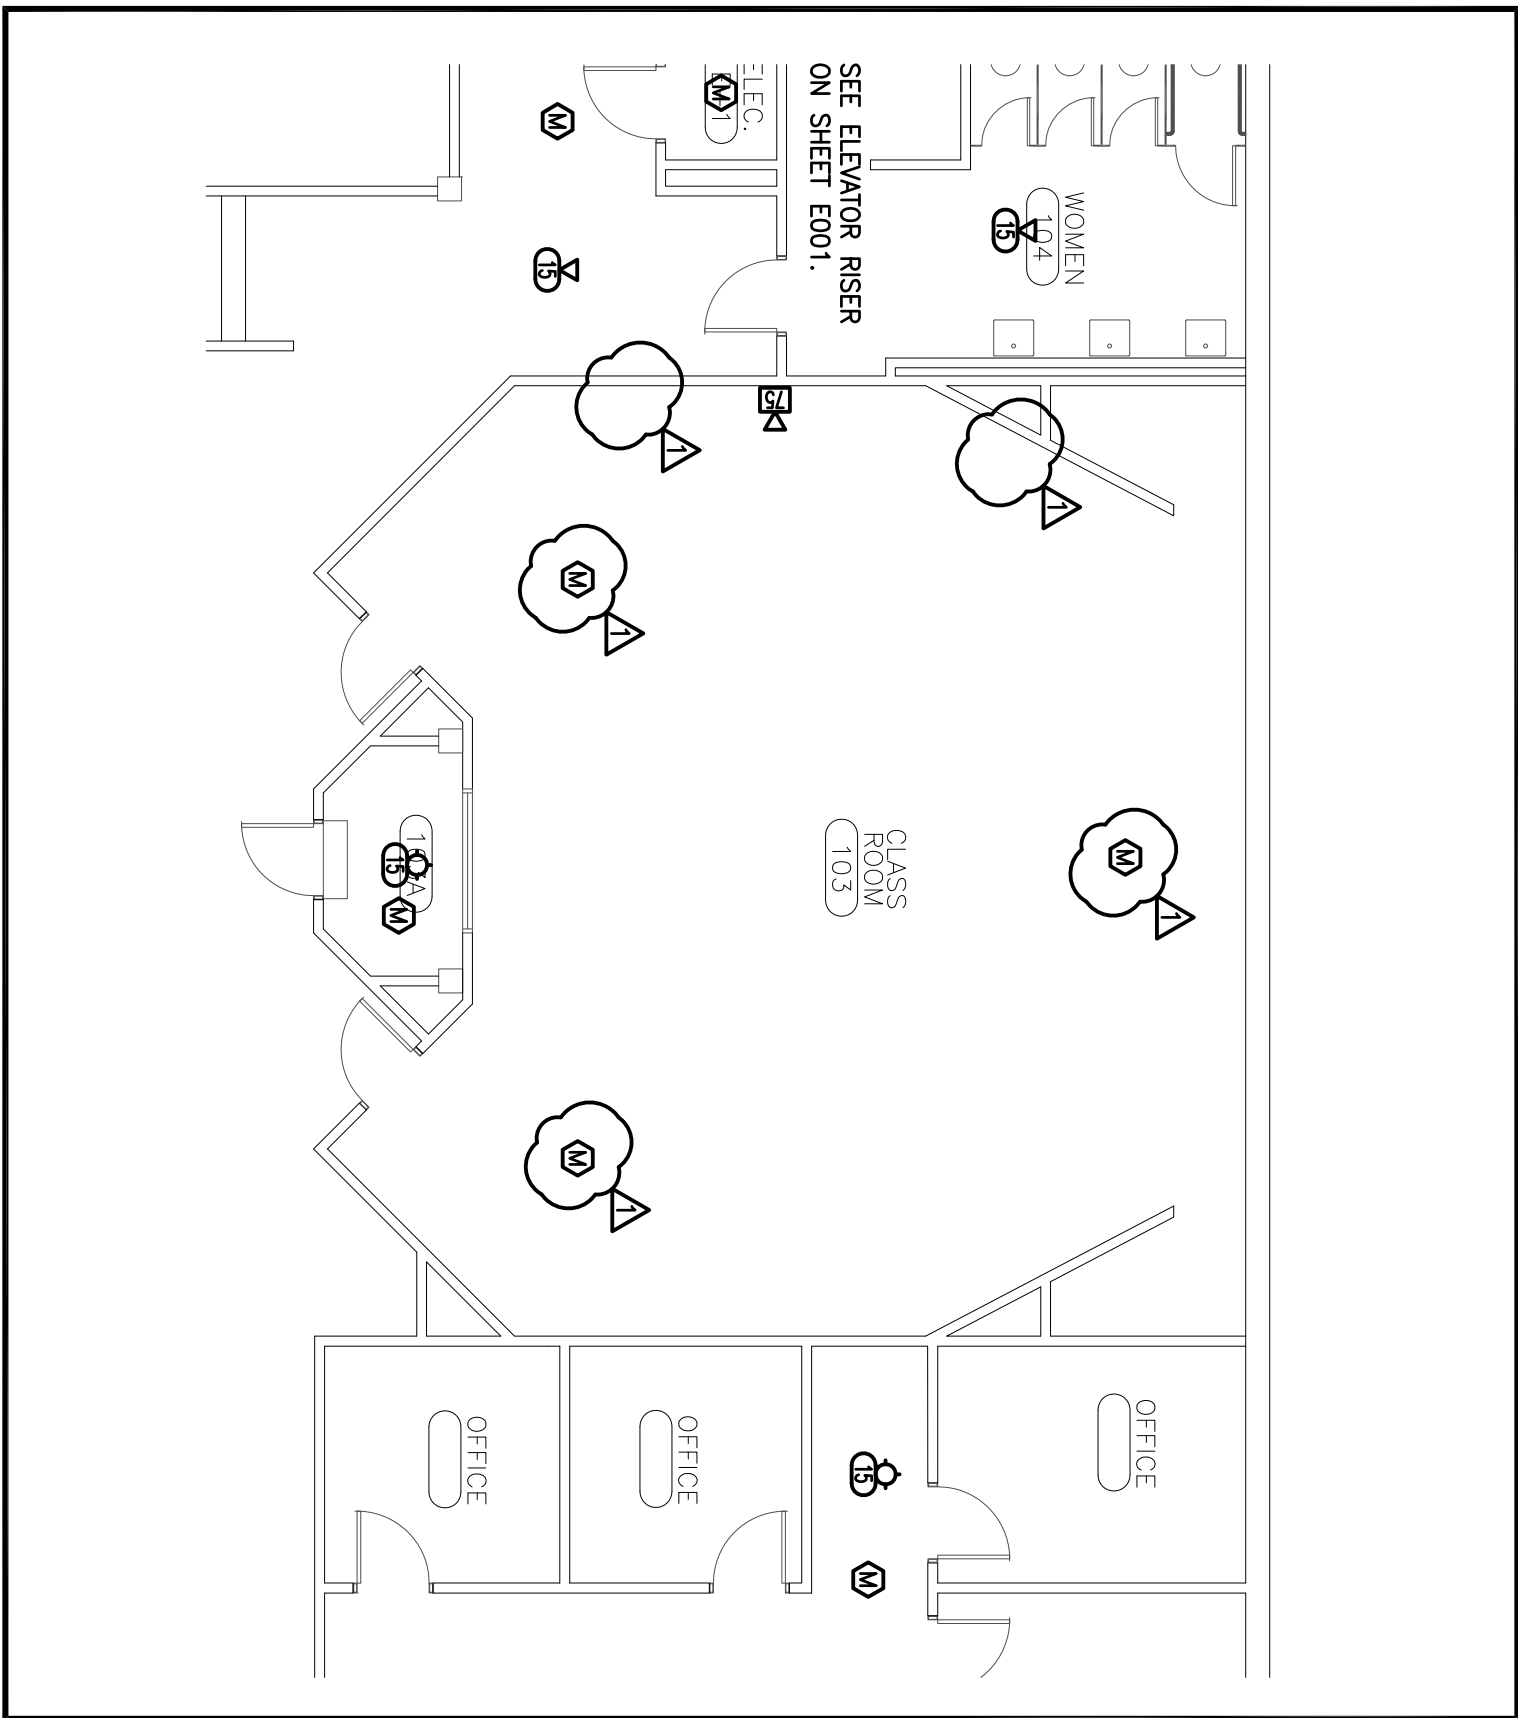


PROJECT NUMBER: C13047  
 REFERENCE DWG: E201  
 RFI/ADD./COR: ADD NO. 2  
**E201.2**  
 DATE: 27 FEBRUARY 2015

SHEET TITLE:  
**H AND SS BUILDING  
 PARTIAL FIRST FLOOR FIRE ALARM PLAN**

PROJECT:  
**USCA PENLAND AND H&SS BUILDING FIRE ALARM UPGRADES**

**sims group**   
 SIMS GROUP ENGINEERS, INC.  
 800 Columbiana Drive, Suite 208  
 Irmo, South Carolina 29063  
 Phone: (803) 765-1007 Fax: (803) 765-1030  
 www.simgroupusa.com

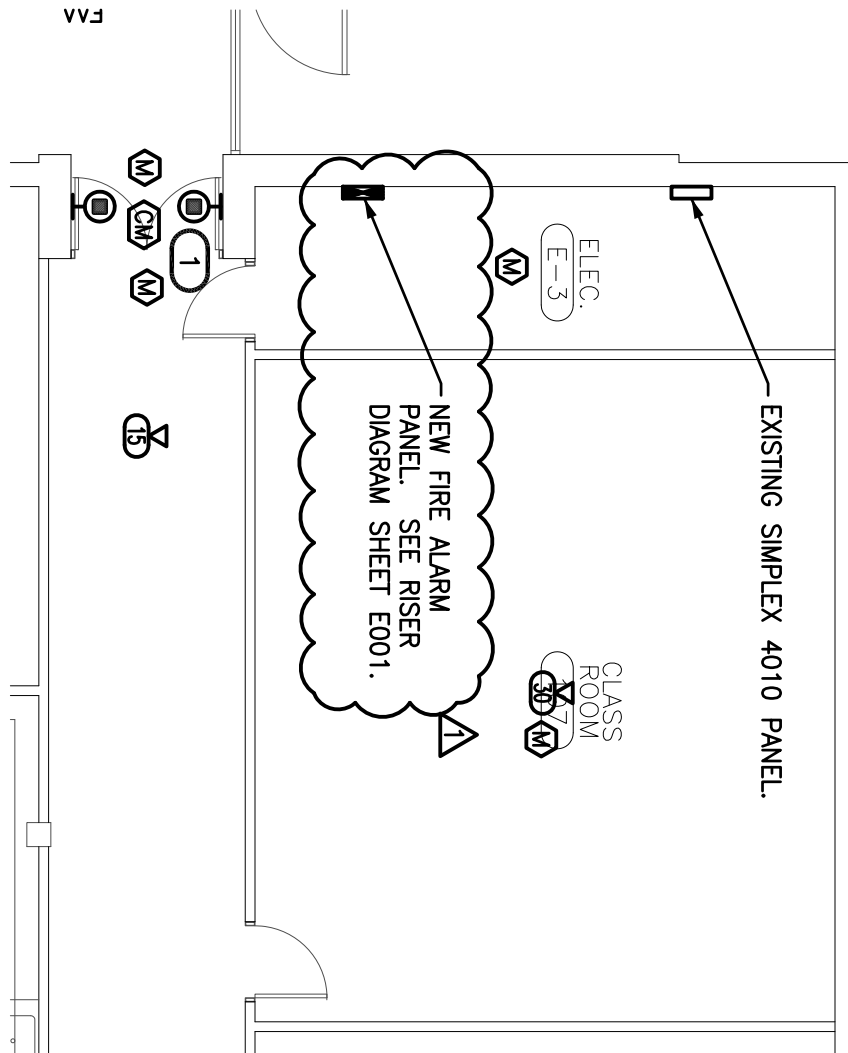

PROJECT NUMBER: C13047

REFERENCE DWG: E201

RFI/ADD./COR: ADD NO. 2

**E201.3**

DATE: 27 FEBRUARY 2015

SHEET TITLE:

**H AND SS  
BUILDING  
PARTIAL FIRST  
FLOOR FIRE  
ALARM PLAN**

PROJECT:

**USCA PENLAND AND H&SS  
BUILDING FIRE ALARM  
UPGRADES**

***sims group***

SIMS GROUP ENGINEERS, INC.  
800 Columbiana Drive, Suite 208  
Irmo, South Carolina 29063  
Phone: (803) 765-1007 Fax: (803) 765-1030  
[www.simgroupusa.com](http://www.simgroupusa.com)