


# UNIVERSITY OF SOUTH CAROLINA UPSTATE MEDIA BUILDING FIRE ALARM REPLACEMENT

SPARTANBURG, SOUTH CAROLINA



S.C. PROJECT NO. H34-I357

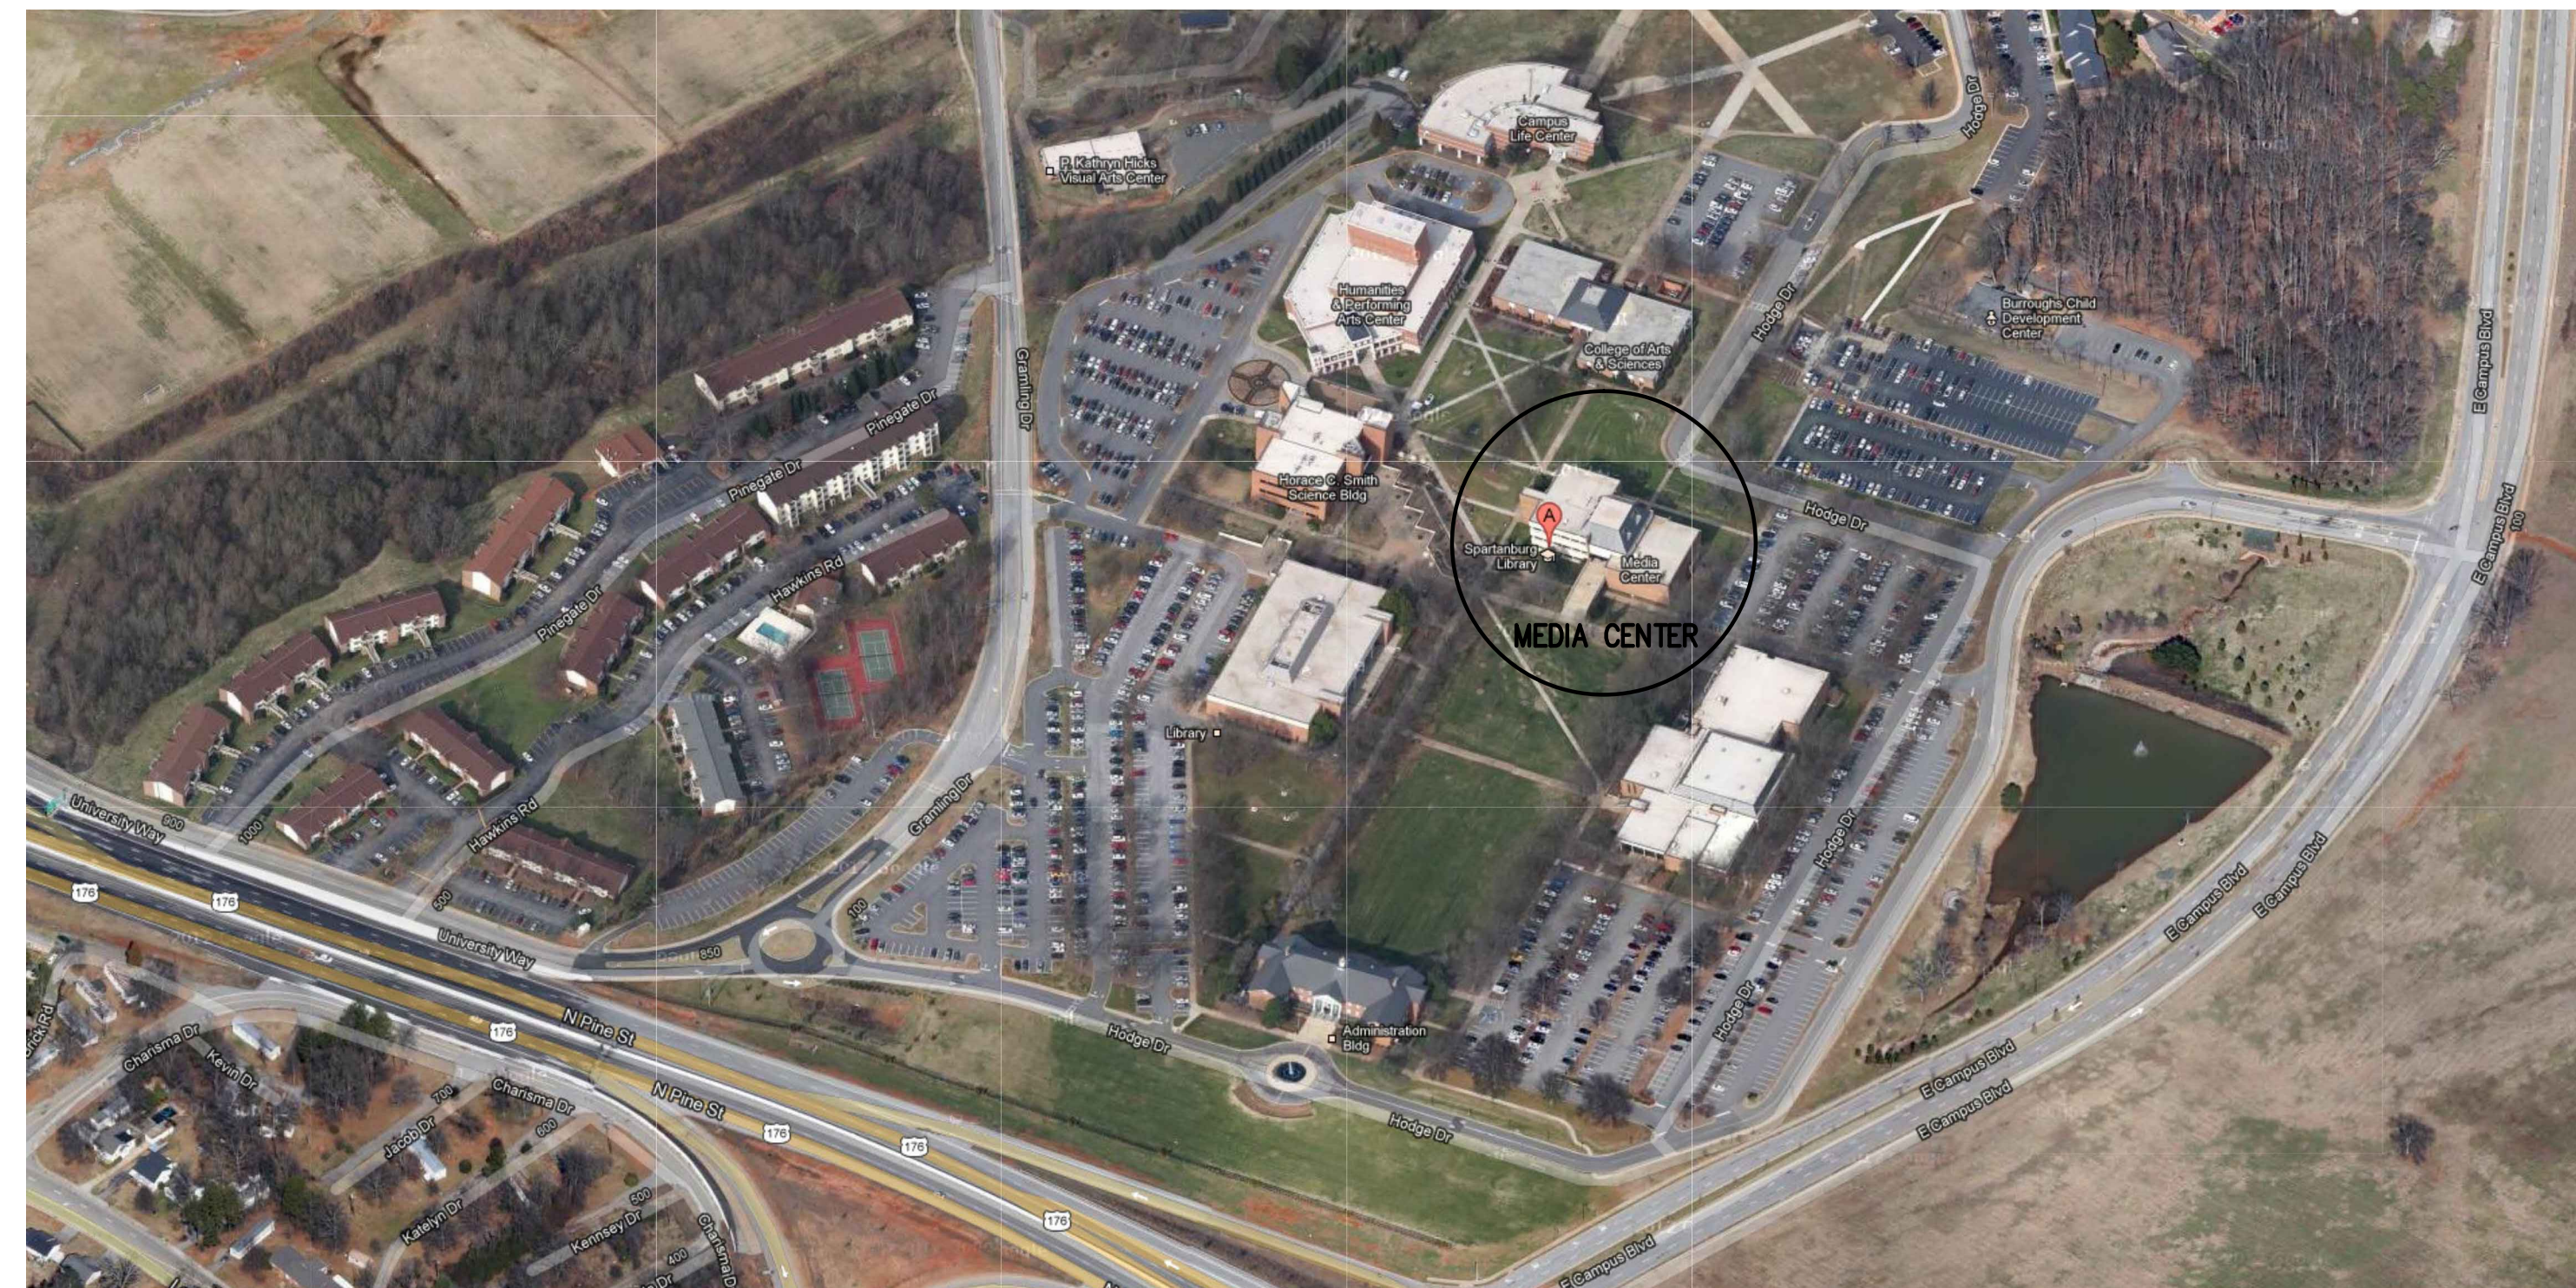

**USC UPSTATE MEDIA BUILDING**

800 UNIVERSITY WAY  
SPARTANBURG, SC 29303

(864)503-5620

### DRAWING LIST:

- T0.1 TITLE SHEET
- E0.1 FIRE ALARM LEGEND & DETAILS
- E1.1 ELECTRICAL FIRE ALARM PLAN - 1ST FLOOR
- E1.2 ELECTRICAL FIRE ALARM PLAN - 2ND FLOOR
- E1.3 ELECTRICAL FIRE ALARM PLAN - 3RD FLOOR
- E1.4 ELECTRICAL FIRE ALARM PLAN - PENTHOUSE
- E2.1 ELECTRICAL FIRE ALARM PLAN DEMOLITION PLAN

**BURDETTE  
ENGINEERING**  
102 PILGRIM ROAD  
GREENVILLE, SC 29607  
(864)297-8717 TEL  
(864)297-8719 FAX

REVISION	DATE	BY
A ISSUE FOR REVIEW	1/4/13	JDV
B FINAL ISSUE FOR REVIEW	2/8/13	JDV

UNIVERSITY OF SC UPSTATE  
**MEDIA BUILDING**  
FIRE ALARM REPLACEMENT  
S.C. PROJECT NO. H34-I357  
SPARTANBURG, SOUTH CAROLINA  
**UPSTATE**  
USC

SHEET NUMBER

T0.1

1 OF 7 SHEETS