


A ELECTRICAL FIRE ALARM PLAN - PENTHOUSE
 E1.4 SCALE: 1/8" = 1'-0"

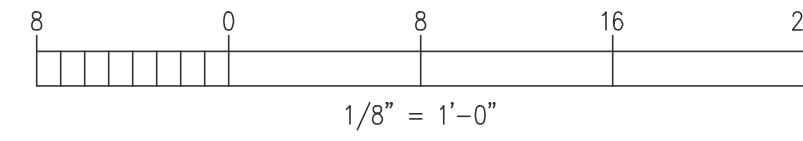

UNIVERSITY OF SC UPSTATE
 MEDIA BUILDING
 FIRE ALARM REPLACEMENT
 SC PROJECT NO. H24-137
 SPARTANBURG, SOUTH CAROLINA



SHEET NUMBER

E1.4

6 OF 7 SHEETS

PROJECT NO.	128608
DATE	08.24.2012
DRAWN BY	EMF/JDY
CHECKED BY	DJB

REVISION	DATE	BY
A ISSUE FOR REVIEW	1/4/13	JDY
B FINAL ISSUE FOR REVIEW	2/8/13	JDY

BURDETTE ENGINEERING
 102 PILGRIM ROAD
 GREENVILLE, SC 29607
 (864)297-8717 TEL
 (864)297-8719 FAX